

KRUGER BENSON ZIEMER  
ARCHITECTS, INC. AIA  
30 W. ARRELLAGA SANTA BARBARA, CA.  
805/963.1726 93101

STEVE DOWTY, A.I.A.  
PRINCIPAL IN CHARGE

GERALD SHUSTA  
PROJECT ARCHITECT

All items, design arrangements and plans indicated or represented by this drawing are subject to and are the property of Kruger-Benson-Ziemer, Inc. and its associated entities. Items of this nature, arrangements or plans that are not specifically indicated in any portion, shall be considered as not part of the contract. The entire contents of this drawing are subject to the terms and conditions of the contract.


DALAN ENGINEERING, INC.  
ELECTRICAL ENGINEERS  
DALAN JOB No AA181

8638 DARBY AVENUE (714) 771-4221  
NORTHIDGE, CA. 91325 (805) 684-4944  
(818) 772-2220 FAX (818) 772-2230

PLAN NOTES:


- 1 EXTEND FROM EXISTING INITIATING CIRCUIT TO NEW PULL STATION. ADD NEW 3/4" C. WITH CABLE "1A" NEW PULL STATION SHALL BE ON EXISTING LOOP 2
- 2 THIS DUCT DETECTOR SHALL HAVE A RELAY BASE AND TO BE WIRED TO SHUT DOWN BOTH SUPPLY AND RETURN FANS OF "1A"-2". PROVIDE 1/2" C.-2#14 TO "YSY" OF BOTH MOTORS.
- 3 THIS DUCT DETECTOR SHALL HAVE A RELAY BASE AND SHALL BE WIRED WITH 1/2" C.-2#12 TO DROP THE FIRE DOOR IN FRONT OF ELEVATOR.
- 4 DUCT DETECTORS FURNISHED AND INSTALLED BY FIRE ALARM CONTRACTOR. PROVIDE CONDUIT AND WIRE TO DROP ALL SMOKE FIRE DAMPERS. SEE MECHANICAL DRAWINGS FOR LOCATIONS OF ALL DAMPERS.
- 5 CONTROL MODULE TO DROP FIRE DOOR IN FRONT OF LAB. SERVICE ROOM.

*Elevator Door went away*

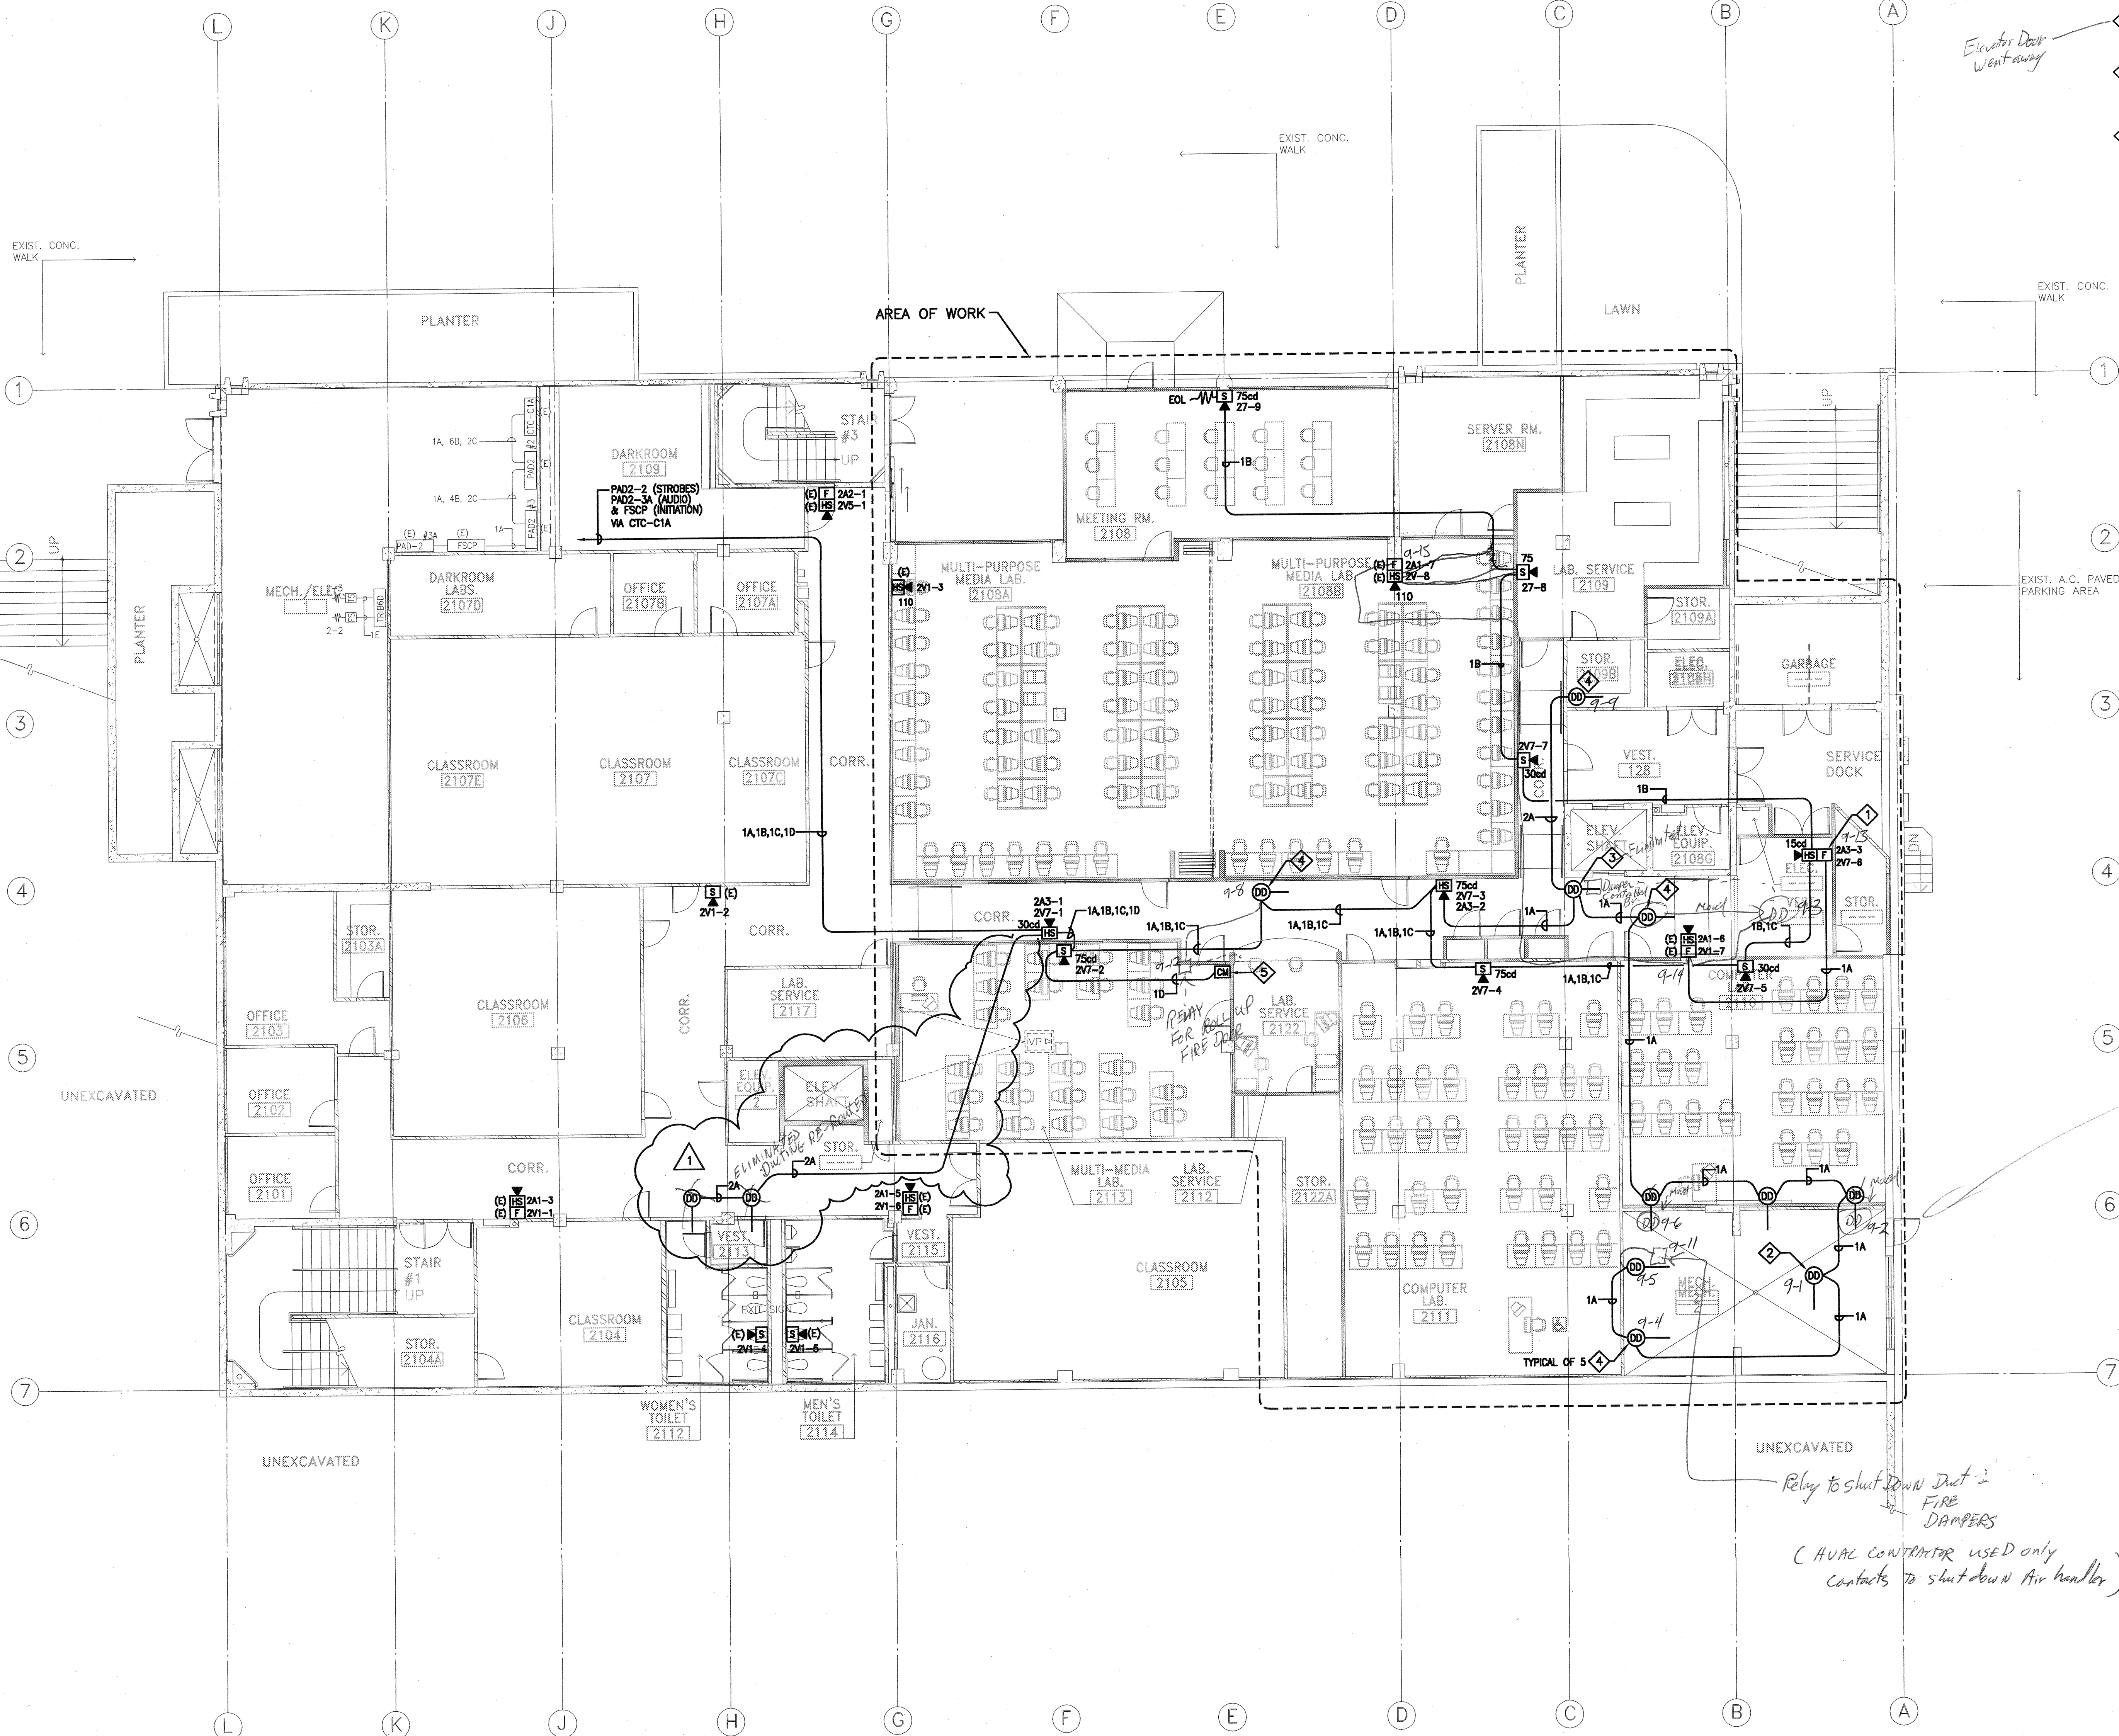

*9-1 is circuit #9 Device #1 etc*




*Relay to shut down duct in FIRE DAMPERS  
(HVAC CONTRACTOR USED ONLY  
CONTACTS TO SHUT-DOWN AIR HANDLER)*

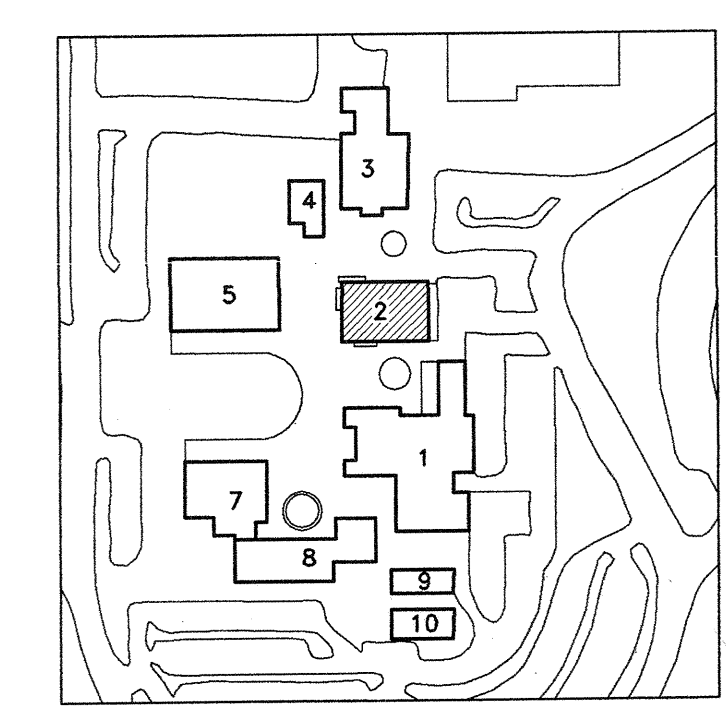

R E M O D E L

1st LEVEL FLOOR PLAN BUILDING # 2

SCALE: 1/8" = 1'-0"

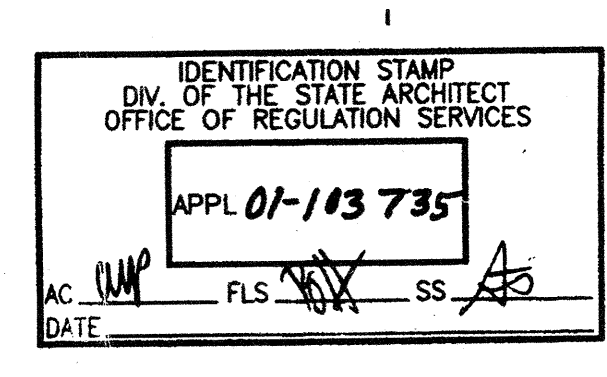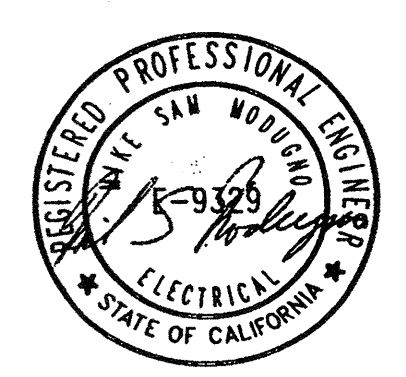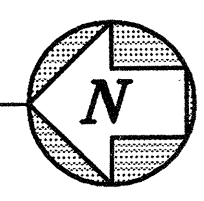

**CENTER FOR ADVANCED LEARNING TECHNOLOGY**  
**SKYLINE COLLEGE**  
 SAN MATEO COUNTY COMMUNITY COLLEGE DISTRICT  
 SAN BRUNO, CALIFORNIA 94066  
 3800 COLLEGE DRIVE

NO.	DESCRIPTION	DATE	BY
1	BID SET REVISIONS	10/25/01	
2	DSA SUBMITTAL	06/15/01	
REVISION			

DRAWN	LOG
CHECKED	DK
DATE	03/21/01
JOB NO.	98-03
SHEET TITLE	
1ST FLOOR PARTIAL FIRE ALARM PLAN	
SHEET	
EF-2.0	