



FILE LOCATION: P:\2163.002\Permit Pkg 3\CAD\Arch\SKYLINE PK43 CONFORM SET\161003054F10.dwg
 LAST SAVED ON: 9/10/04 at 4:14pm. PLOTTED ON: 9/13/04 at 2:10pm

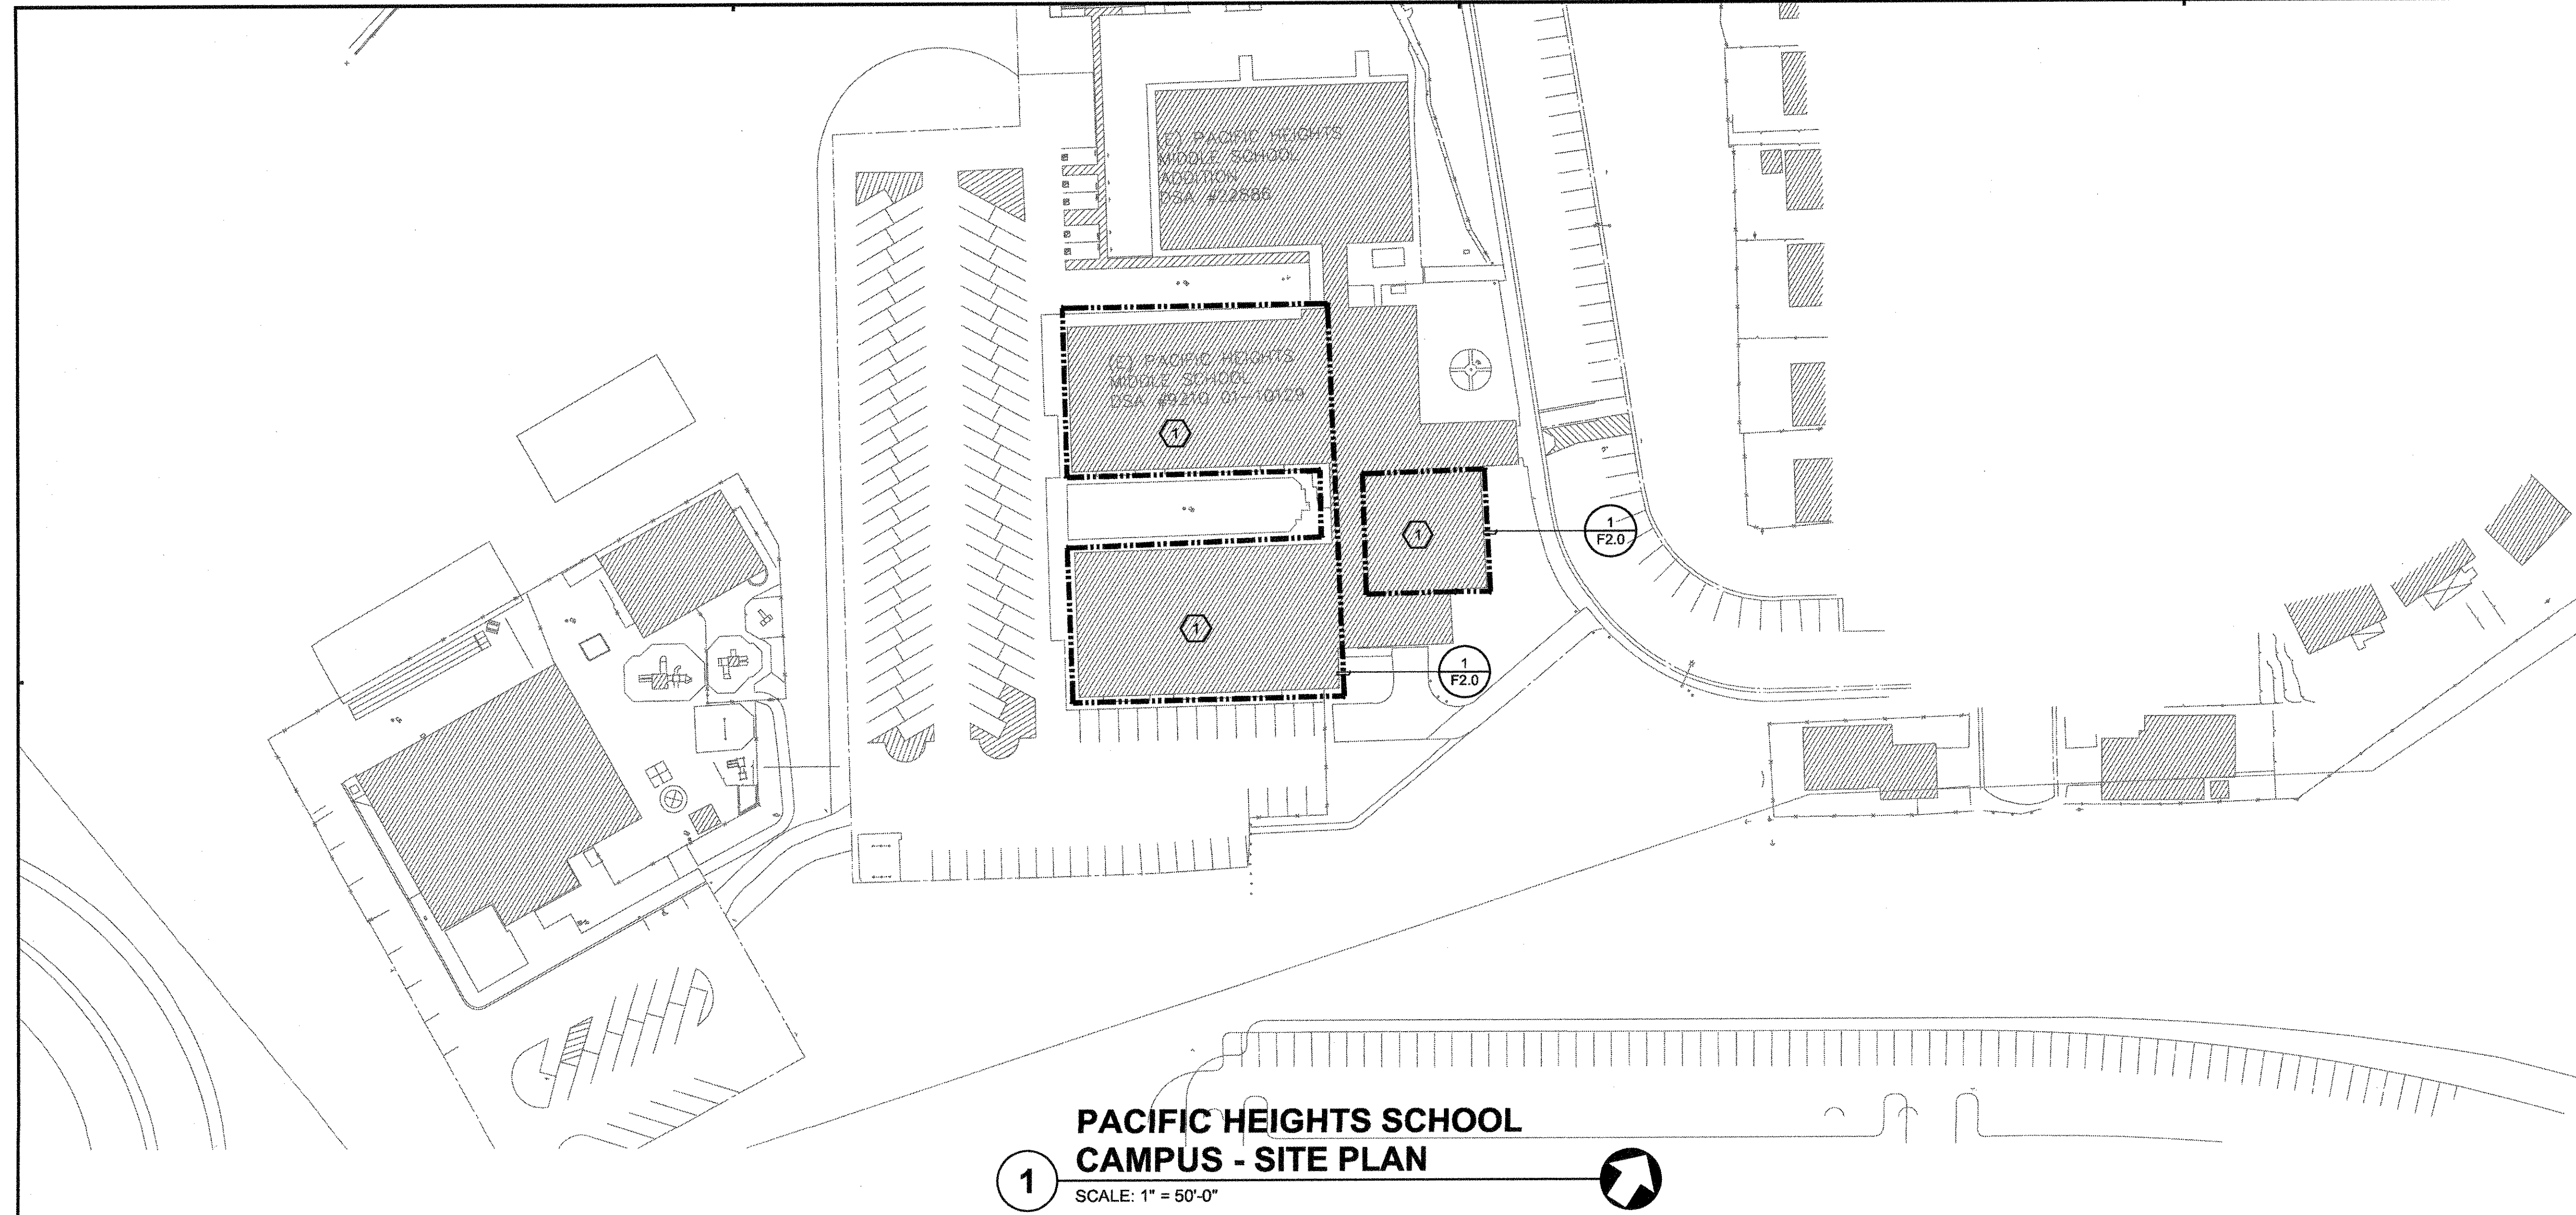

1 PACIFIC HEIGHTS SCHOOL CAMPUS - SITE PLAN
 SCALE: 1" = 50'-0"

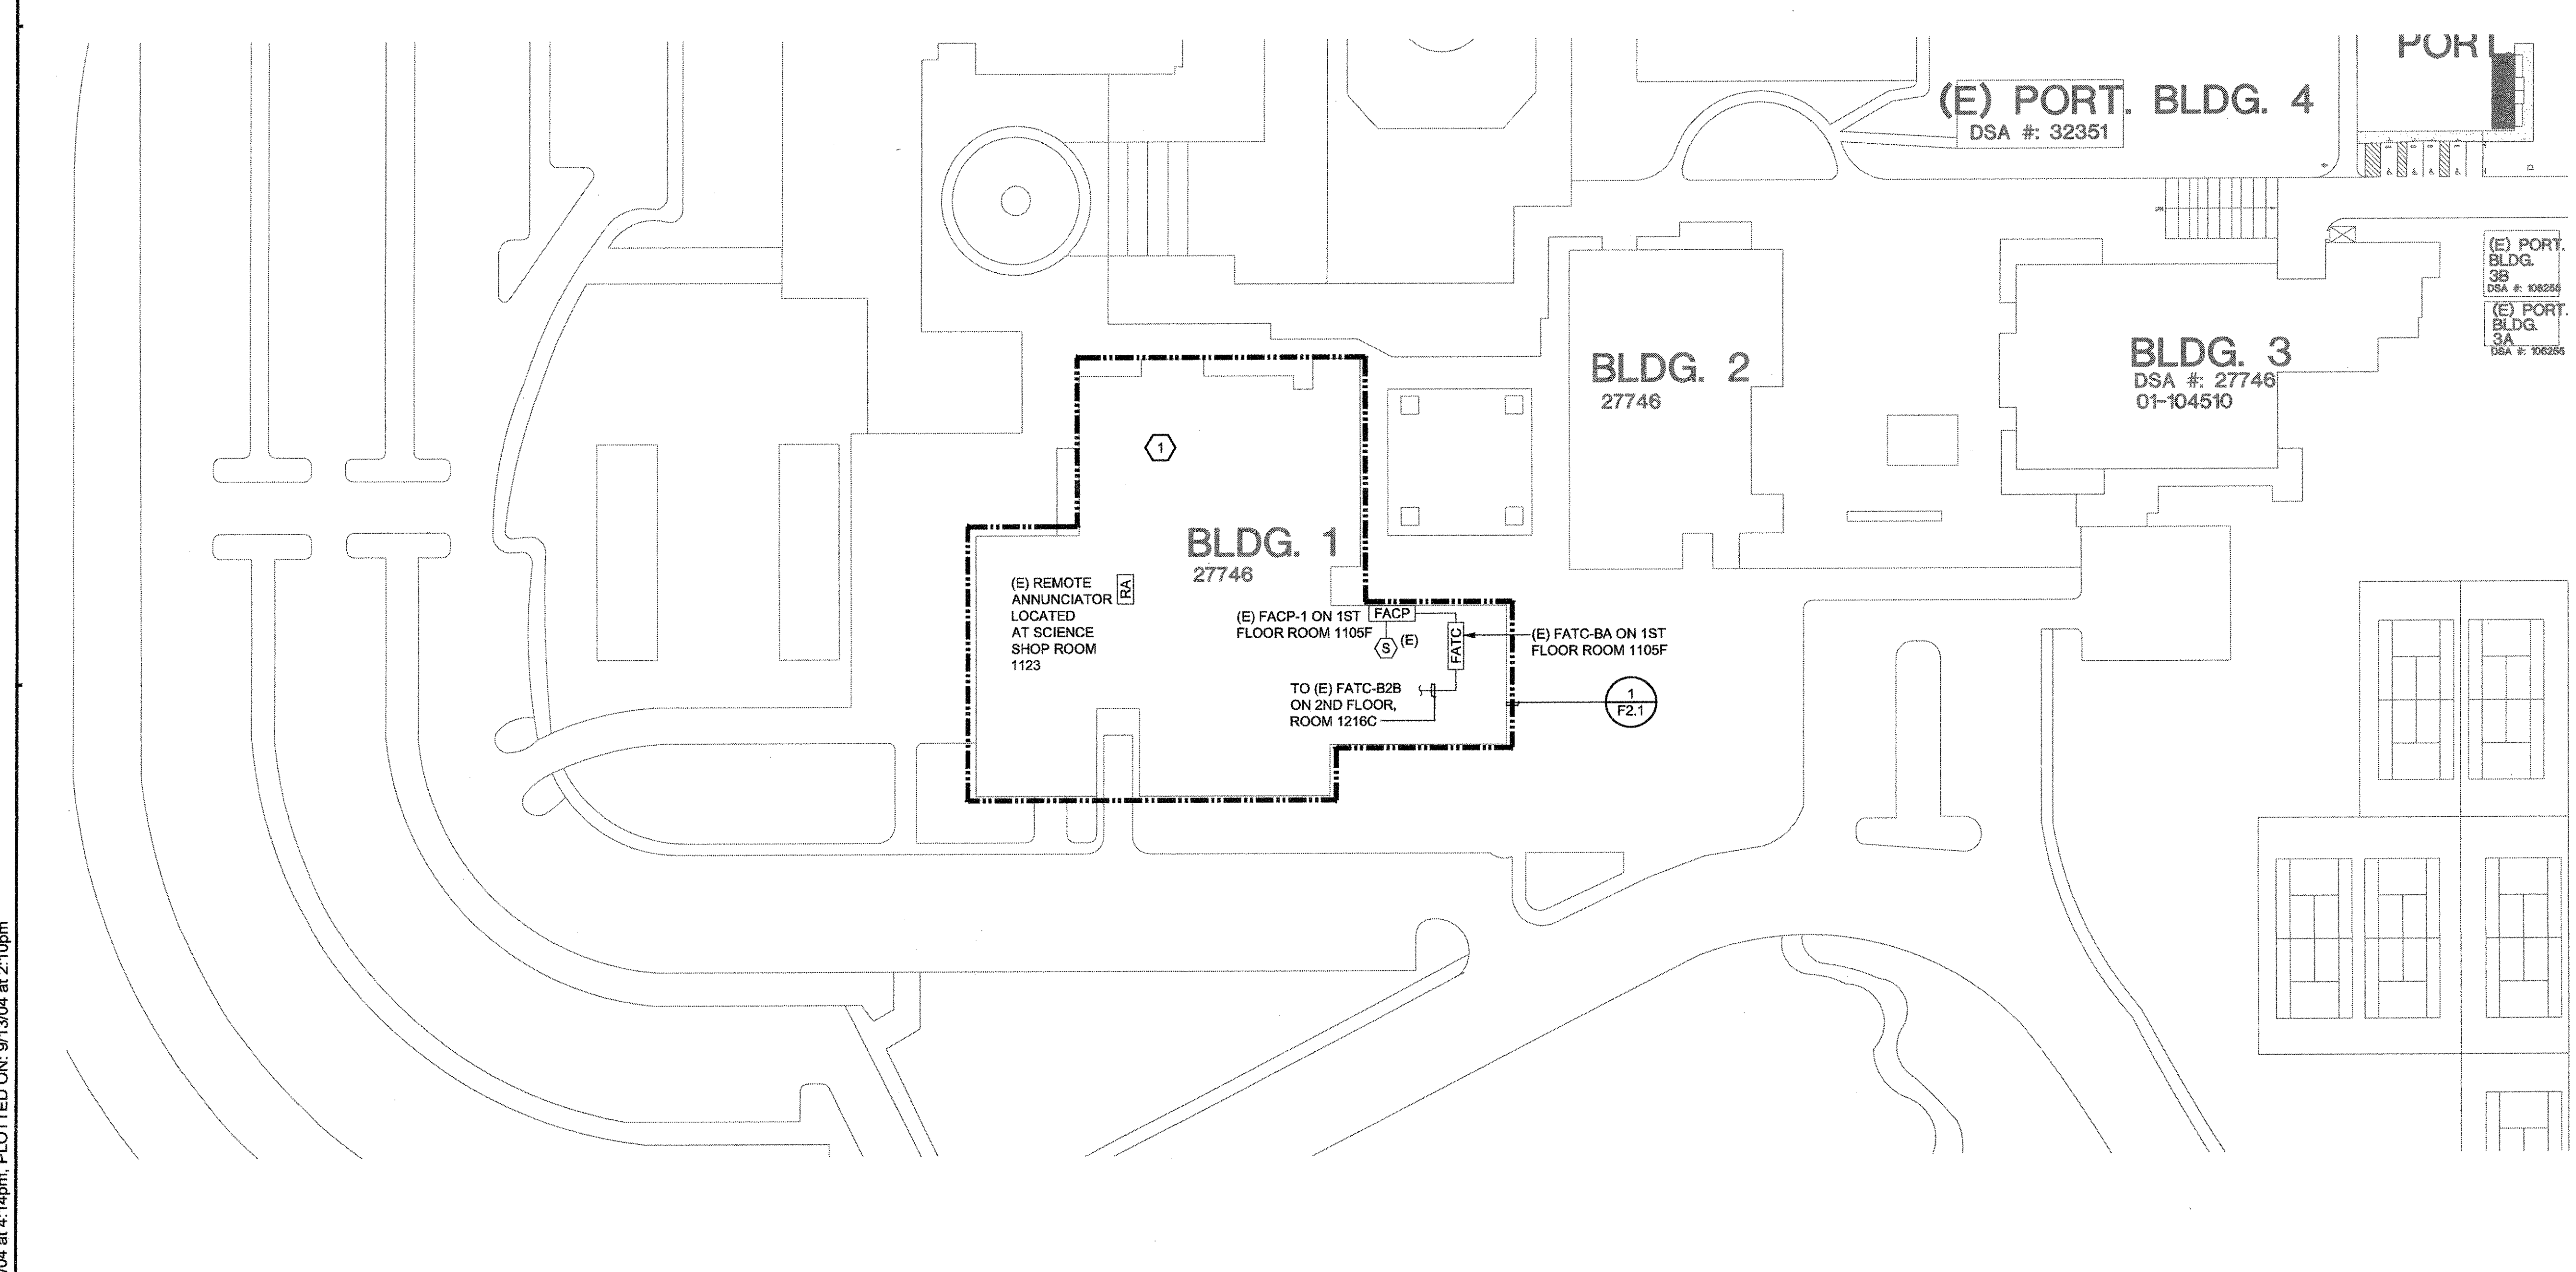

2 SKYLINE COLLEGE - SITE PLAN
 SCALE: 1" = 50'-0"

GENERAL NOTES

1. THERE SHALL BE NO UNDERGROUND SPLICES, UNLESS OTHERWISE NOTED.
2. LABEL IN GRADE FIRE ALARM PULL BOXES AS "FIRE ALARM."
3. CONNECT REMOTE NOTIFICATION POWER SUPPLIES TO FIRE ALARM CONTROL PANEL WITH TWO (2) #12 AWG, UNLESS OTHERWISE NOTED.
4. CONCEAL ALL CONDUIT, UNLESS OTHERWISE NOTED.
5. ALL EXTERIOR FIRE ALARM CONDUIT SHALL BE 2", UNLESS OTHERWISE NOTED.
6. AREA MAY CONTAIN UNDERGROUND RACEWAY. SITE LOCATE ALL EXISTING UNDERGROUND RACEWAY IN AREA BEFORE TRENCHING. MAINTAIN EXTREME CARE WHEN TRENCHING.
7. USE SITE CONDUITS UNDER SITE UTILITY CONSTRUCTION PROJECT.


SHEET NOTES

- 1 AREA OF WORK.

Sugimura & Associates Architects
 Architecture • Planning • Interiors
 Landscape Architecture
 2155 South Bascom Avenue, Suite 200
 Campbell, CA 95008
 408-879-0600 Fx 408-377-6066
 COPYRIGHT © 2001 Sugimura & Associates/Architects

IDCAJ
 INTEGRATED DESIGN ASSOCIATES INC.
 CONSULTING ELECTRICAL ENGINEERS
 10000 Wilshire Blvd., Suite 1000
 Beverly Hills, California 90210
 Tel: 310-206-0000 Fax: 310-206-0001

RECEIVED BY THE STATE ARCHITECT
 OFFICE OF REGULATION SERVICES
 APP. NO. _____ DATE _____
 AC _____ FLS _____ SS _____
 FILE NO. _____
 EXPIRES _____
 Division of the State Architect
 275 City St., Suite 1001
 Oakland, CA 94612

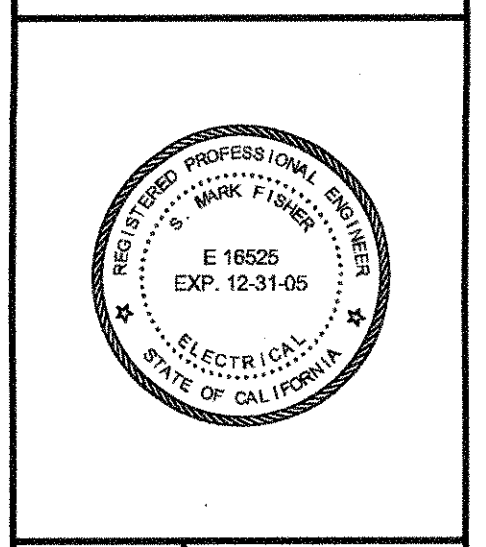

DSA SUBMITTAL - 02.13.04

PACIFIC HEIGHTS AND SKYLINE COLLEGE SITE PLANS
 SKYLINE COLLEGE SWING SPACE
 PERMIT PACKAGE #3
 SKYLINE COLLEGE
 3300 COLLEGE DRIVE
 SAN BRUNO, CA. 94066

REVISIONS		
NO.	ITEM	DATE
1	CONSTRUCTION ISSUE	6/10/04

CLIENT APPROVAL:
 DRAWN BY: RCS
 CHECKED BY: SMF
 JOB NO: 2163.002 DATE: 5 FEB. 2004

F10
 OF SHEETS