

Engineer of Record  
*Jeff Suter*

IDENTIFICATION STAMP  
DIVISION OF THE STATE ARCHITECT

APPLICATION NUMBER: 111618  
AC: *KS* FOR *RECALL*  
DATE: 2/9/11

CALIFORNIA STATE FIRE MARSHAL  
APPROVED

APPROVAL OF THIS PLAN DOES NOT AUTHORIZE OR APPROVE ANY  
CARRIER OR DIVIATION FROM APPLICABLE REGULATIONS. FINAL  
APPROVAL IS SUBJECT TO THE INSPECTOR. ONE SET OF APPROVED  
PLANS SHALL BE AVAILABLE ON THE PROJECT SITE AT ALL TIMES.  
REVIEWED BY: \_\_\_\_\_ DATE: \_\_\_\_\_

**CAÑADA  
COLLEGE**

Electrical  
Infrastructure  
Replacement  
Project

4200 Farm Hill Blvd  
Redwood City, CA 94061


BID SET

SHEET TITLE  
**FIRE ALARM RISER  
BUILDING 30**

REVISIONS		
NO.	DATE	DESCRIPTION

DATE January 14, 2011  
DRAWN RB  
CHECKED KR  
SCALE N/A  
JOB NO. 2921.01

SHEET NUMBER  
**FA-05**

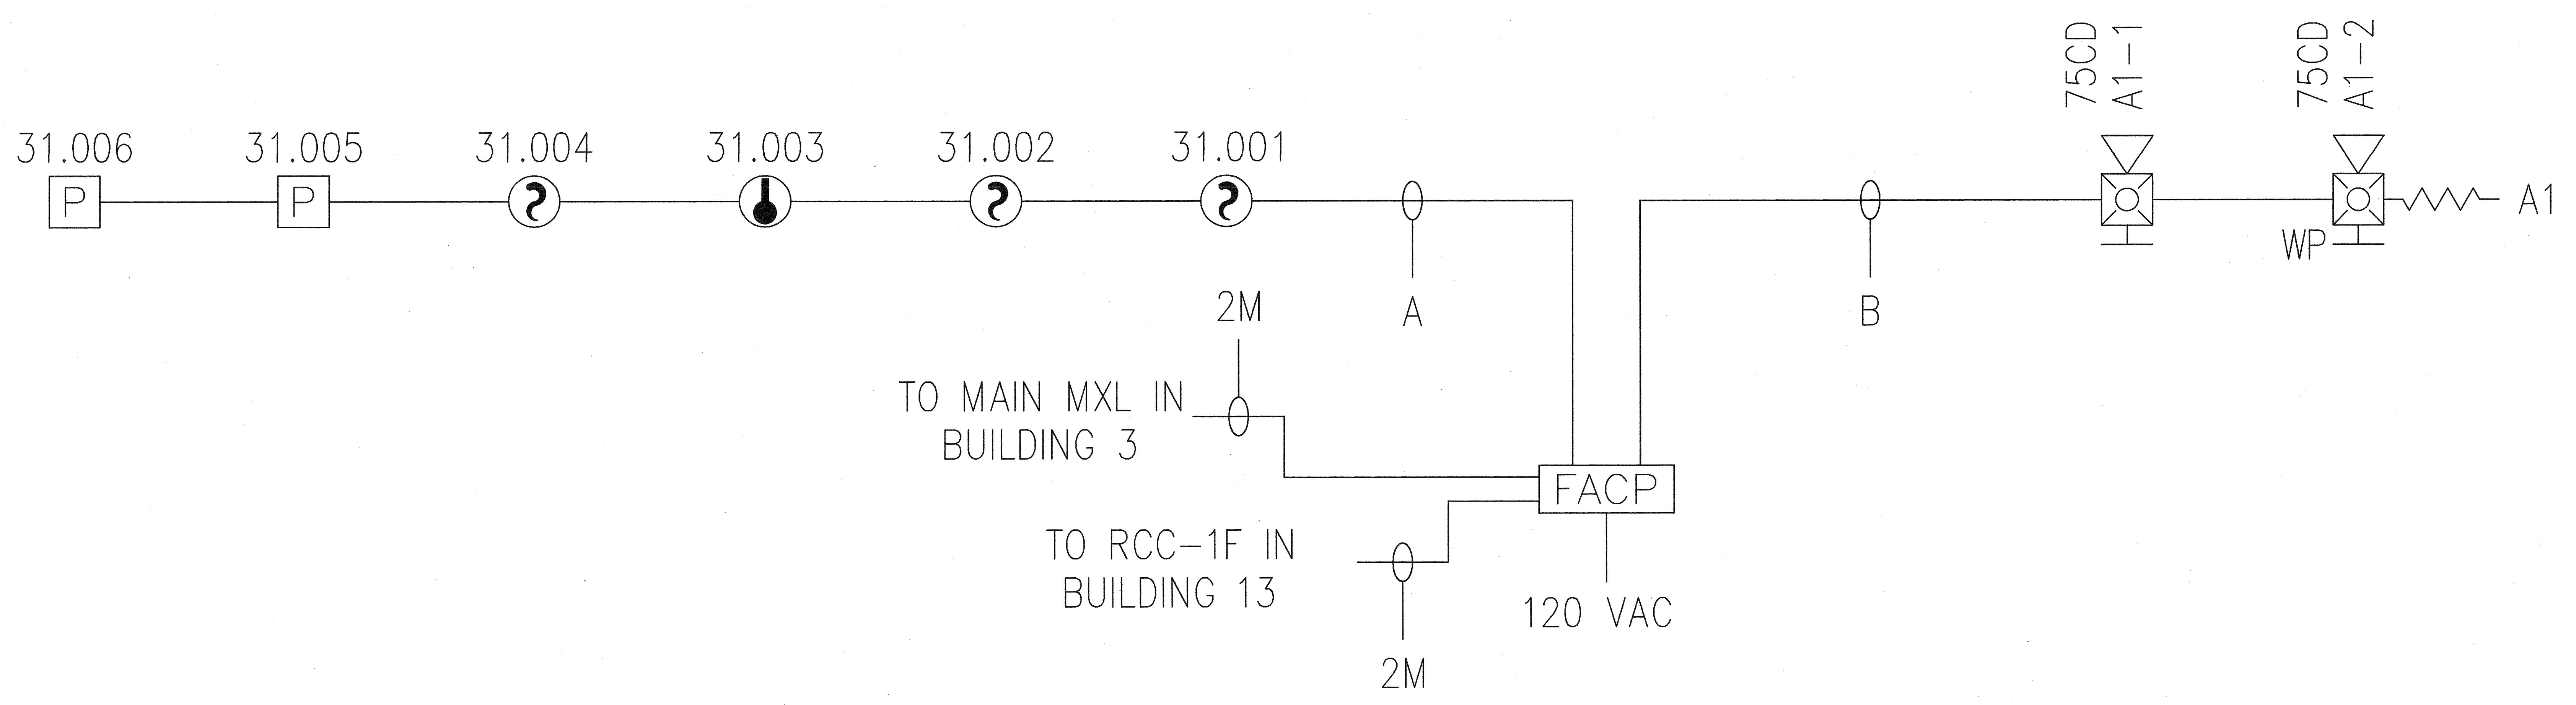

TO MAIN MXL IN  
BUILDING 3

TO RCC-1F IN  
BUILDING 13

120 VAC

2M

**BUILDING 30 RISER**

SCALE: NOT TO SCALE