

THIS DRAWING AND DESIGN HEREIN SHALL NOT BE REPRODUCED, COPIED, OR DISCLOSED TO OTHERS FOR PROCUREMENT OR OTHER PURPOSES (EXCEPT AS OTHERWISE AUTHORIZED BY CONTRACT) WITHOUT WRITTEN PERMISSION OF SIMONS INDUSTRY. ALL OTHER REPRODUCTIONS SHALL BEAR THIS NOTICE.

REVISIONS

No.	Revision	By	Date	Appr.

GENERAL SHEET NOTES

- A. DEMOLISH EXISTING FIRE ALARM DEVICES AS REQUIRED TO ACCOMMODATE NEW CONSTRUCTION. DEMOLITION WORK SHALL BE COORDINATE AND SEQUENCED WITH THE PROVISIONS OF ALL DIVISIONS OF CONSTRUCTION DOCUMENTS.
- B. REMOVE ALL EXISTING MATERIALS CONFLICTING WITH REMODEL WORK INDICATED IN CONSTRUCTION DOCUMENTS AND SUBJECT TO THE CONDITIONS INDICATED IN SUCH.
- C. REMOVE ALL ELECTRICAL MATERIALS MOUNTED IN OR ON WALLS AND CEILING TO BE REMOVED AS INDICATED IN THE ARCHITECTURAL CONSTRUCTION DOCUMENTS.
- D. VERIFY EXISTING CONDITIONS PRIOR TO PROCEEDING WITH THE WORK, AND PROVIDE ADDITIONAL SPLICE BOXES, ETC., AS REQUIRED FOR A COMPLETE AND PROPERLY OPERATING SYSTEM. EXISTING CONDUIT THAT IS NOT REMOVED DURING DEMOLITION MAY BE REUSED IN PLACE IF IT IS SIZED IN ACCORDANCE WITH THE LATEST EDITION OF THE N.E.C. AND THOROUGHLY CLEANED AND SWABBED PRIOR TO PULLING NEW WIRES.
- E. WHERE DRAWINGS INDICATE EXISTING FIRE ALARM EQUIPMENT OR DEVICES TO BE RELOCATED OR REUSED, REFURBISH THEM. CLEAN SUCH ITEMS AND NOTIFY ARCHITECT OF ANY DEFECTS IN SUCH INSTALLATIONS. REPAIR ANY DAMAGE CAUSED BY DEMOLITION OR CONSTRUCTION PERFORMED UNDER THIS CONTRACT.

SHEET KEYNOTES

- ① FIRE ALARM RISER TO MECHANICAL ROOM 5-204A
- ② EXISTING DEVICE, ADDRESSE TO BE FIELD VERIFIED.
- ③ BUILDING 6 FSDs TO BE SHUT DOWN BY RELAY MODULE 29-23. 120 VAC WIRE RUN TO BE DETERMINED BY ELECTRICAL CONTRACTOR.
- ④ BUILDING 5 1ST FLOOR FSDs TO BE SHUT DOWN BY RELAY MODULE 29-15. 120 VAC WIRE RUN TO BE DETERMINED BY ELECTRICAL CONTRACTOR.

DESIGN ENGINEER:
 PROJECT: 2007-0731
 CONTACT: **Interface** ENGINEERING
 717 Market Street
 Suite 500
 San Francisco, CA 94103
 TEL: 415.489.7240
 FAX: 415.489.7289
 www.interfaceengineering.com

ISA STAMP:
 FILE NO. 41-C1
 IDENTIFICATION STAMP
 DIV. OF THE STATE ARCHITECT
 01-110074
 AC FLS ES
 DATE


CONTRACTOR'S NAME & ADDRESS:
InterMountain
 ELECTRIC COMPANY
 947 Washington Street
 San Carlos CA 94070
 Tel 650.591.7118 Fax 650.591.7123
 contact@im-electric.com

PRODUCT MANUFACTURER:
SIEMENS
 Industry
 SAN FRANCISCO BRANCH
 25821 Industrial Boulevard, Suite 300
 Hayward, California 94545-2901
 Tel (510) 783-6000 Fax (510) 293-2100
 California State C10 License No. 758796
 U.L. Certificate ID No. 324787-001

JOB NAME & LOCATION (STREET ADDRESS):
FIRE ALARM
 FOR
 SAN MATEO COUNTY COMMUNITY COLLEGE DISTRICT
CAÑADA COLLEGE
 BUILDINGS 5 AND 6
 MODERNIZATION
 4200 FARM HILL BOULEVARD
 REDWOOD CITY, CA 94061

SHEET CONTENTS:
FIRE ALARM PLAN
 Bldg. 5 & 6 1ST FLOOR
 INSTALLATION TYPE:
 NEW INSTALLATION
 DESIGN/BUILD
 PER CONTRACT DOCUMENT
 EXISTING BASE JOB #
 OTHERS

SYSTEM SALES REP: Kelly Rogers
 PROJECT MANAGER: Jesse Mangosing
 DRAWN BY: Ronald Babiera
 CVD FILENAME: 44OP-070529.DWG
 SCALE: N/A
 DATE DRAWN: April 07, 2010 PLOT DATE: May 11, 2010
 SHEET: FA-06 JOB NUMBER: 44OP-070529 NET NUMBER: 5249672

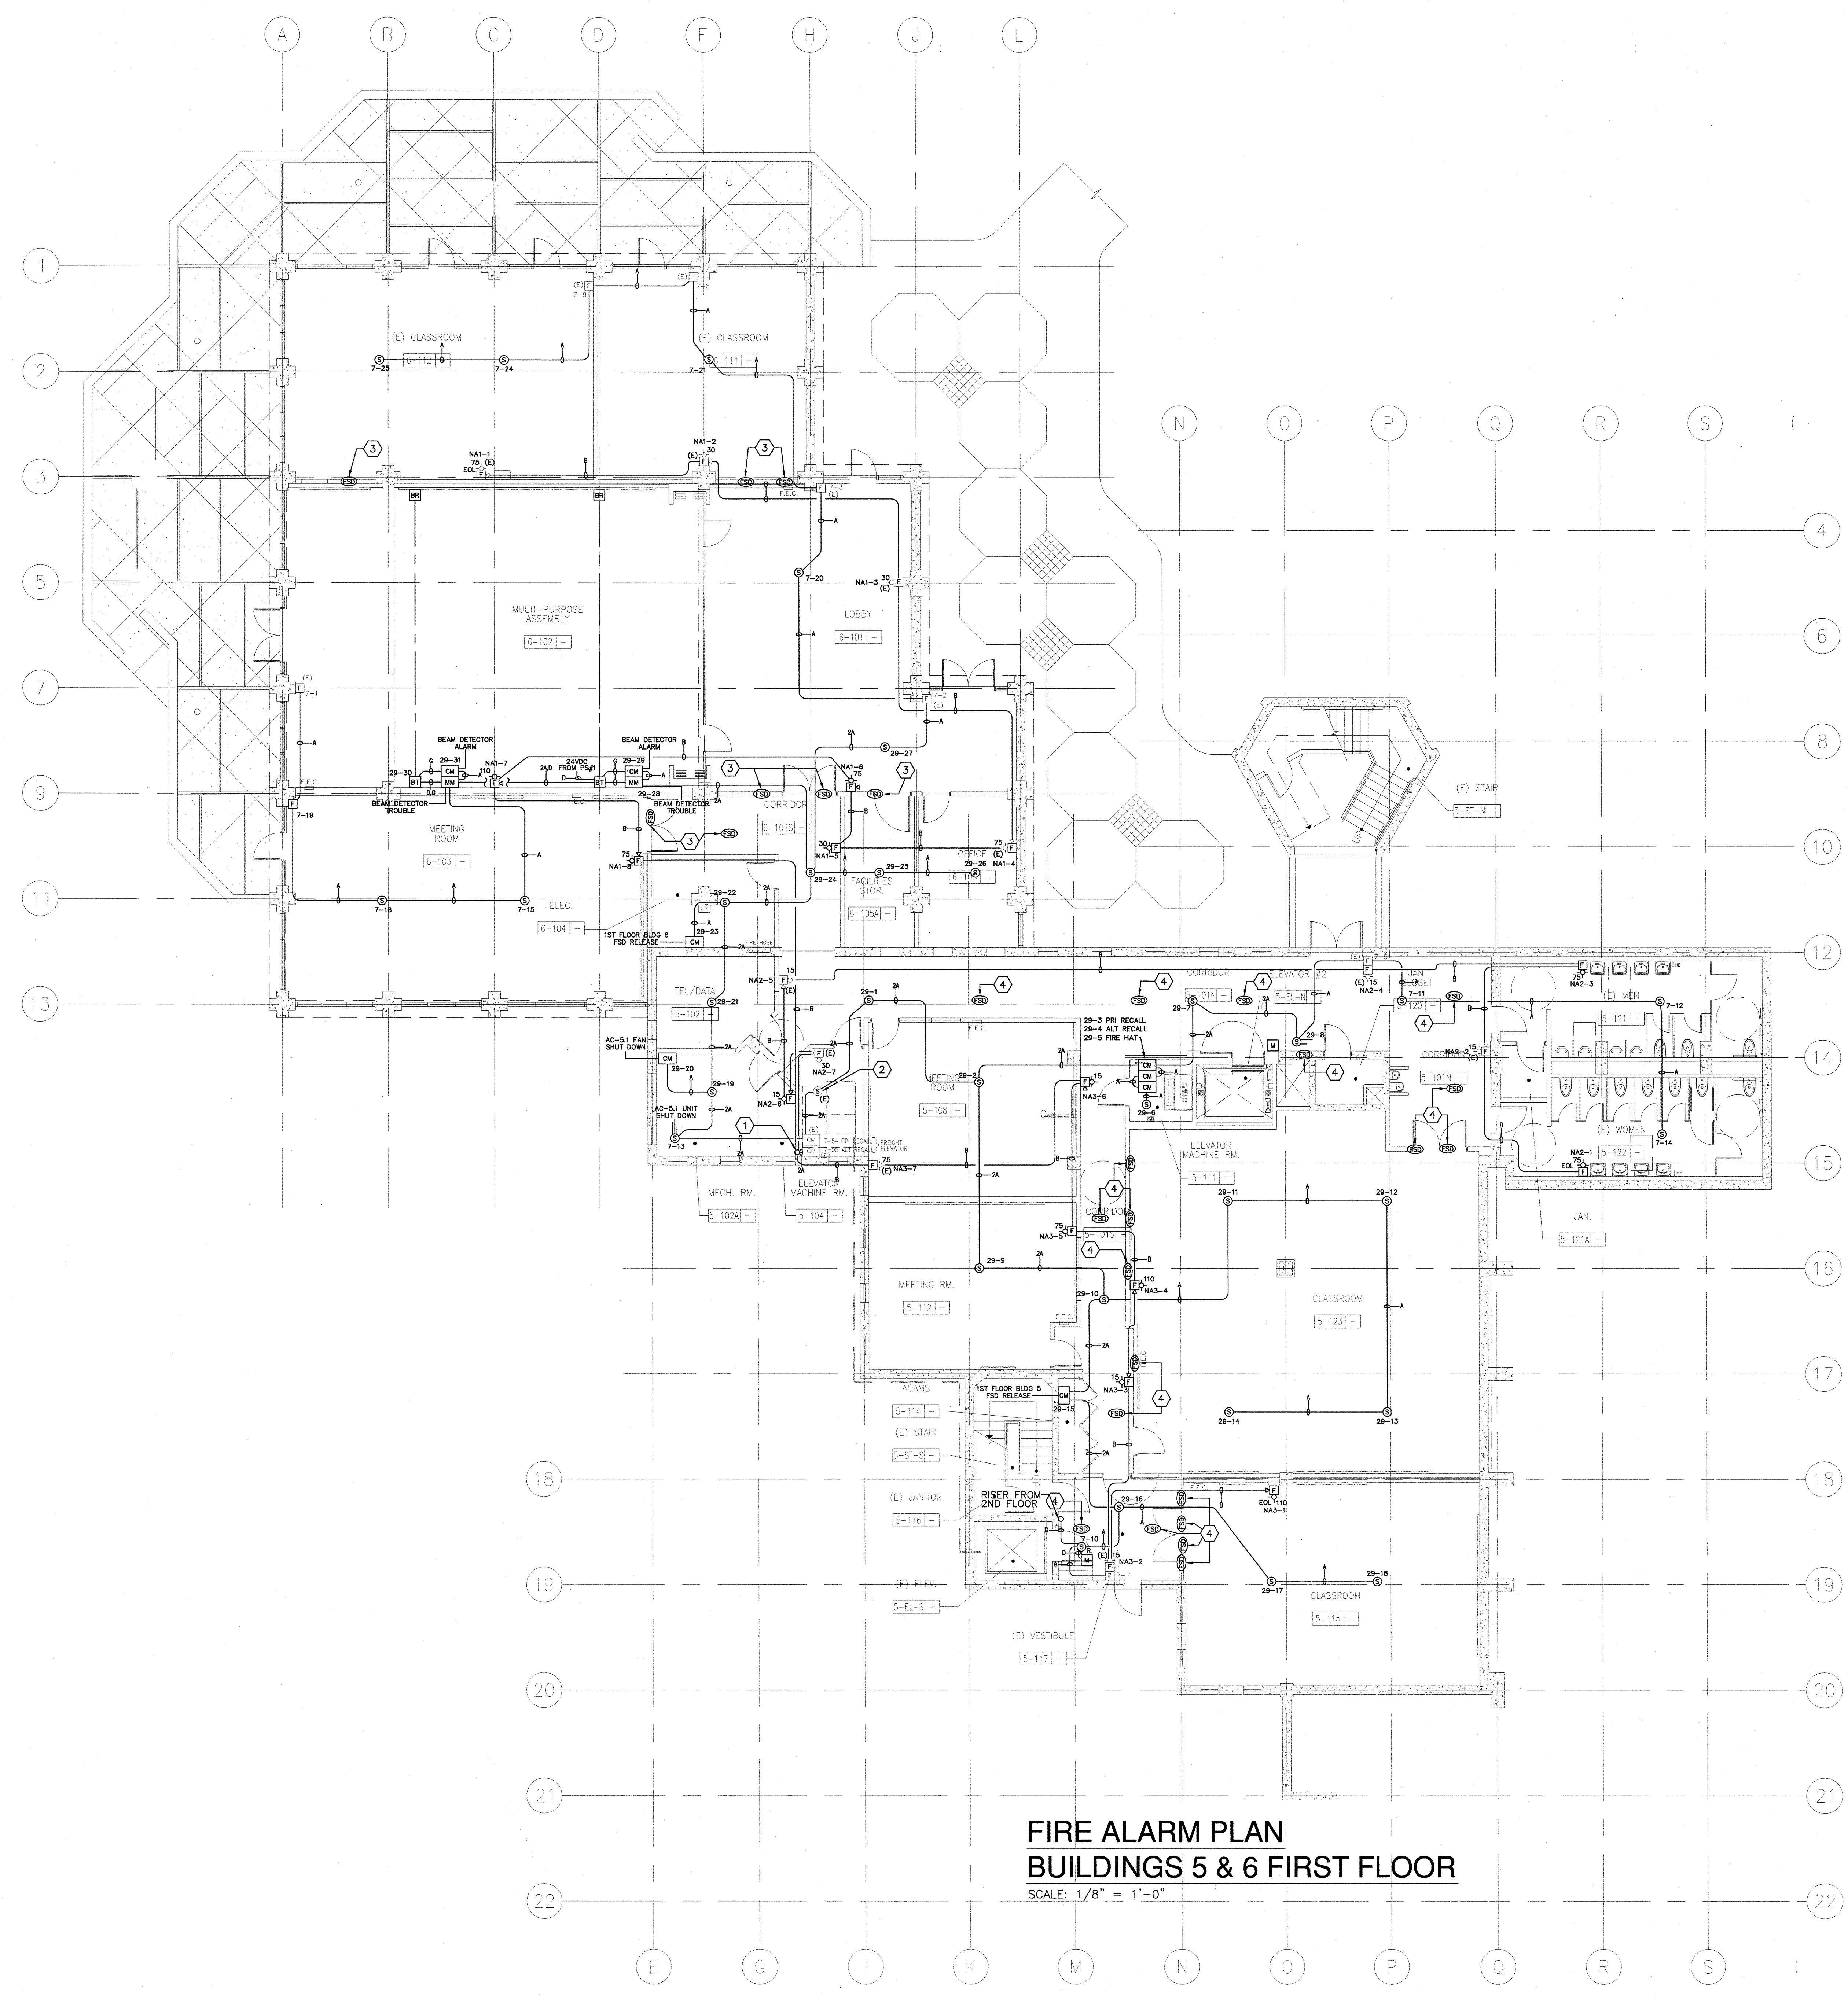

FIRE ALARM PLAN
BUILDINGS 5 & 6 FIRST FLOOR
 SCALE: 1/8" = 1'-0"

DRAWING IS SMALLER THAN 30" X 42" IF IS A REDUCED COPY