



Engineer of Record  
*Jeffrey M. Duggan*

IDENTIFICATION STAMP  
DIVISION OF THE STATE ARCHITECT

APPLICATION NUMBER: 01-111618  
AC: RB  
DATE: 2/9/11

CALIFORNIA STATE FIRE MARSHAL  
APPROVED

APPROVAL OF THIS PLAN DOES NOT ALLOW OR APPROVE ANY  
OMISSION OR DEVIATION FROM APPLICABLE REGULATIONS. FINAL  
APPROVAL IS SUBJECT TO FIELD INSPECTION. ONE SET OF APPROVED  
PLANS SHALL BE AVAILABLE ON THE PROJECT SITE AT ALL TIMES.

REVIEWED BY: \_\_\_\_\_ DATE: \_\_\_\_\_

**CAÑADA  
COLLEGE**

Electrical  
Infrastructure  
Replacement  
Project

4200 Farm Hill Blvd  
Redwood City, CA 94061


BID SET

SHEET TITLE  
FIRE ALARM PLAN  
BUILDING 30


REVISIONS		
NO.	DATE	DESCRIPTION

DATE: January 14, 2011  
DRAWN: RB  
CHECKED: KR  
SCALE: 1/8"=1'-0"  
JOB NO.: 2921.01


SHEET NUMBER  
**FA-06**

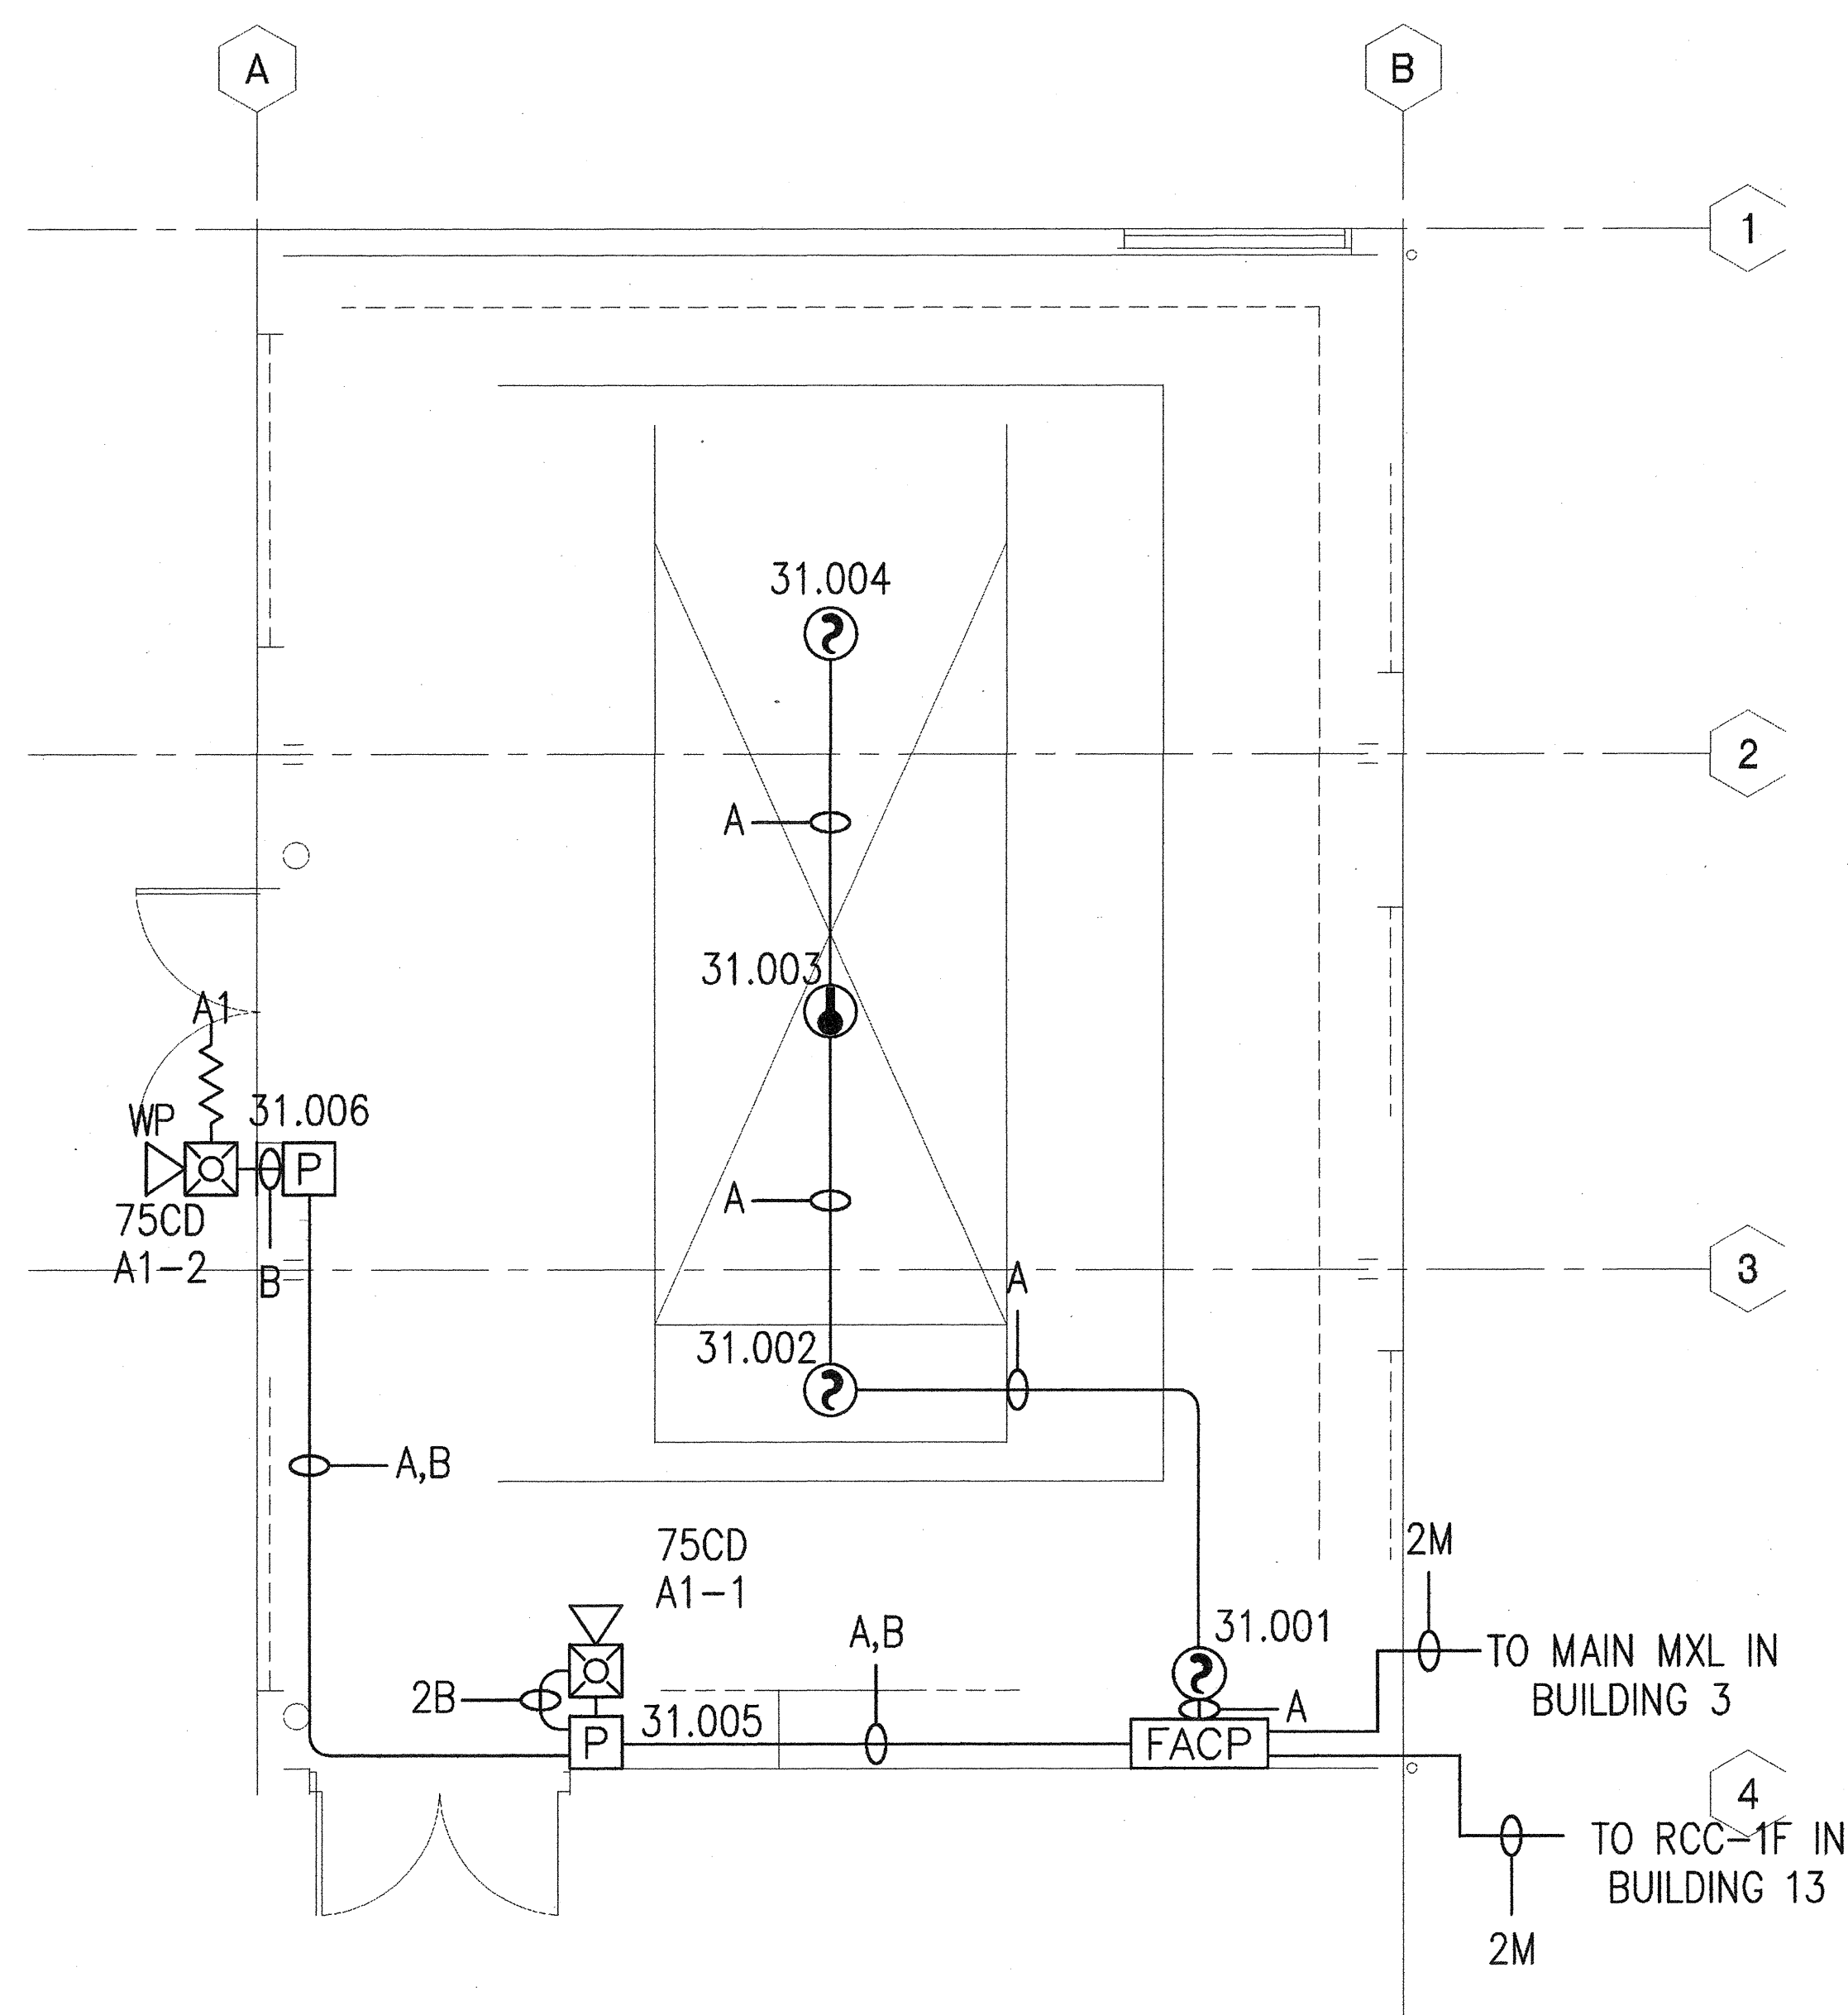

**FIRE ALARM PLAN**

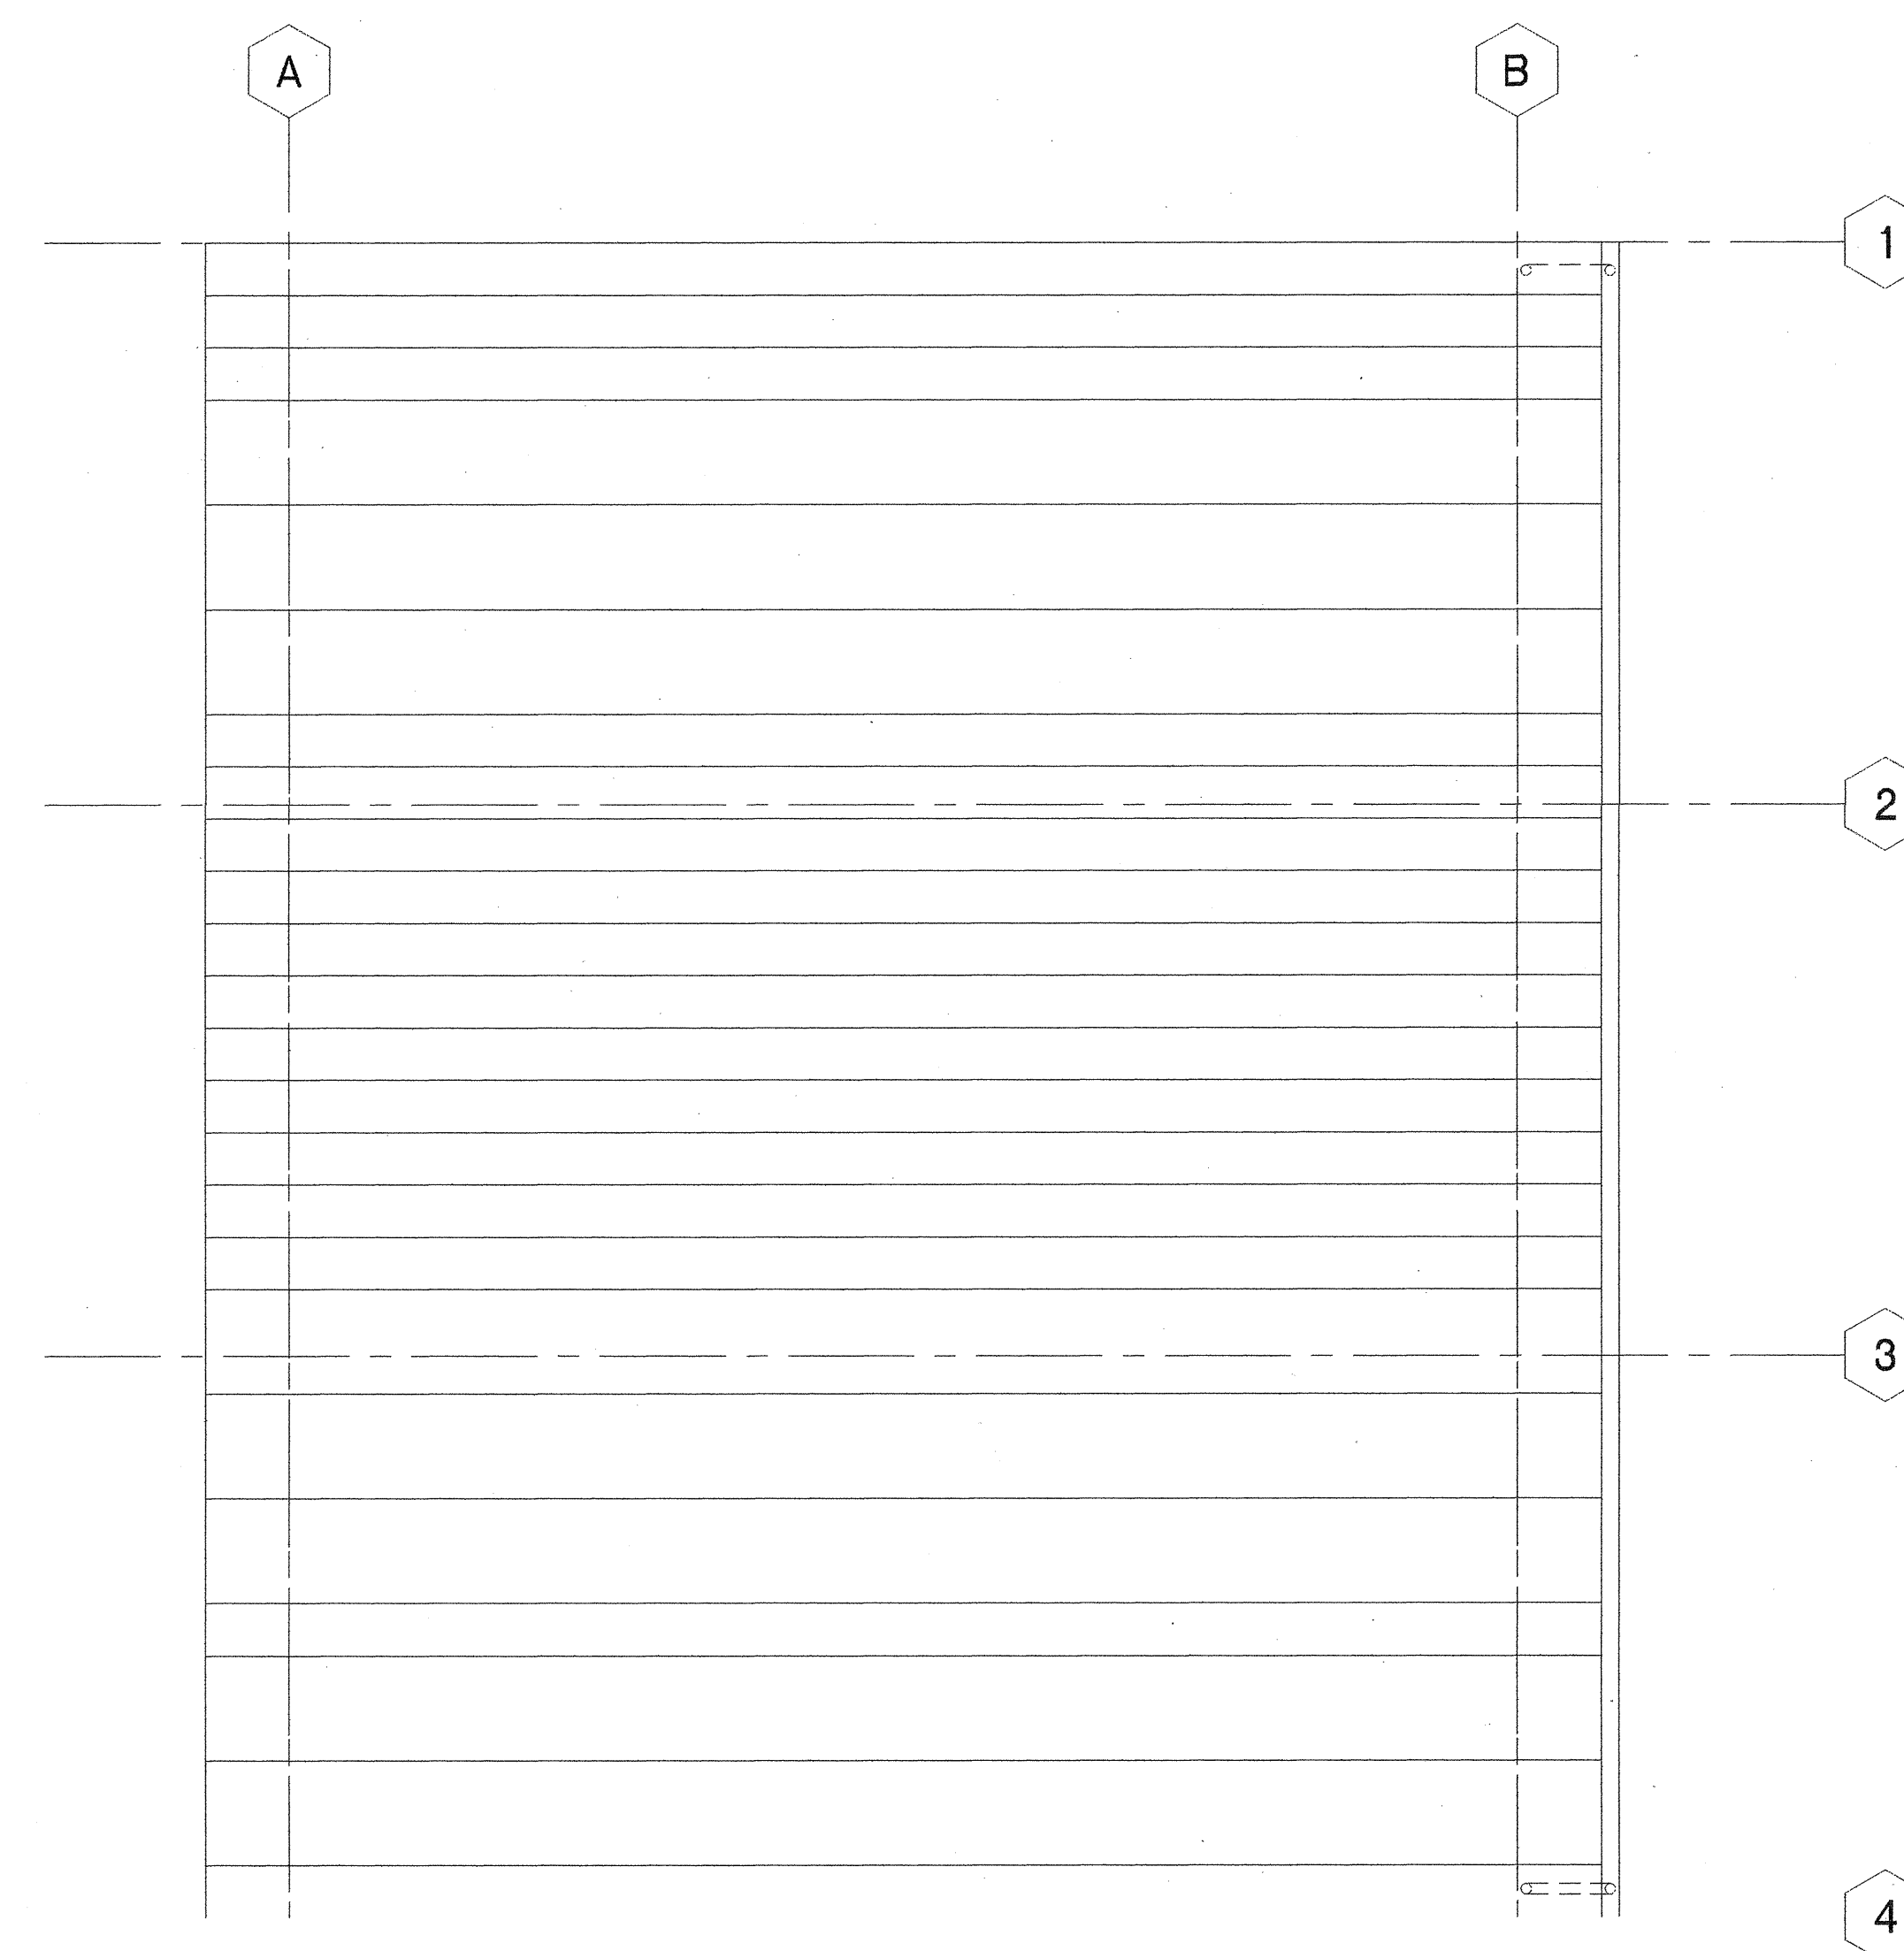

**ROOF PLAN**

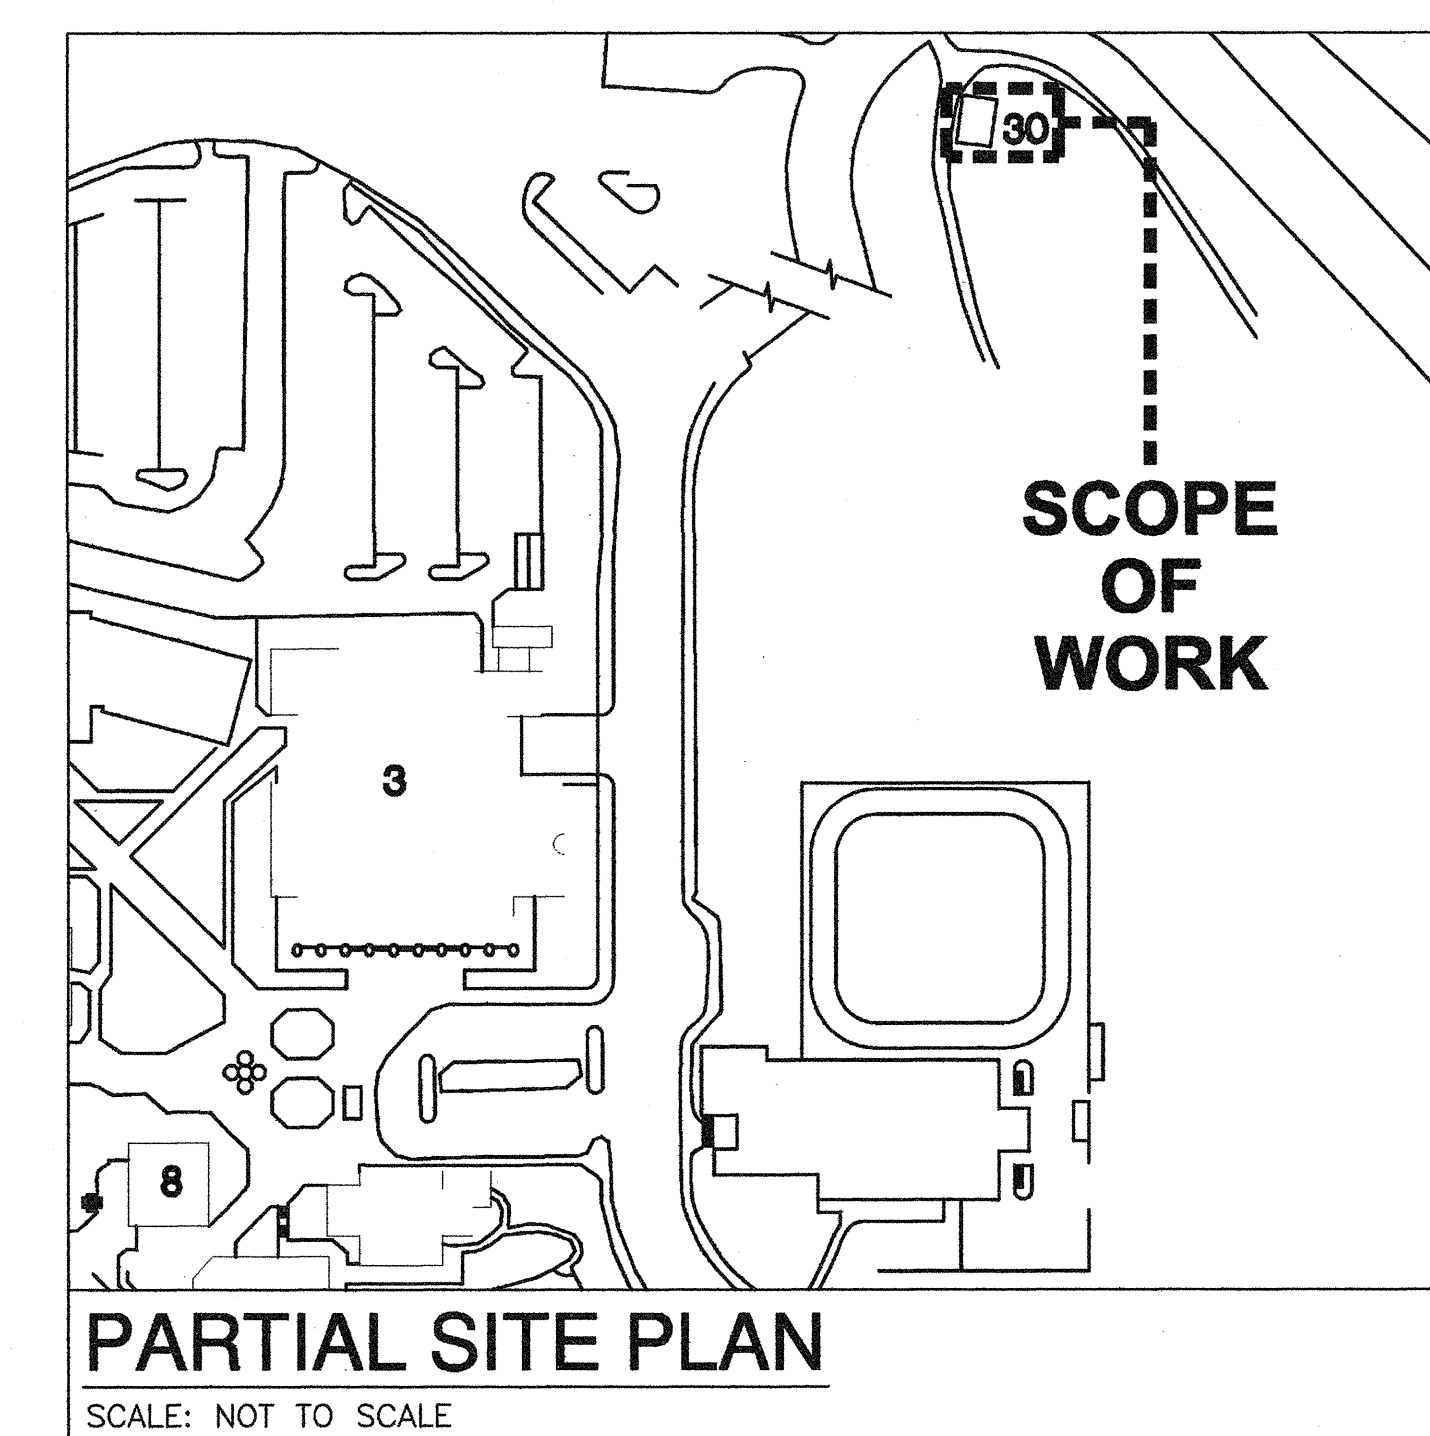

**PARTIAL SITE PLAN**  
SCALE: NOT TO SCALE

**FIRE ALARM PLAN BUILDING 30**

SCALE: 1/8" = 1'-0"