



**FIRE ALARM PLAN**

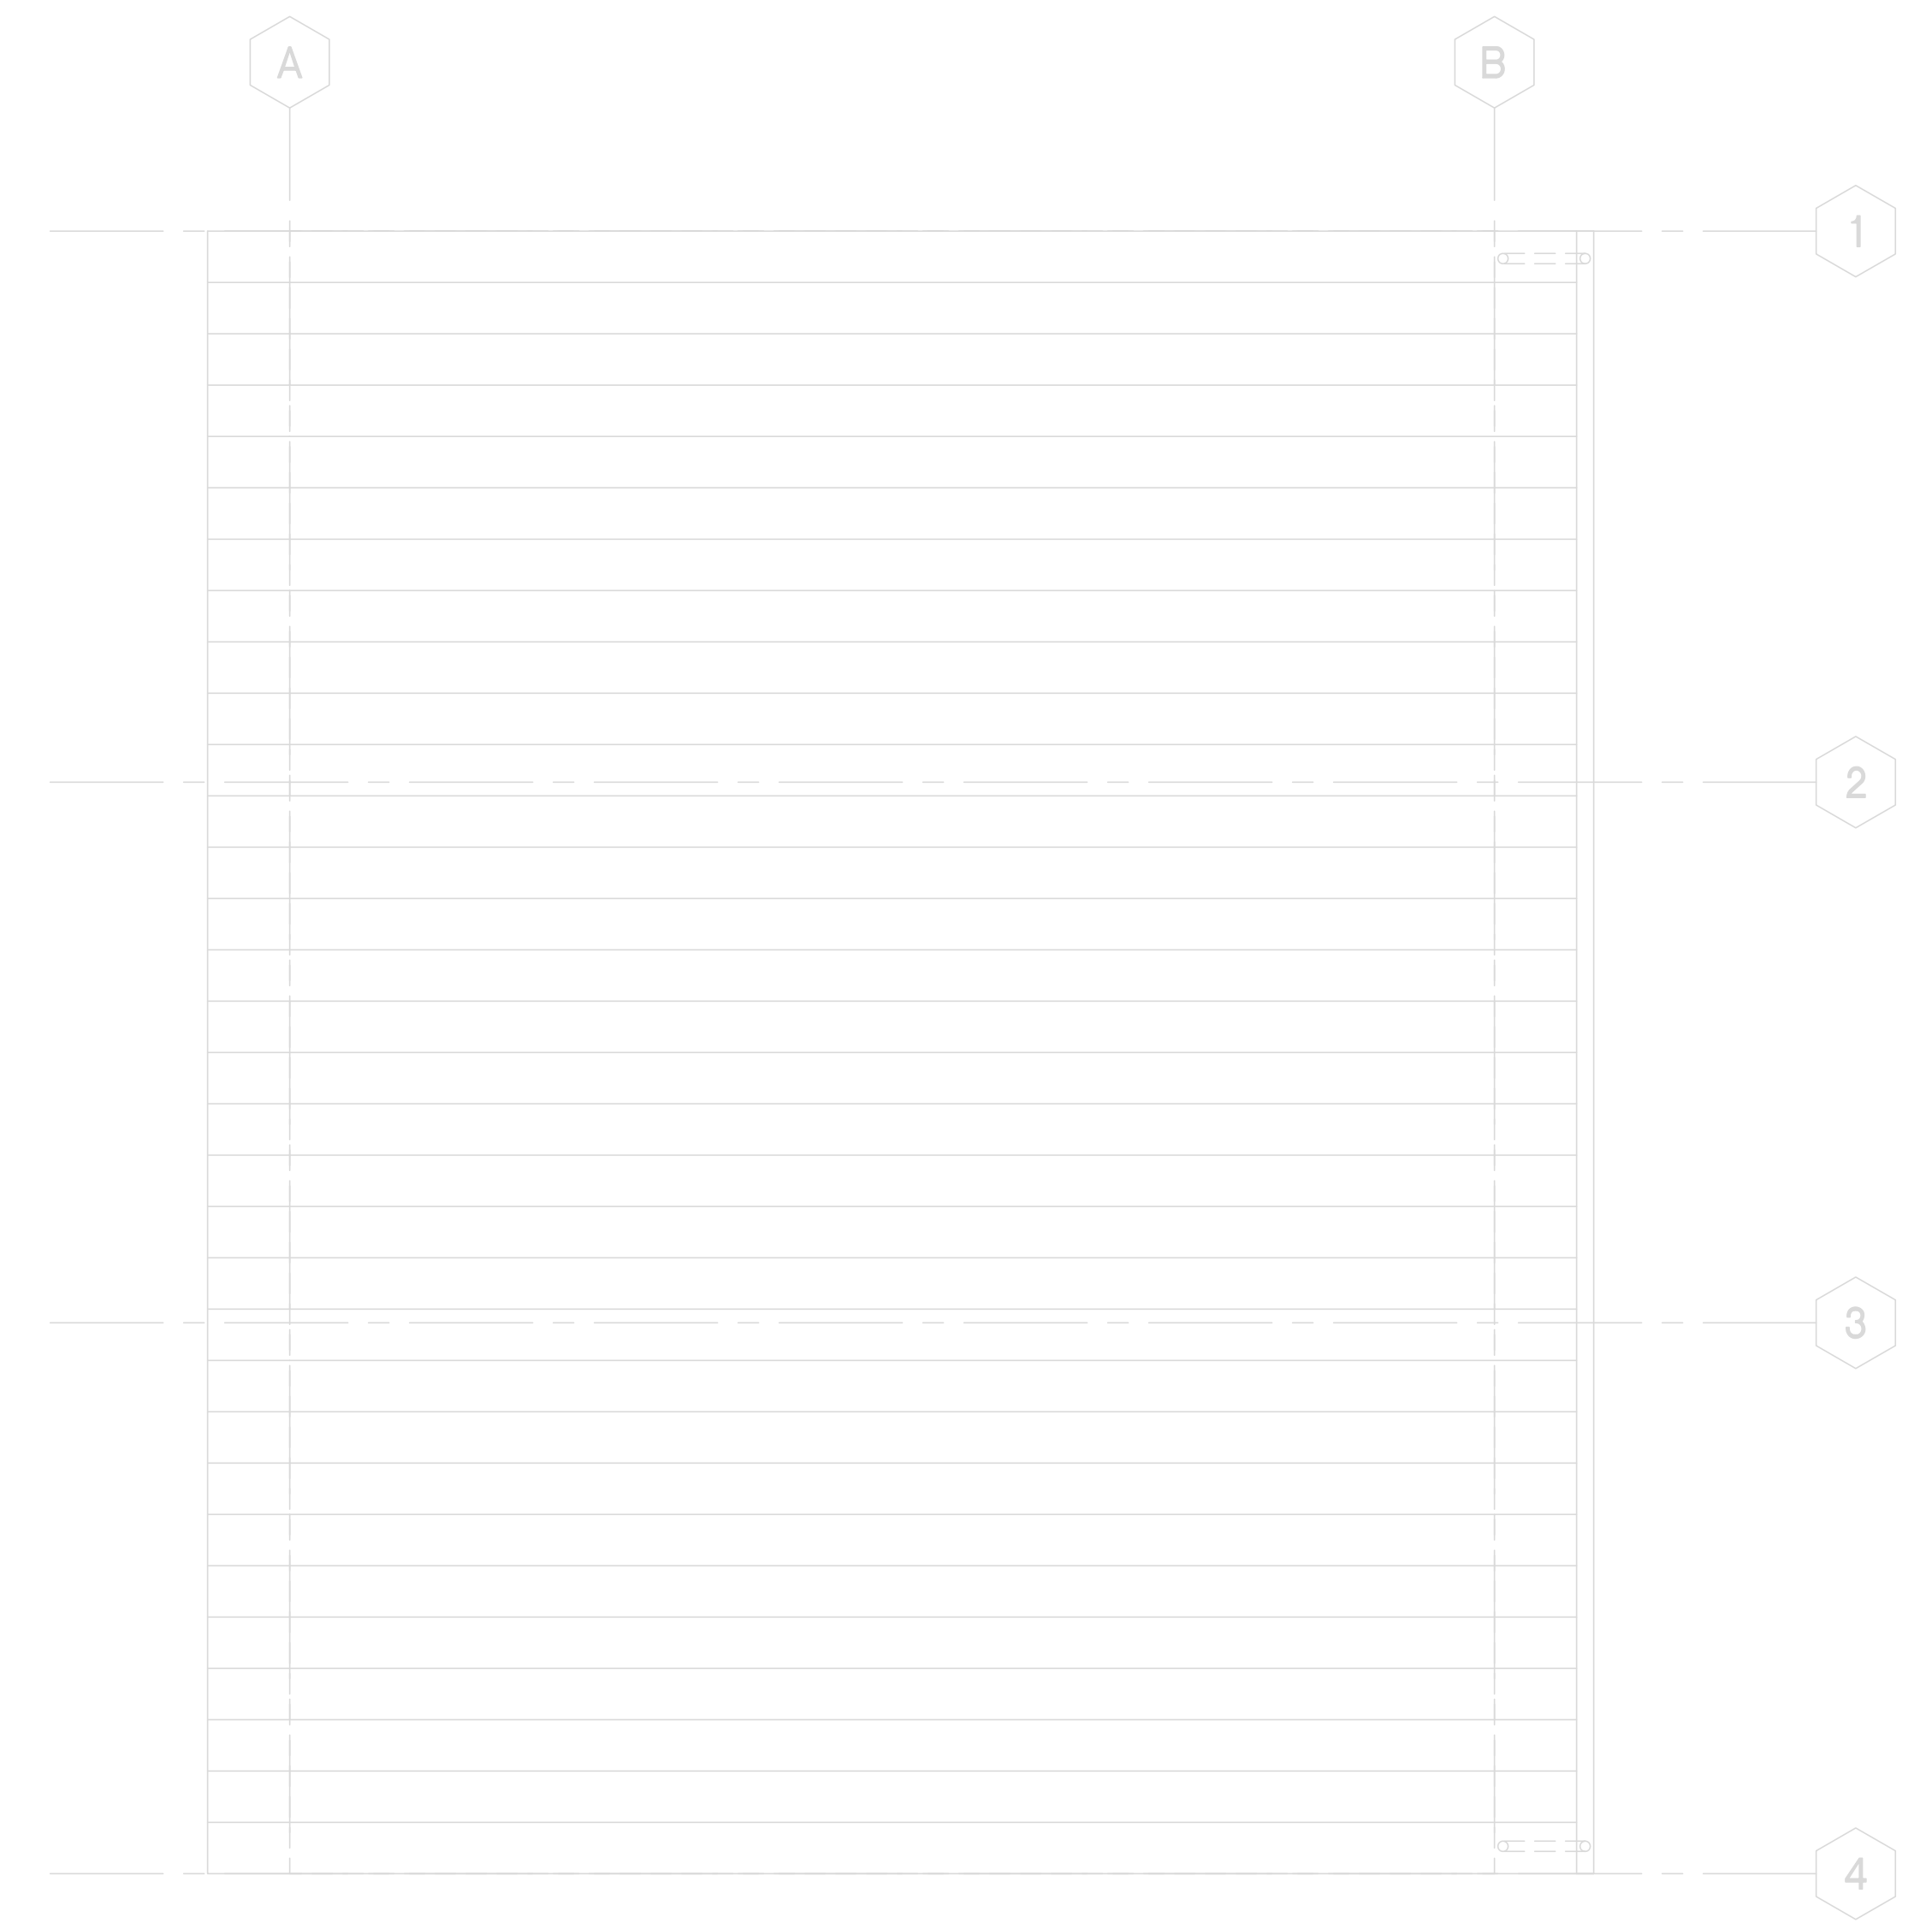

**ROOF PLAN**

**FIRE ALARM PLAN BUILDING 30**  
 SCALE: 1/8" = 1'-0"

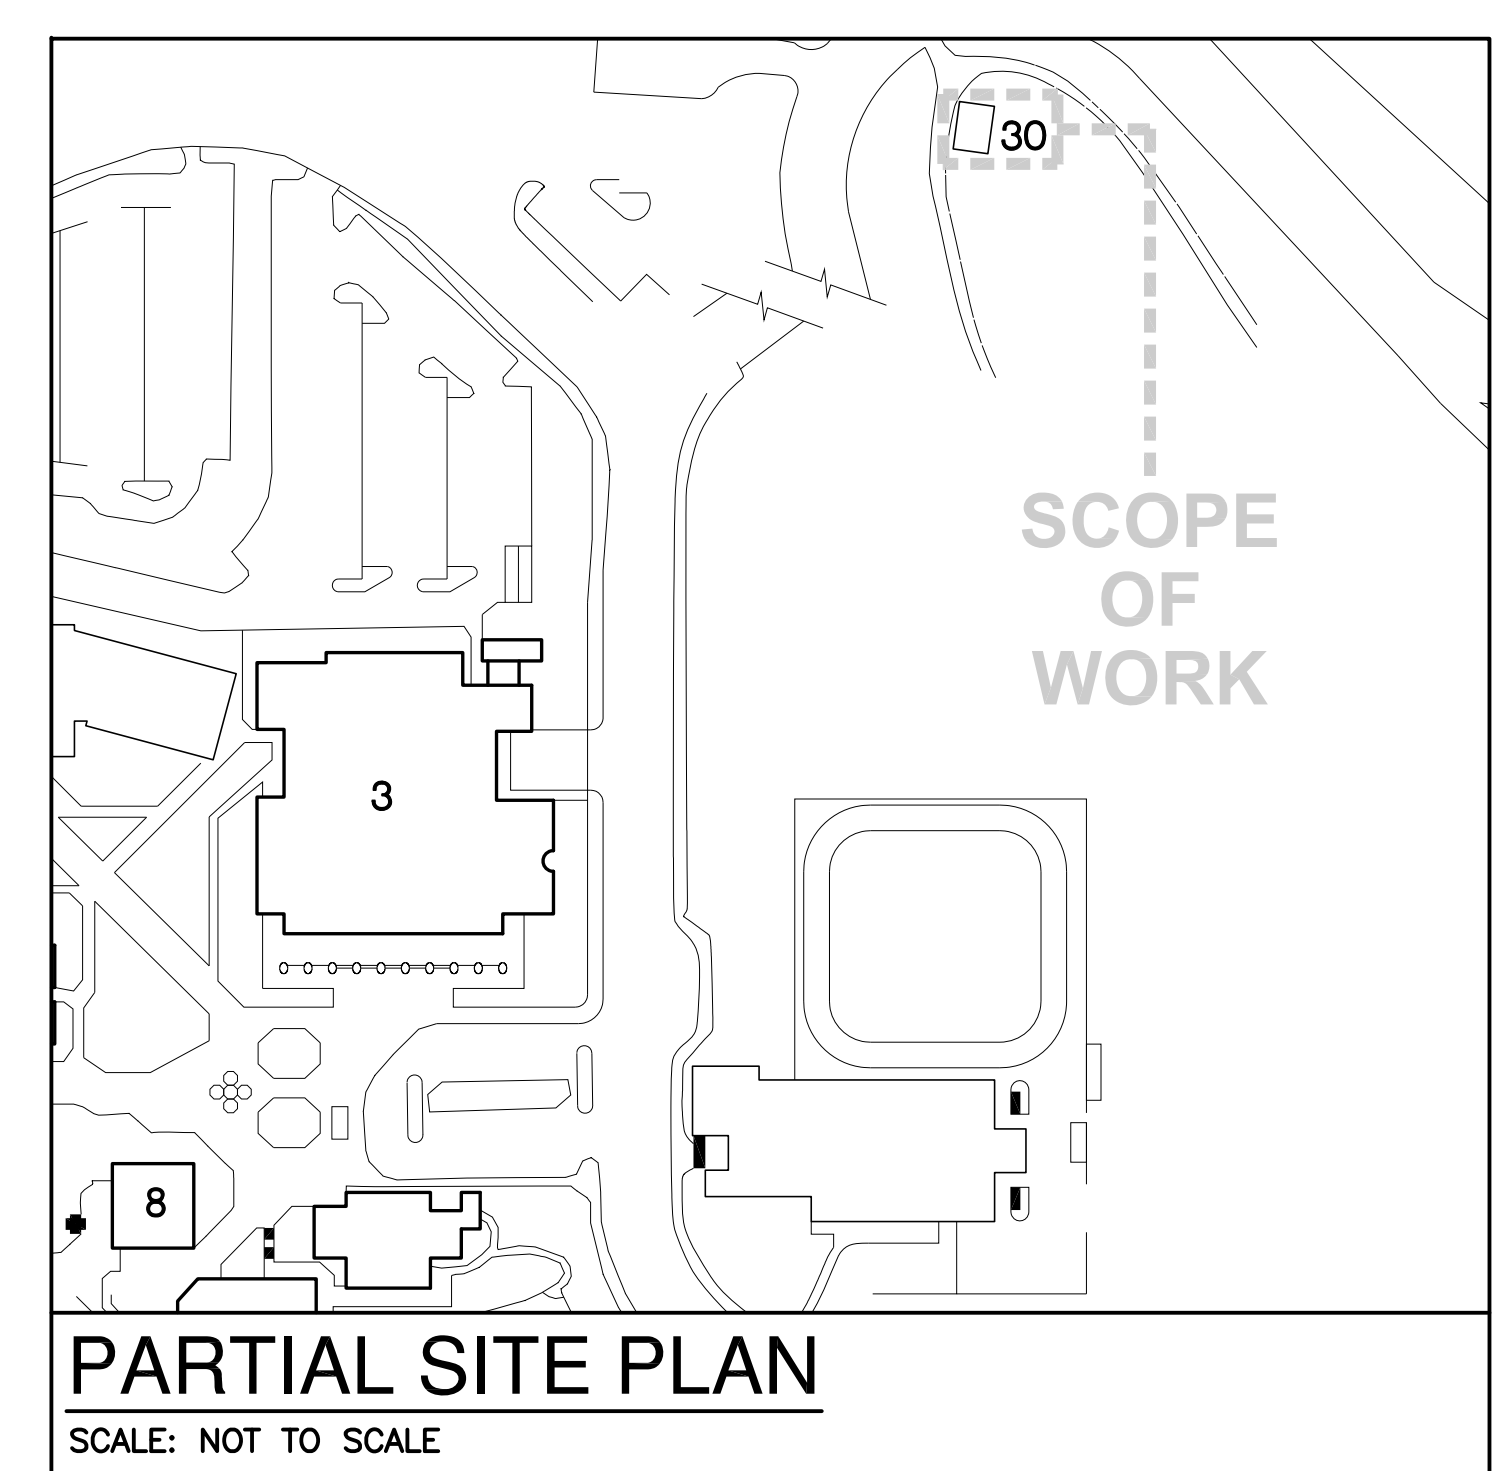

**PARTIAL SITE PLAN**  
 SCALE: NOT TO SCALE

IDENTIFICATION STAMP  
 DIVISION OF THE STATE ARCHITECT  
 APPLICATION NUMBER 01-111618  
 AC \_\_\_\_\_ FL3 \_\_\_\_\_ BS \_\_\_\_\_  
 DATE \_\_\_\_\_

CALIFORNIA STATE FIRE MARSHAL  
 APPROVED  
APPROVAL OF THIS PLAN DOES NOT AUTHORIZE OR APPROVE ANY  
 CONSTRUCTION OR DEVIATION FROM APPLICABLE REGULATIONS. FINAL  
 APPROVAL IS SUBJECT TO REGISTRATION. ONE SET OF APPROVED  
 PLANS SHALL BE AVAILABLE ON THE PROJECT SITE AT ALL TIMES.  
 REVIEWED BY: \_\_\_\_\_ DATE: \_\_\_\_\_

**CAÑADA  
 COLLEGE**  
 Electrical  
 Infrastructure  
 Replacement  
 Project  
 4200 Farm Hill Blvd  
 Redwood City, CA 94061

RECORD DRAWING

SHEET TITLE  
**FIRE ALARM PLAN  
 BUILDING 30**

REVISIONS		
NO.	DATE	DESCRIPTION

DATE July 9, 2012  
 DRAWN TC/AL  
 CHECKED MM  
 SCALE 1/8"=1'0"  
 JOB NO. 2921.01

SHEET NUMBER  
**FA-06**