


NO.	ISSUES/REVISIONS	DATE
1	100% SCHEDULE DESIGN SUBMITTAL	04/20/18
2	50% DESIGN DEVELOPMENT SUBMITTAL	06/13/18
3	100% DESIGN DEVELOPMENT SUBMITTAL	07/20/18
4	100% WORKMENT #1 CALCULATION ROUND GRADING UTILITIES	09/20/18
5	DSA INCIDENT #2. 80% REVIEW	10/10/18
6	DSA INCIDENT #2. 80% REVIEW	10/10/18
7	DSA INCIDENT #2. 80% REVIEW	11/10/18
8	DSA INCIDENT #1. BACK-CHECK	12/19/18
9	DSA INCIDENT #2. 80% REVIEW	02/09/19
10	DSA INCIDENT #2. 80% REVIEW	02/09/19
11	DSA INCIDENT #2. 80% REVIEW	02/09/19
12	DSA INCIDENT #2. 80% REVIEW	02/09/19
13	DSA INCIDENT #2. 80% REVIEW	02/09/19
14	DSA INCIDENT #2. 80% REVIEW	02/09/19

DIVISION OF THE STATE ARCHITECT  
**APPL # 01-110117**  
 FILE # 41C1  
 AC \_\_\_\_\_ FILE \_\_\_\_\_  
 SS \_\_\_\_\_ DATE \_\_\_\_\_  
 IDENTIFICATION STAMP  
**Increment 3**

**SKYLINE COLLEGE  
 CIP2 DESIGN-BUILD  
 PROJECT  
 BUILDING 4  
 INCREMENT 3**

PROJECT NO. 07055.00  
 DATE: 02/07/11  
 SCALE: 3/32" = 1'-0"  
 SHEET TITLE:  
**LEVEL 2 OVERALL FIRE PROTECTION FLOOR PLAN**

PROJECT NO. 07055.00  
 DRAWN BY: CN  
 CHECKED BY: CM  
 DATE: 02/07/11

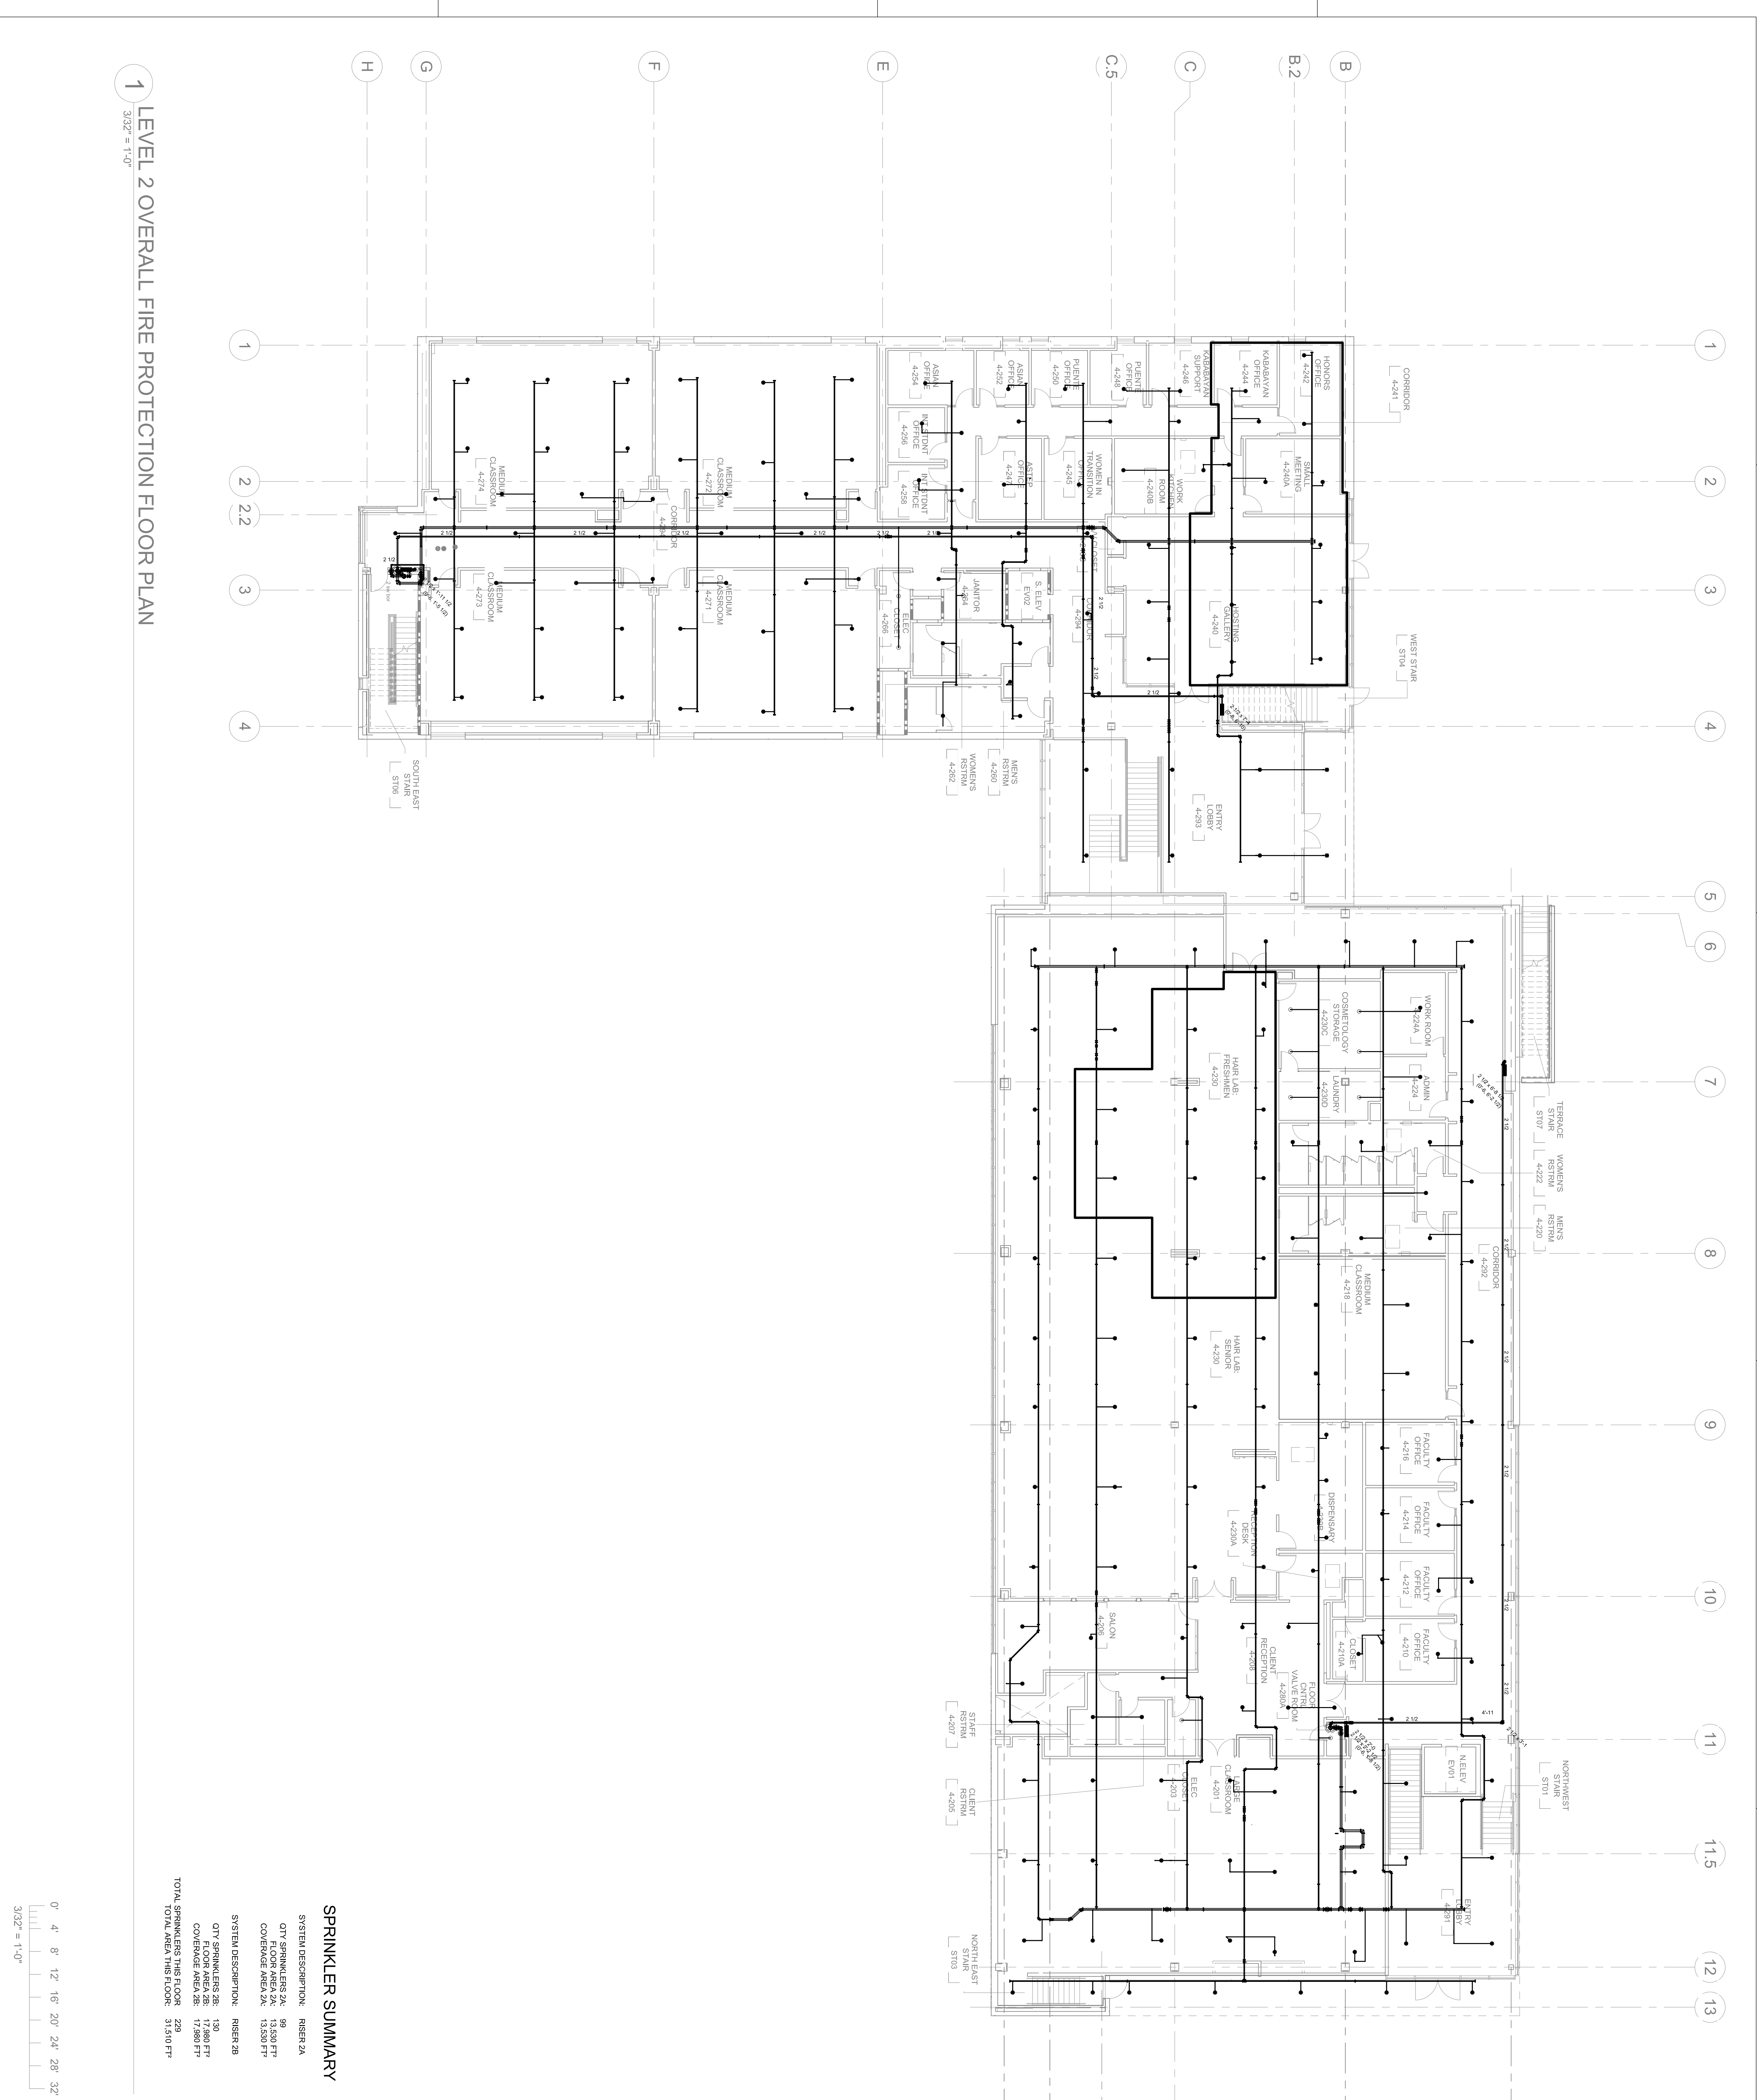

**SPRINKLER SUMMARY**

SYSTEM DESCRIPTION: RISER 2A  
 QTY SPRINKLERS 2A: 99  
 COVERAGE AREA 2A: 13,500 FT<sup>2</sup>

SYSTEM DESCRIPTION: RISER 2B  
 QTY SPRINKLERS 2B: 139  
 COVERAGE AREA 2B: 17,800 FT<sup>2</sup>

TOTAL SPRINKLERS THIS FLOOR: 238  
 TOTAL AREA THIS FLOOR: 31,300 FT<sup>2</sup>

Sprinkler Head Information										
Symbol	Brand	Model	SIN #	Description	Size	Temperature	K	Finish	Escutcheon	Quantity
○	Tyco	TY-EC	TY5237	EC Semi-Recessed Pendant	17/32	155°	11.2	Chrome	Chrome	6
●	Tyco	TY-EC	TY5237	EC Semi-Recessed Pendant	17/32	200°	11.2	Chrome	Chrome	-
●	Tyco	TY-FRB	TY3231	Semi-Recessed Pendant	1/2	155°	5.6	Chrome	Chrome	209
●	Tyco	TY-FRB	TY3231	Semi-Recessed Pendant	1/2	200°	5.6	Chrome	Chrome	-
▶	Tyco	TY-FRB	TY3331	Standard Sidewall	1/2	200°	5.6	Brass	n/a	-
○	Tyco	TY-FRB	TY3131	Standard Upright	1/2	155°	5.6	Brass	n/a	12
Total All Sheets										609

**Standard Symbols**

- Riser Location
- Hangar
- Hangar with rod stiffener
- Two Way Brace
- Four Way Brace
- Hydraulic Node
- End of Line Restraint

**1 LEVEL 2 OVERALL FIRE PROTECTION FLOOR PLAN**  
 3/32" = 1'-0"

All drawings and written material appearing herein constitute original and unpublished work of the Architect/Engineer and may not be duplicated, copied or disclosed without consent of Architect/Engineer.

If this drawing is not 30"x42" when the drawing has been received from the original site, North scales must be adjusted. This line should be equal to one inch.

