

NO.	ISSUES/REVISIONS	DATE
1	100% SCHEDULE DESIGN SUBMITTAL	04/20/18
2	50% DESIGN DEVELOPMENT SUBMITTAL	06/13/18
3	100% DESIGN DEVELOPMENT SUBMITTAL	07/26/18
4	DSA INCIDENT #1 CALCULATION, ROUND ROUNDING ALTIMETERS	09/26/18
5	DSA INCIDENT #2, 50% REVIEW	10/10/18
6	DSA INCIDENT #3, 50% REVIEW	11/14/18
7	DSA INCIDENT #4, 50% REVIEW	11/14/18
8	DSA INCIDENT #5, 50% REVIEW	12/19/18
9	DSA INCIDENT #6, 50% REVIEW	12/19/18
10	DSA INCIDENT #7, 50% REVIEW	02/09/19
11	DSA INCIDENT #8, 50% REVIEW	06/12/19
14	AS-BUILT DRAWINGS	02/07/19

DIVISION OF THE STATE ARCHITECT
APPL # 01-110117
 FILE # 4121
 AC _____
 AS _____
 SS _____
 DATE _____
IDENTIFICATION STAMP
Increment 3



SKYLINE COLLEGE
 SAN MATEO COUNTY
 COMMUNITY COLLEGE
CIP2 DESIGN-BUILD PROJECT BUILDING 4 INCREMENT 3

LEVEL 2 - ENLARGED FIRE PROTECTION PLAN - SECTOR A


PROJECT NO. 07055.00 DRAWN BY: CN
 DATE: 02/07/11 CHECKED BY: CM
 SCALE: 1/8" = 1'-0"
 SHEET NO. FP-102A

HYDRULIC CALCULATION INFORMATION

SYSTEM	2A	SECTOR	A
NO. OF RISERS	1	NO. OF HEADS	13
TYPE OF HEADS	EC	TYPE OF HEADS	EC
HEAD LOCATION	INSIDE	TYPE OF HEADS	1/2" NIP
HEAD HEIGHT	30	TYPE OF HEADS	0.94"
HEAD SIZE	3/2"	TYPE OF HEADS	552
HEAD WEIGHT	47	TYPE OF HEADS	478

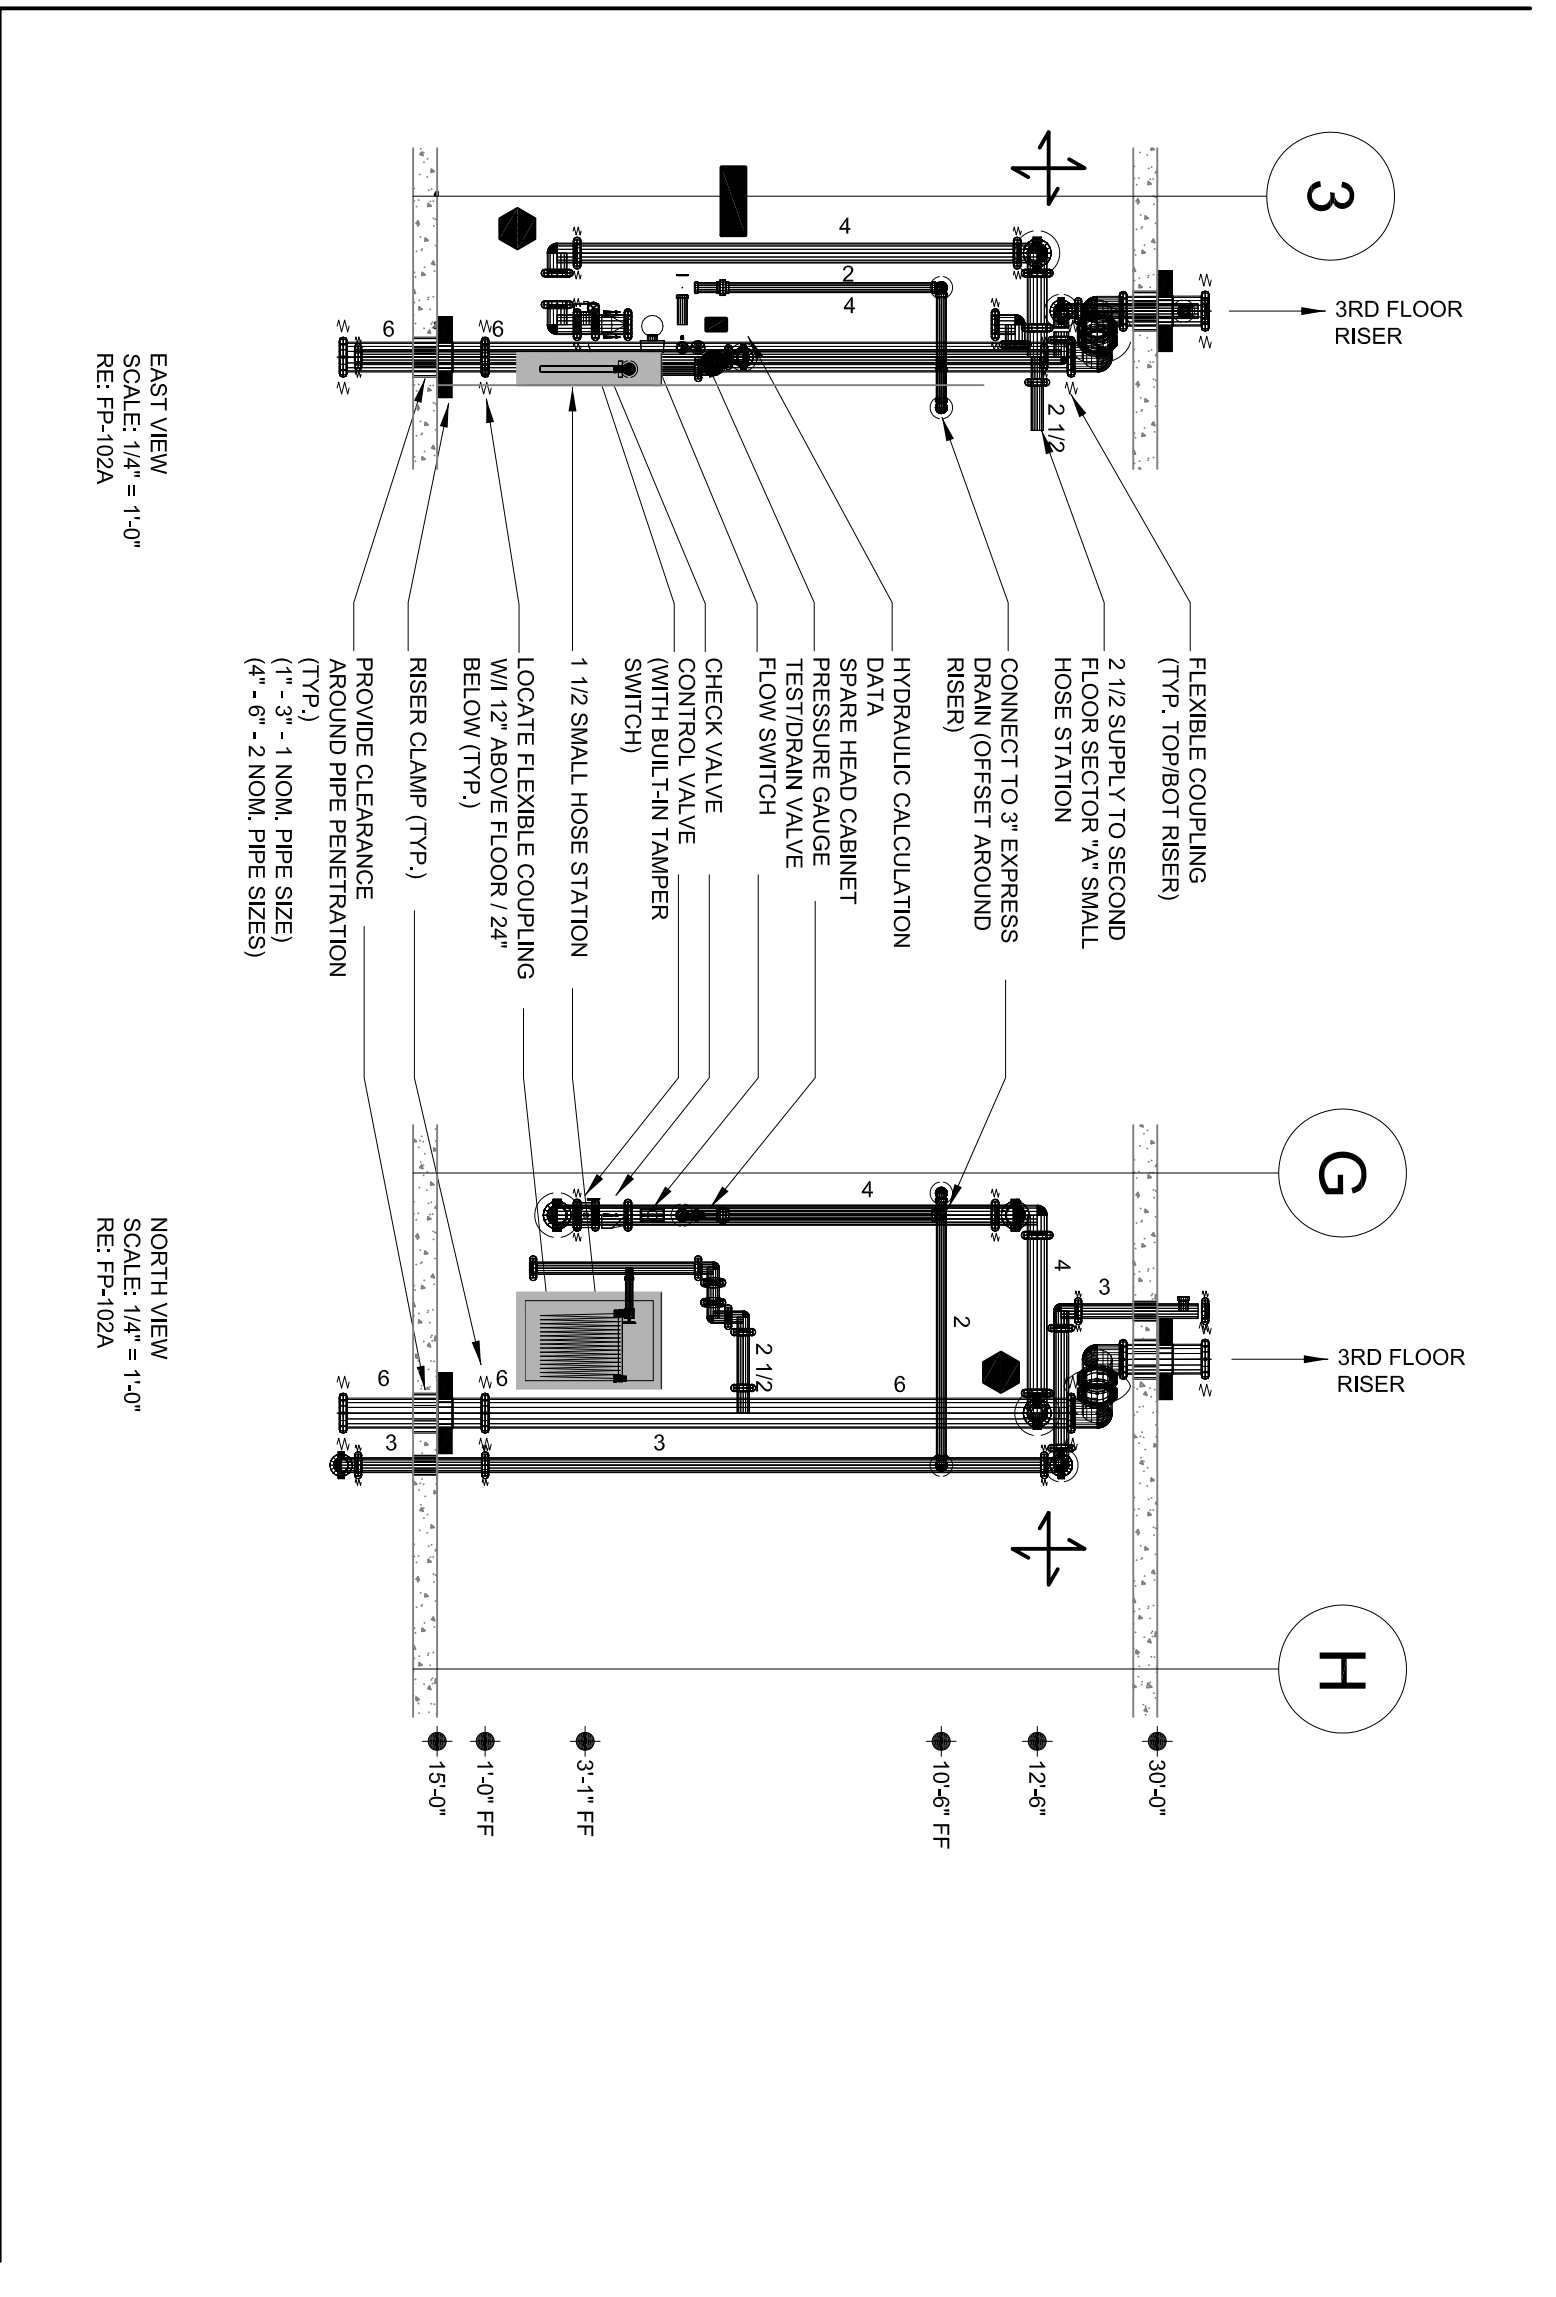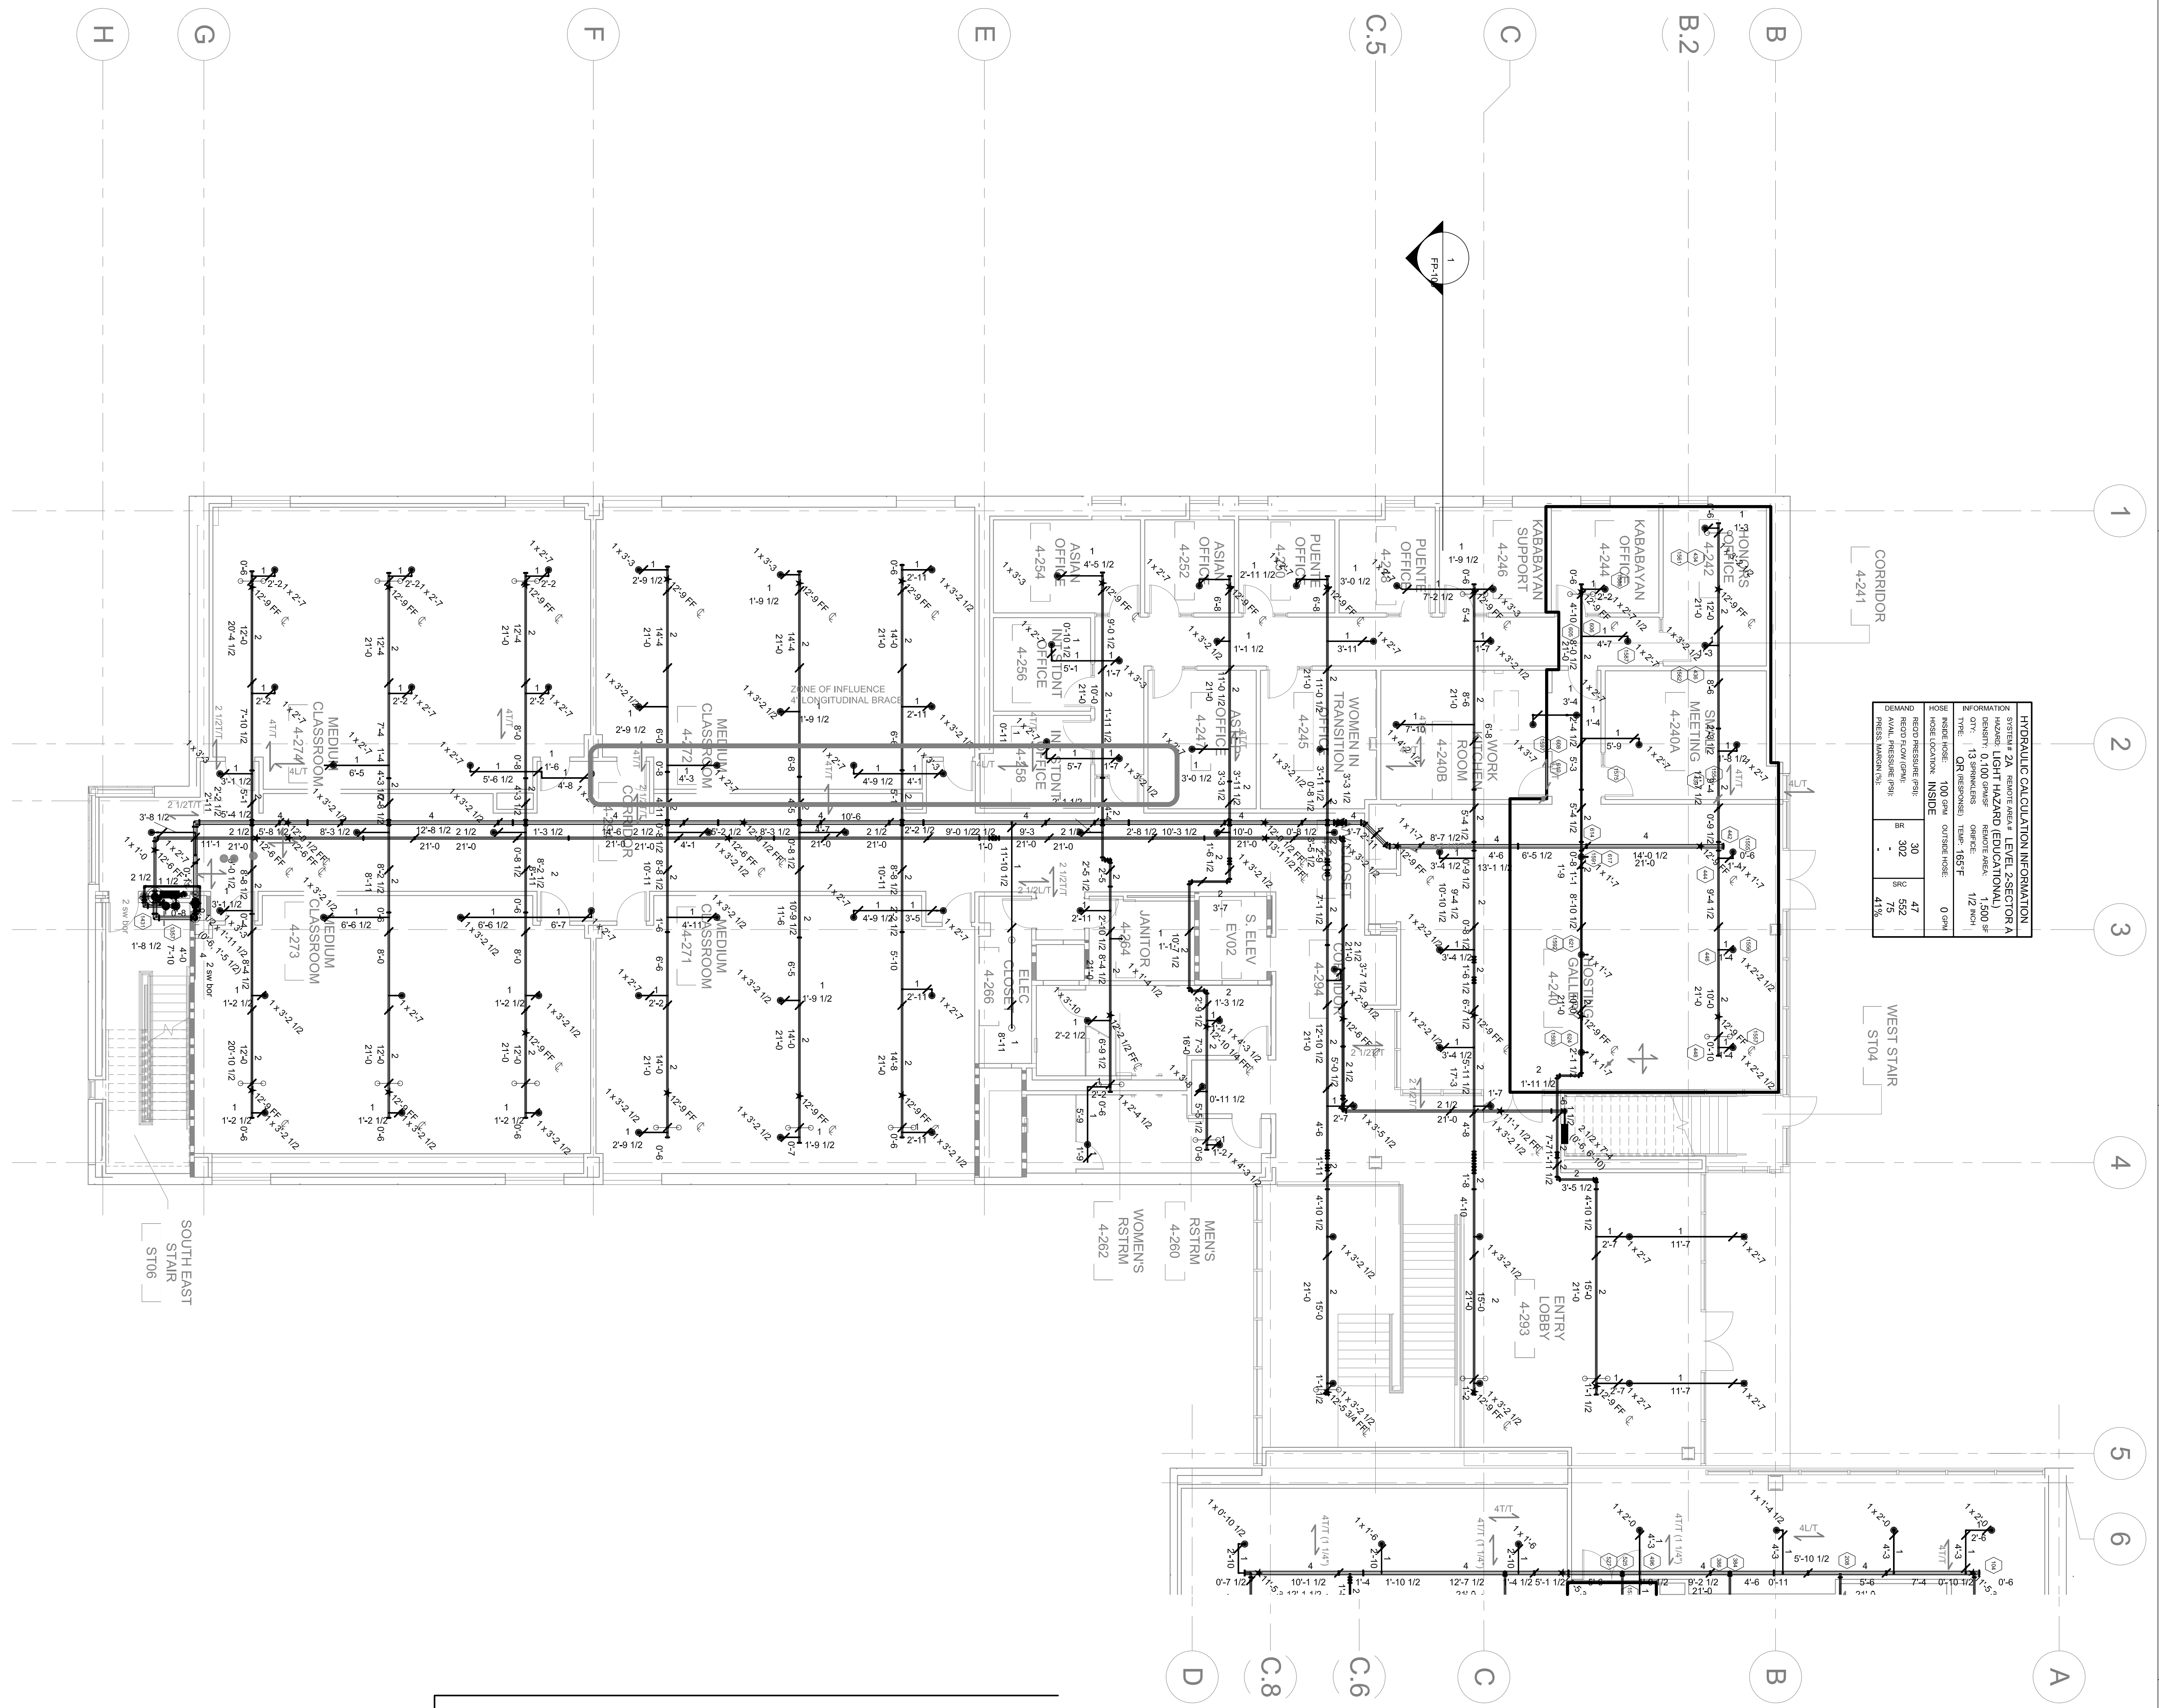

2 LEVEL 2 - ENLARGED FIRE RISER DIAGRAM - SECTOR A
 1/4" = 1'-0"
 0" 4" 8" 12"

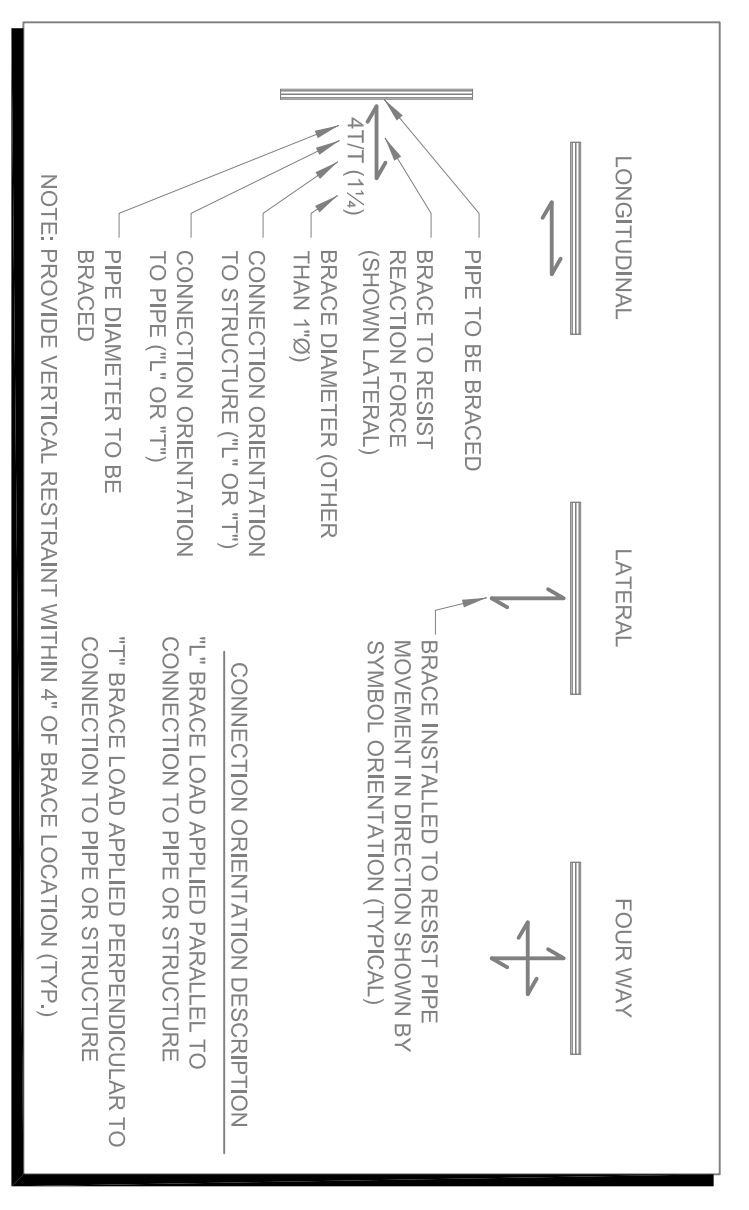

Sprinkler Head Information

Symbol	Brand	Model	SIN #	Description	Size	Temperature	K	Finish	Escutcheon	Quantity
○	Tyco	TY-EC	TY5237	EC Semi-Recessed Pendant	17/32	155°	11.2	Chrome	Chrome	2
●	Tyco	TY-EC	TY5237	EC Semi-Recessed Pendant	17/32	200°	11.2	Chrome	Chrome	-
●	Tyco	TY-FRB	TY3231	Semi-Recessed Pendant	1/2	155°	5.6	Chrome	Chrome	93
●	Tyco	TY-FRB	TY3231	Semi-Recessed Pendant	1/2	200°	5.6	Chrome	Chrome	-
●	Tyco	TY-FRB	TY3331	Standard Sidewall	1/2	200°	5.6	Brass	n/a	-
○	Tyco	TY-FRB	TY3131	Standard Upright	1/2	155°	5.6	Brass	n/a	4

Total All Sheets 603

All drawings and written material appearing herein constitute original and unpublished work of the Architect/Engineer and may not be duplicated, copied or disclosed without consent of Architect/Engineer.
 If this drawing is not 30"x42", then the drawing has been revised from its original size.
 Note: All dimensions shall be indicated. This line should be equal to one inch.
 1/8" = 1'-0"