

NO.	REVISIONS	DATE
1	10% SCHEDULE DESIGN SUBMITTAL	04/20/18
2	50% DESIGN DEVELOPMENT SUBMITTAL	08/10/18
3	100% DESIGN DEVELOPMENT SUBMITTAL	07/20/19
4	SITE DEMOLITION EXCAVATION	08/20/19
5	ROAD GRADING UTILITIES	08/20/19
6	ROAD WORKMENT R2 80% REVIEW	10/06/19
7	ROAD WORKMENT R2 80% REVIEW	11/11/19
8	ROAD WORKMENT R2 80% REVIEW	11/16/19
9	ROAD WORKMENT R2 80% REVIEW	12/16/19
10	ROAD WORKMENT R2 80% REVIEW	02/06/20
14	AS-BUILT DRAWINGS	06/12/20

DIVISION 05
 THE STATE ARCHITECT
 APPL # 01-110117
 FILE # 41-C1
 NO. _____ DATE _____
 SSN _____
Increment 3
 IDENTIFICATION STAMP


SKYLINE COLLEGE
 SAN MATEO COUNTY
 DISTRICT COLLEGE
CIP2 DESIGN-BUILD
PROJECT
BUILDING 4
INCREMENT 3

LEVEL 2 - ENLARGED FIRE PROTECTION PLAN - SECTOR B

SHEET TITLE

PROJECT NO.: 070552.00 DRAWN BY: CN
 DATE: 02/07/11 CHECKED BY: CM
 SCALE: 1/8" = 1'-0"


SHEET NO.: **FP-102B**

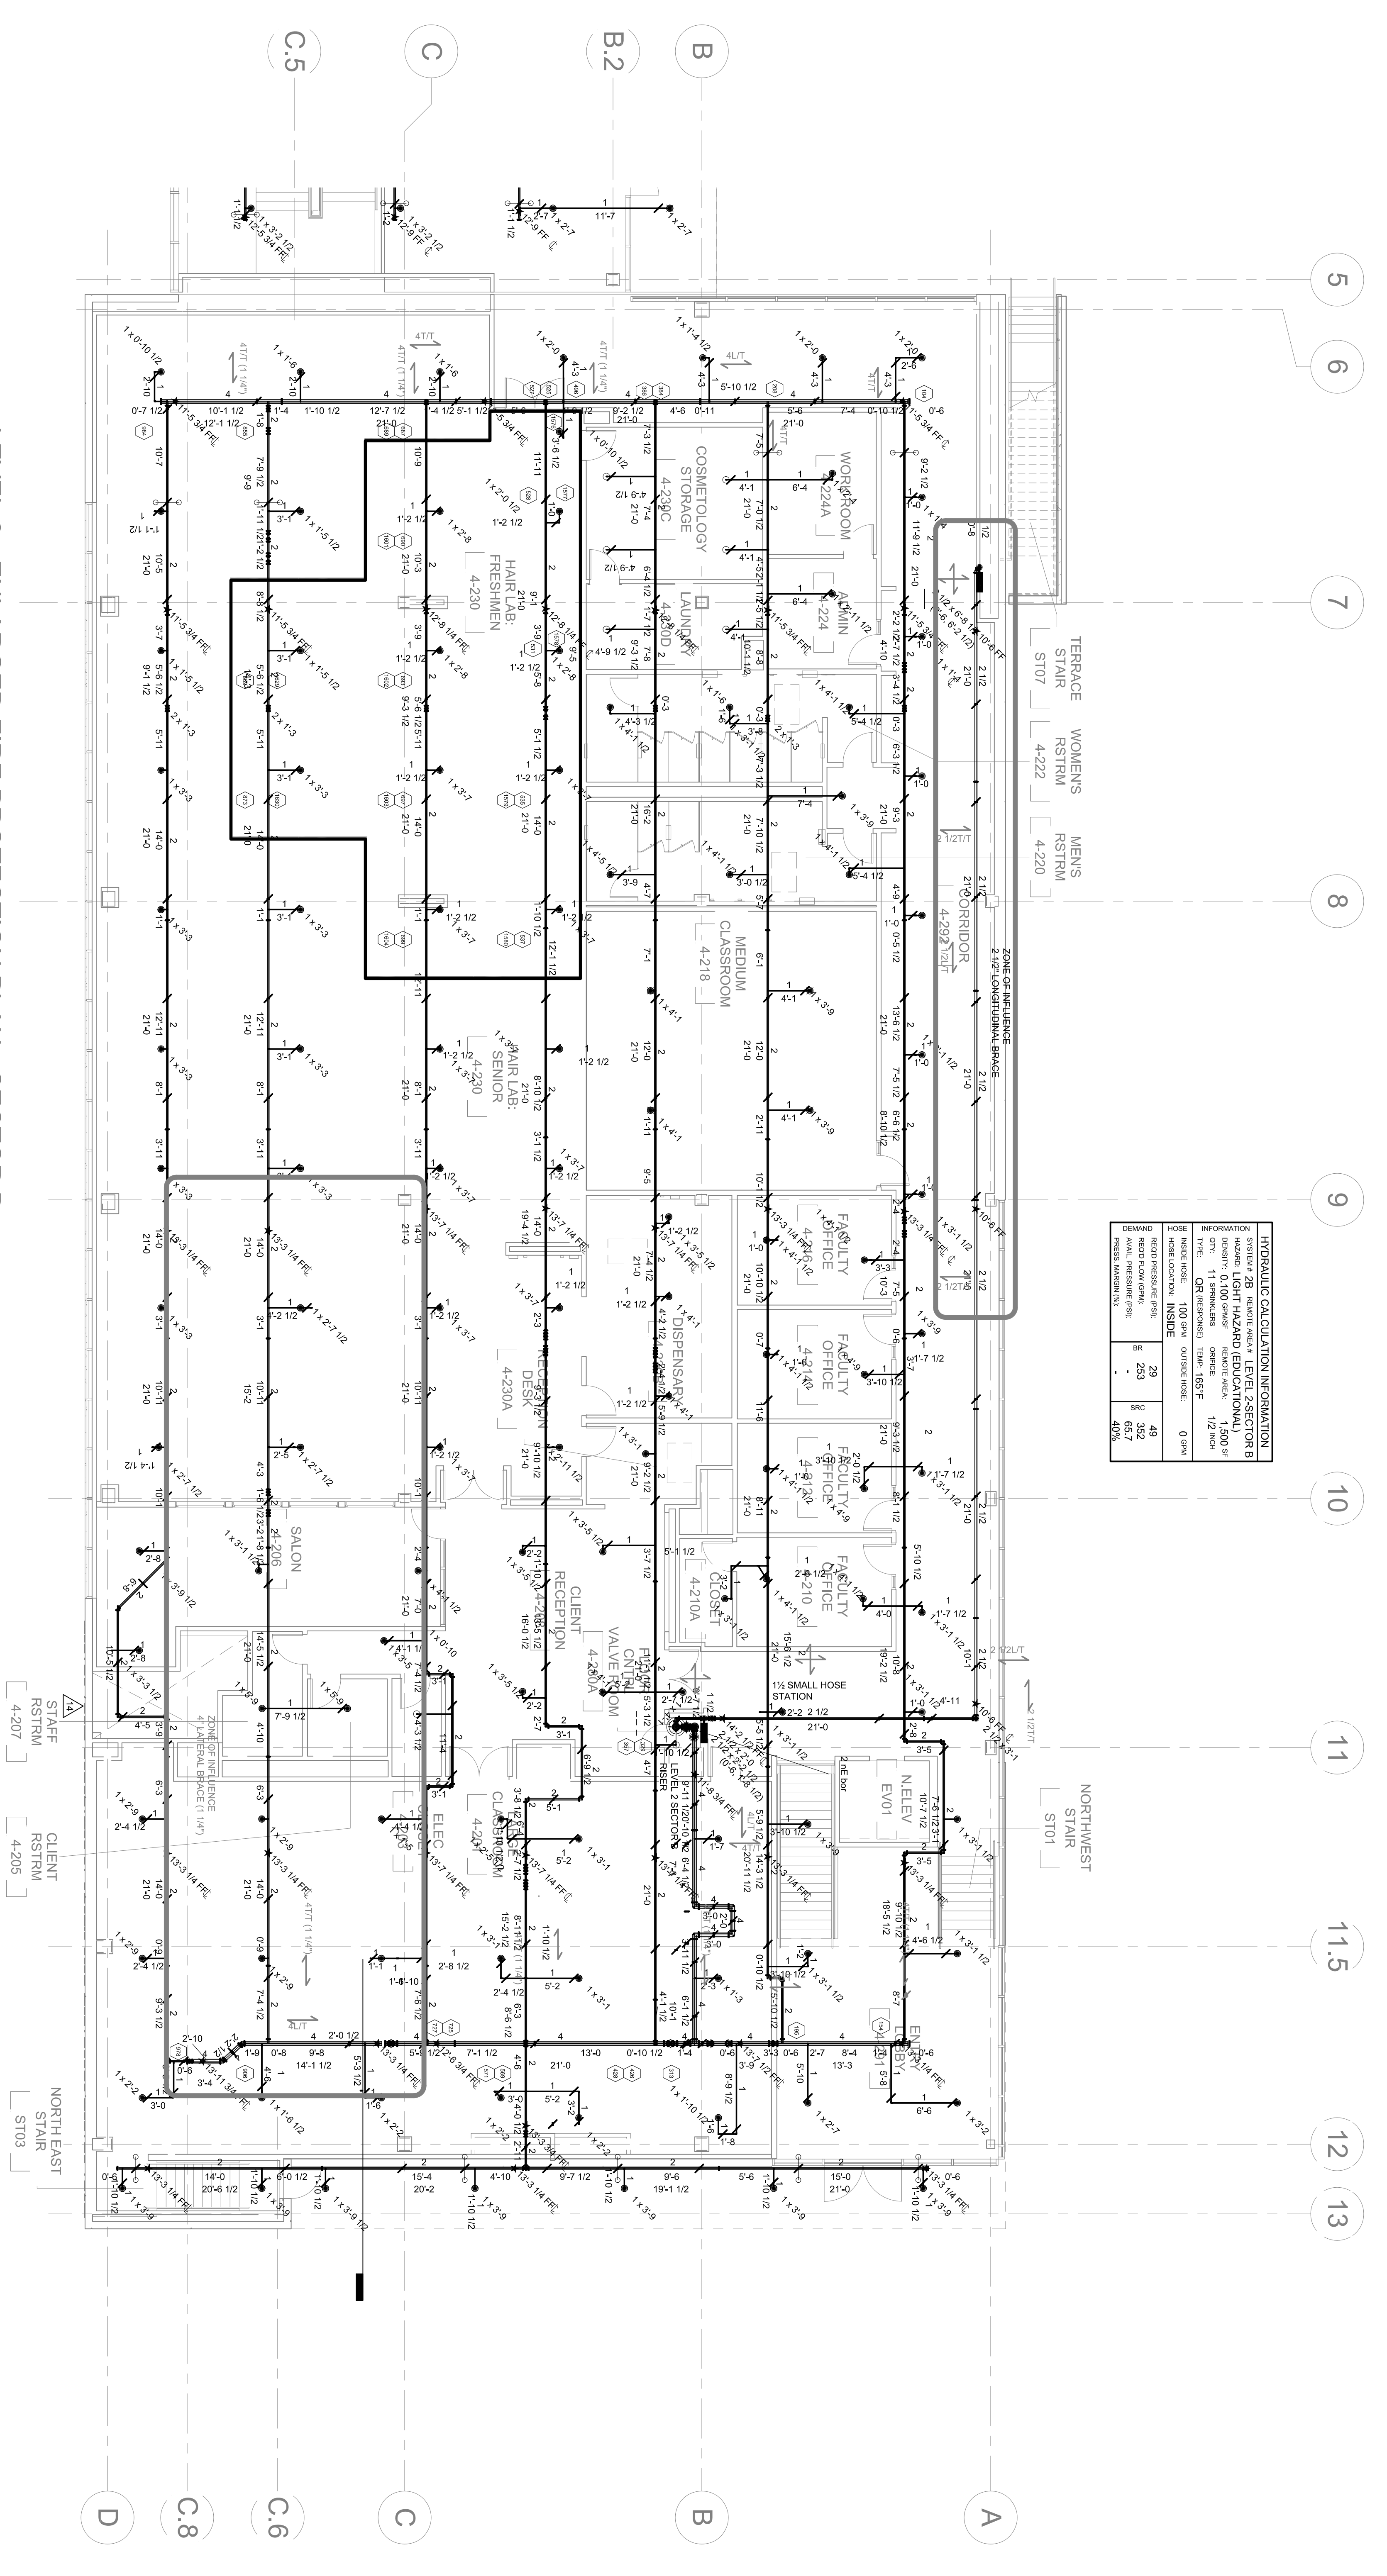


HYDRAULIC CALCULATION INFORMATION

NO.	DESCRIPTION	UNIT	VALUE
1	WATER DEMAND	MGD	2.0
2	WATER DEMAND	MGD	2.0
3	WATER DEMAND	MGD	2.0
4	WATER DEMAND	MGD	2.0
5	WATER DEMAND	MGD	2.0
6	WATER DEMAND	MGD	2.0
7	WATER DEMAND	MGD	2.0
8	WATER DEMAND	MGD	2.0
9	WATER DEMAND	MGD	2.0
10	WATER DEMAND	MGD	2.0
11	WATER DEMAND	MGD	2.0
12	WATER DEMAND	MGD	2.0
13	WATER DEMAND	MGD	2.0
14	WATER DEMAND	MGD	2.0
15	WATER DEMAND	MGD	2.0
16	WATER DEMAND	MGD	2.0
17	WATER DEMAND	MGD	2.0
18	WATER DEMAND	MGD	2.0
19	WATER DEMAND	MGD	2.0
20	WATER DEMAND	MGD	2.0
21	WATER DEMAND	MGD	2.0
22	WATER DEMAND	MGD	2.0
23	WATER DEMAND	MGD	2.0
24	WATER DEMAND	MGD	2.0
25	WATER DEMAND	MGD	2.0
26	WATER DEMAND	MGD	2.0
27	WATER DEMAND	MGD	2.0
28	WATER DEMAND	MGD	2.0
29	WATER DEMAND	MGD	2.0
30	WATER DEMAND	MGD	2.0
31	WATER DEMAND	MGD	2.0
32	WATER DEMAND	MGD	2.0
33	WATER DEMAND	MGD	2.0
34	WATER DEMAND	MGD	2.0
35	WATER DEMAND	MGD	2.0
36	WATER DEMAND	MGD	2.0
37	WATER DEMAND	MGD	2.0
38	WATER DEMAND	MGD	2.0
39	WATER DEMAND	MGD	2.0
40	WATER DEMAND	MGD	2.0
41	WATER DEMAND	MGD	2.0
42	WATER DEMAND	MGD	2.0
43	WATER DEMAND	MGD	2.0
44	WATER DEMAND	MGD	2.0
45	WATER DEMAND	MGD	2.0
46	WATER DEMAND	MGD	2.0
47	WATER DEMAND	MGD	2.0
48	WATER DEMAND	MGD	2.0
49	WATER DEMAND	MGD	2.0
50	WATER DEMAND	MGD	2.0

1 LEVEL 2 - ENLARGED FIRE PROTECTION PLAN - SECTOR B
 1/8" = 1'-0"

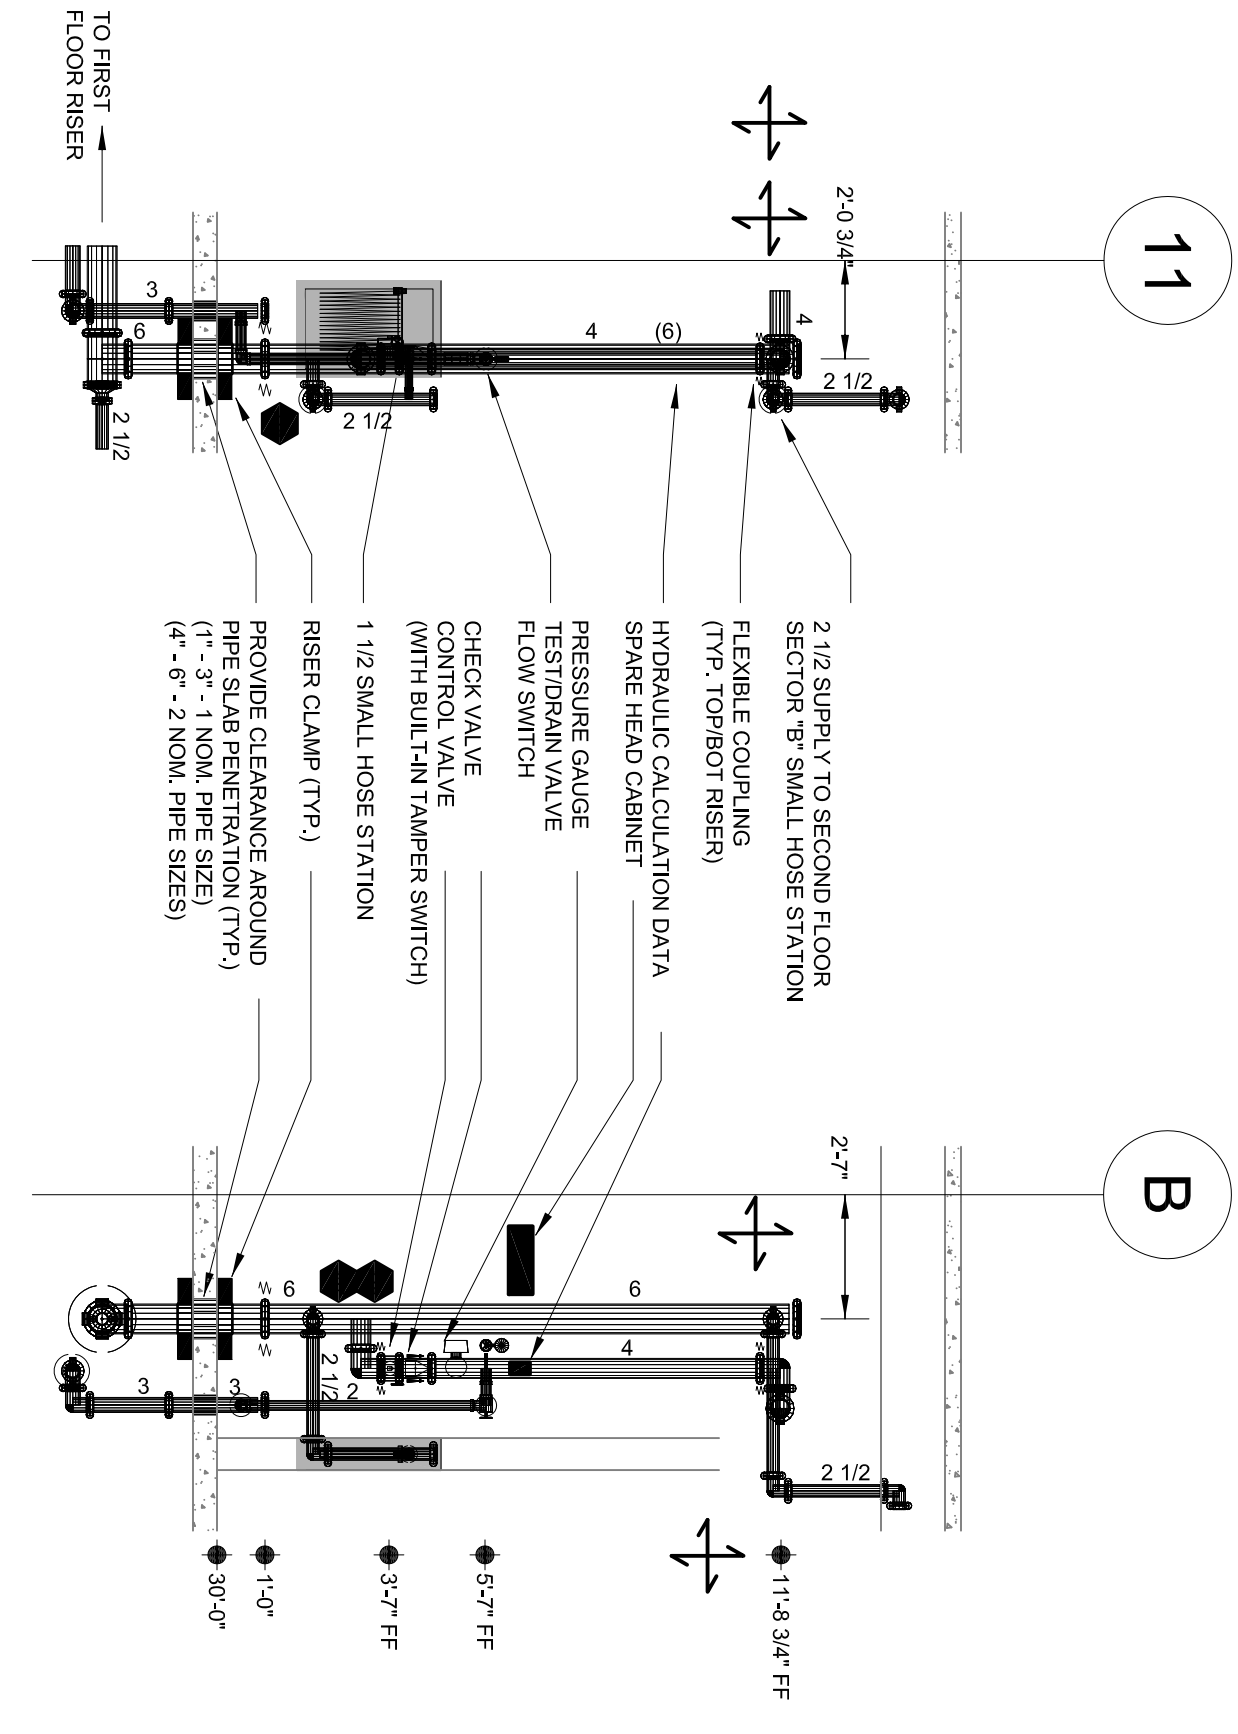

2 LEVEL 2 - ENLARGED FIRE RISER DIAGRAM - SECTOR B
 1/4" = 1'-0"

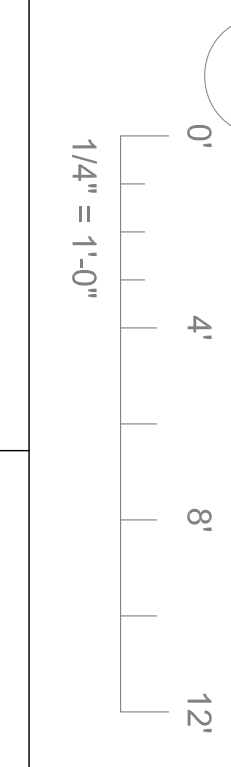

All drawings and details are the property of Steinberg Architects. No part of this drawing may be reproduced or transmitted in any form or by any means, electronic or mechanical, including photocopying, recording, or by any information storage and retrieval system, without the prior written permission of Steinberg Architects.

This drawing is not to be used for construction without the prior written permission of Steinberg Architects. The user of this drawing assumes all liability for any errors or omissions. The user should refer to the original drawing for all details.

North arrow pointing towards the top of the page.