



PARTIAL ROOF PLAN
SCALE: 1/8" = 1'-0"


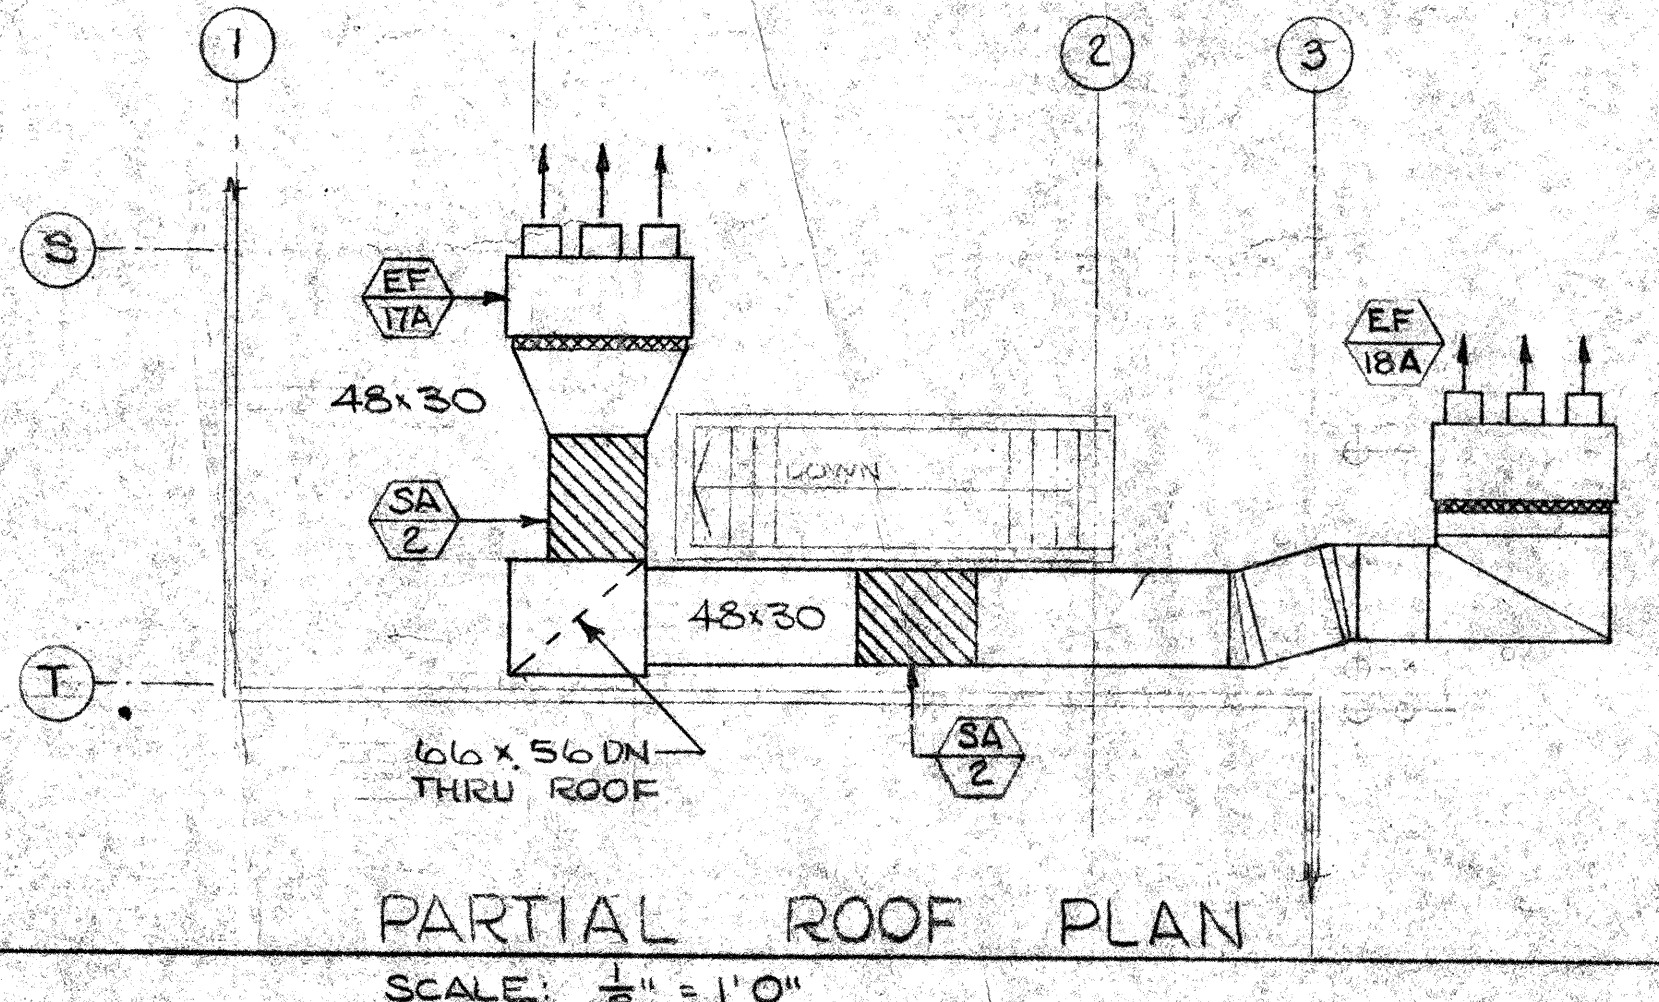


PARTIAL ROOF PLAN
SCALE: 1/8" = 1'-0"

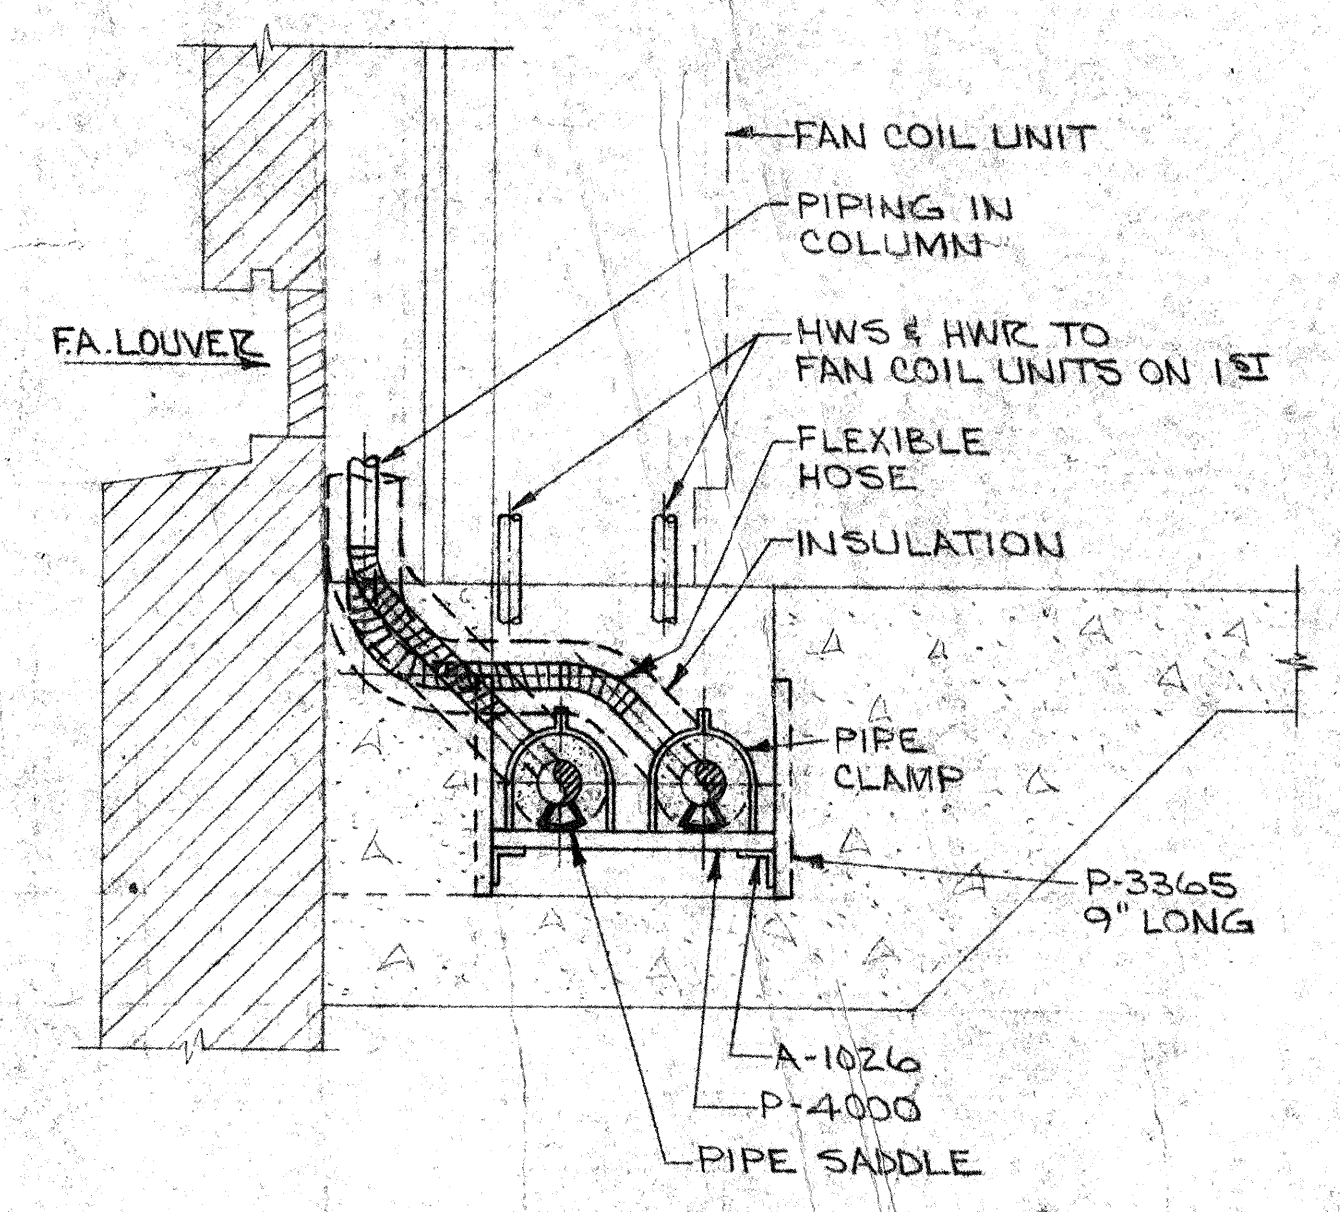


SECTION A-MAA
SCALE: 1/2" = 1'-0"

NOTES: 1. NUMBERS OF SUPPORT MEMBERS REFER TO "UNISTRUT" NUMBERS FOR QUALITY REF ONLY.
2. SEE ARCHITECTURAL DWGS. FOR TRENCH & COVER DETAILS.

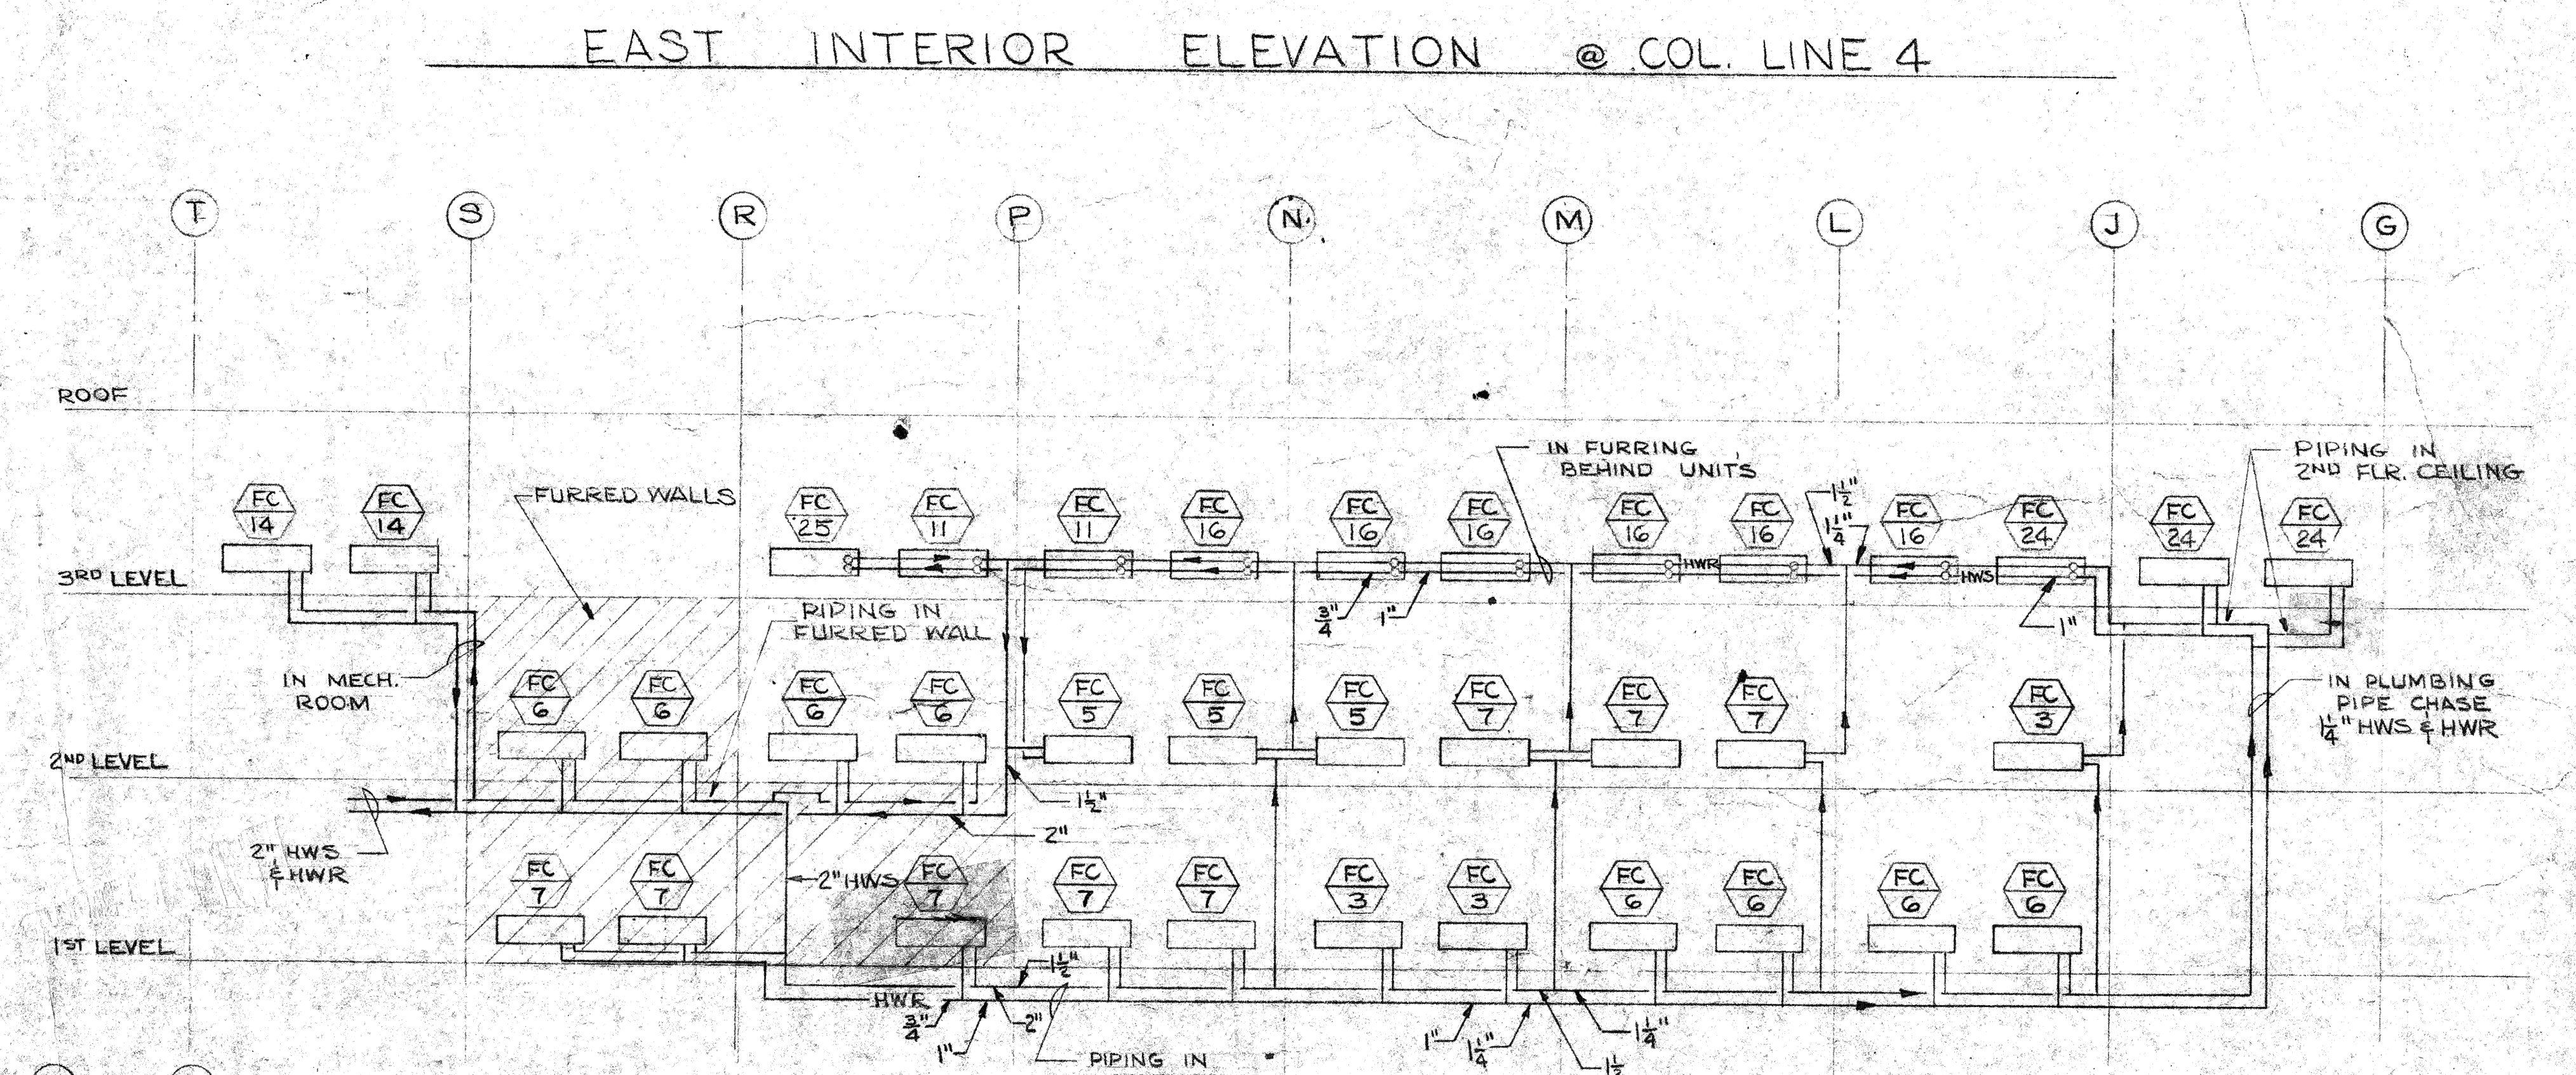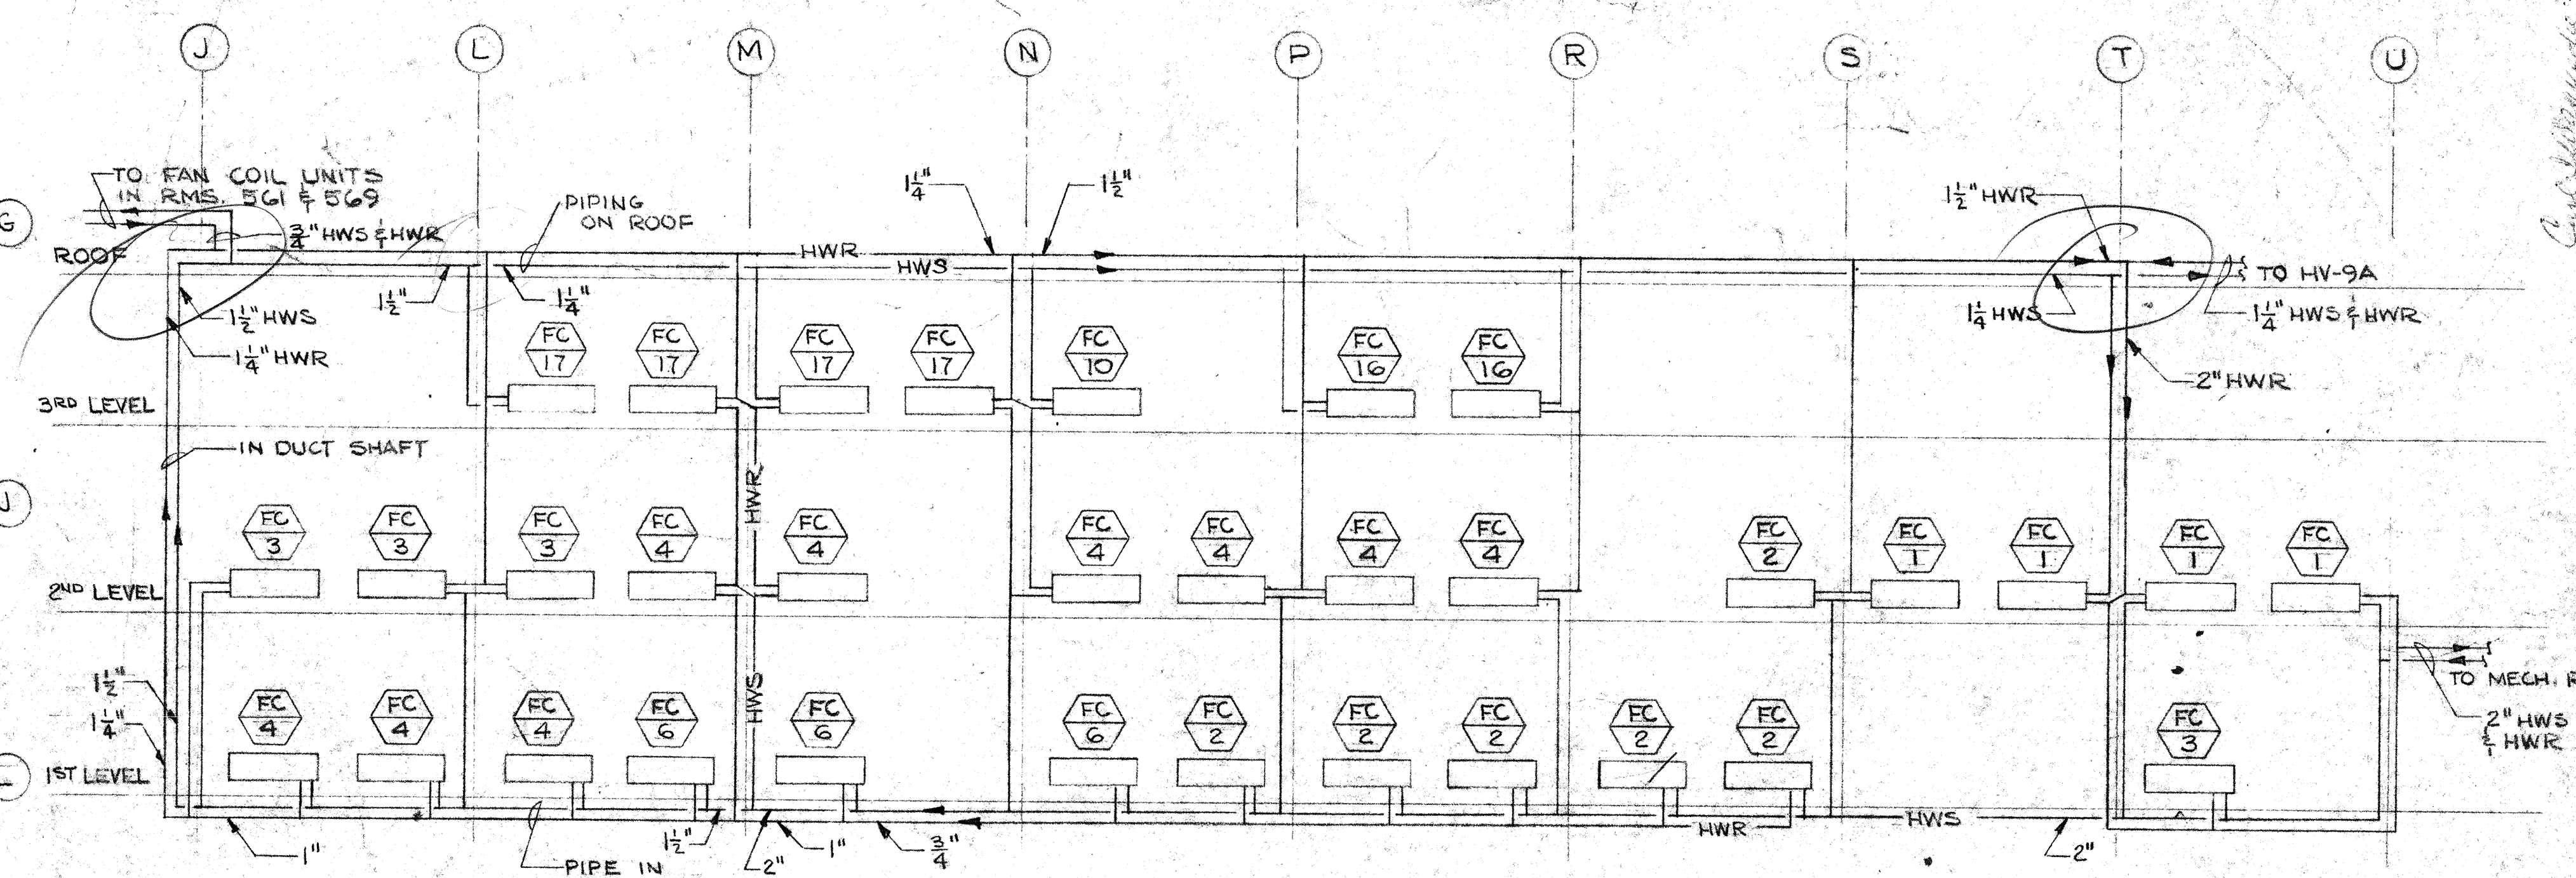

HEATING PIPING RISER DIAGRAMS
SCALE: NONE

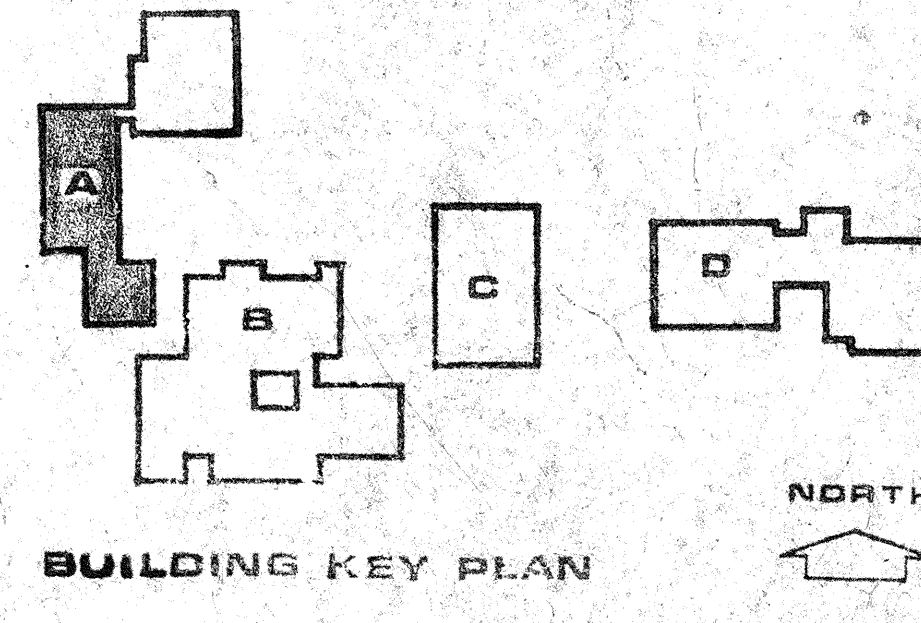

JOHN CARL WARNECKE AND ASSOCIATES
ARCHITECTS AND PLANNING CONSULTANTS
61 NEW MONTGOMERY STREET SAN FRANCISCO

COLLEGE OF SAN MATEO
SAN BRUNO CALIFORNIA

BUILDING A - SCIENCE, TECH. LAB., MECHANICAL 3RD LEVEL PLAN

SCALE AS SHOWN
JOB NO. 64-15
D.B. J.M.
CHECK BY G.R.L.
DATE JUN 16, 1967

SHEET NUMBER
OF 4 SHEETS
REVISION NO.

NO.	REVISION DESCRIPTION	DATE	APPROVED