


1 SITE PLAN
SCALE: 1" = 20'-0"

SHEET NOTES

- 1 3" HEATING HOT WATER RICWIL PIPING SYSTEMS TERRA-GARD PREFABRICATED INSULATED UNDERGROUND OR EQUAL BY PERMA-PIPE OR ROVANCO WITH BLACK STEEL BUTTWELD, PREFABRICATED AND PREINSULATED FITTINGS TO MATCH.
- 2 CONNECT TO EXISTING CAMPUS HWS&R UNDERGROUND BRANCH PIPING INSIDE (E) VALVE BOX (PROVIDE (N) VALVE BOX IF (E) IS MISSING). PROVIDE AIR VENTS FOR EACH SUPPLY AND RETURN PIPE, (N) 3" FLANGED SHUT-OFF VALVES FOR CHILD DEVELOPMENT CENTER AND 2" VALVES WITH BLANK FLANGES FOR FUTURE EXTENSION. CONFORM TO DISTRICT STANDARDS.
- 3 2" CHILLED WATER RICWIL PIPING SYSTEMS TERRA-GARD PREFABRICATED INSULATED UNDERGROUND OR EQUAL BY PERMA-PIPE OR ROVANCO WITH COPPER; SWEAT, PREFABRICATED AND PREINSULATED FITTINGS TO MATCH.
- 4 PAD MOUNTED CHILLER (SEE DETAIL 8/M2.1).
- 5 PROVIDE FLEXIBLE PIPING CONNECTIONS AT CONNECTION TO CHILLER (TYP.).
- 6 CHILLER EQUIPMENT YARD SCREEN WALL WITH 50% FREE AREA (SAD).
- 7 *OPEN CHAIN-LINK FENCE (SAD).
- 8 VERIFY DIMENSIONS OF EQUIPMENT YARD AND OPENNESS OF SCREEN WALLS WITH CHILLER MANUFACTURER DURING SHOP DRAWING PHASE AND PRIOR TO ANY SITE WORK IN THE AREA.

AS-BUILTS

NO.	DATE	REASON	BY

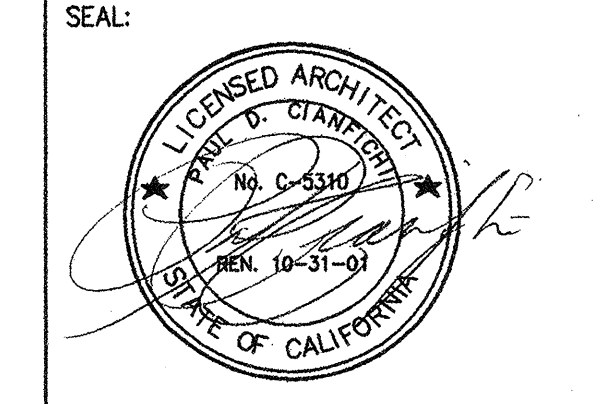

ARCHITECT:
CONSULTANT:

CONSULTING MECHANICAL DESIGN STUDIO inc
2330 Clayton Rd., Suite B
San Mateo, California 94403-3008
Tel: 925.880.6862
Fax: 925.880.4346
www.cmds-st.com
PROJECT # 2108.00

CIA/NFICHI
ARCHITECTURE • PLANNING
30 ANNE COURT
WALNUT CREEK, CA 94598
TEL: (925) 256-8638
FAX: (925) 256-8652

PROJECT:
**CHILD DEVELOPMENT CENTER
CAÑADA COLLEGE**

4200 FARM HILL BLVD.
REDWOOD CITY, CA 94061

SAN MATEO COUNTY COMMUNITY COLLEGE DISTRICT

STAMP:
IDENTIFICATION STAMP
DIVISION OF THE STATE ARCHITECT
DATE: 10/25/29
APPL. NUMBER: 57421
KEY PLAN:

SHEET TITLE:
**SITE PLAN AND
GENERAL NOTES**

DRAWN BY:	PROJECT NO.:
CHECKED BY:	DATE:
APPL. NO.:	SHEET:
DATA NO.:	NO. OF:

M1.0

05/08/01 2:46:44 PM P:\C:\2000\2108-1.00\DRAWINGS\2108M1.0.DWG