

BCA
 ARCHITECTS
 400 FARM HILL BOULEVARD
 RIVERSIDE, CA 92504
 TEL: (951) 514-1100
 FAX: (951) 514-1101
 FILE NO. 43-C1 APPL. 01-110074

PARTIAL MECHANICAL DUCTWORK PLAN - THIRD FLOOR
 CANADA COLLEGE - BUILDINGS 5 & 6 RENOVATIONS
 RFI 0173 MSK-02


INTERFACETECH
 111 Market Street
 San Francisco, CA 94102
 TEL: (415) 398-1100
 FAX: (415) 398-1101
 FILE NO. 43-C1 APPL. 01-110074

Date: 08/18/10
 Scale: 1/8" = 1'-0"

Revision: 02
 MSK-02

RFI-173

Hand delivered from Peibuss (west-side 2nd floor to ASM)
 void 8/18/10. MSK RFI 175

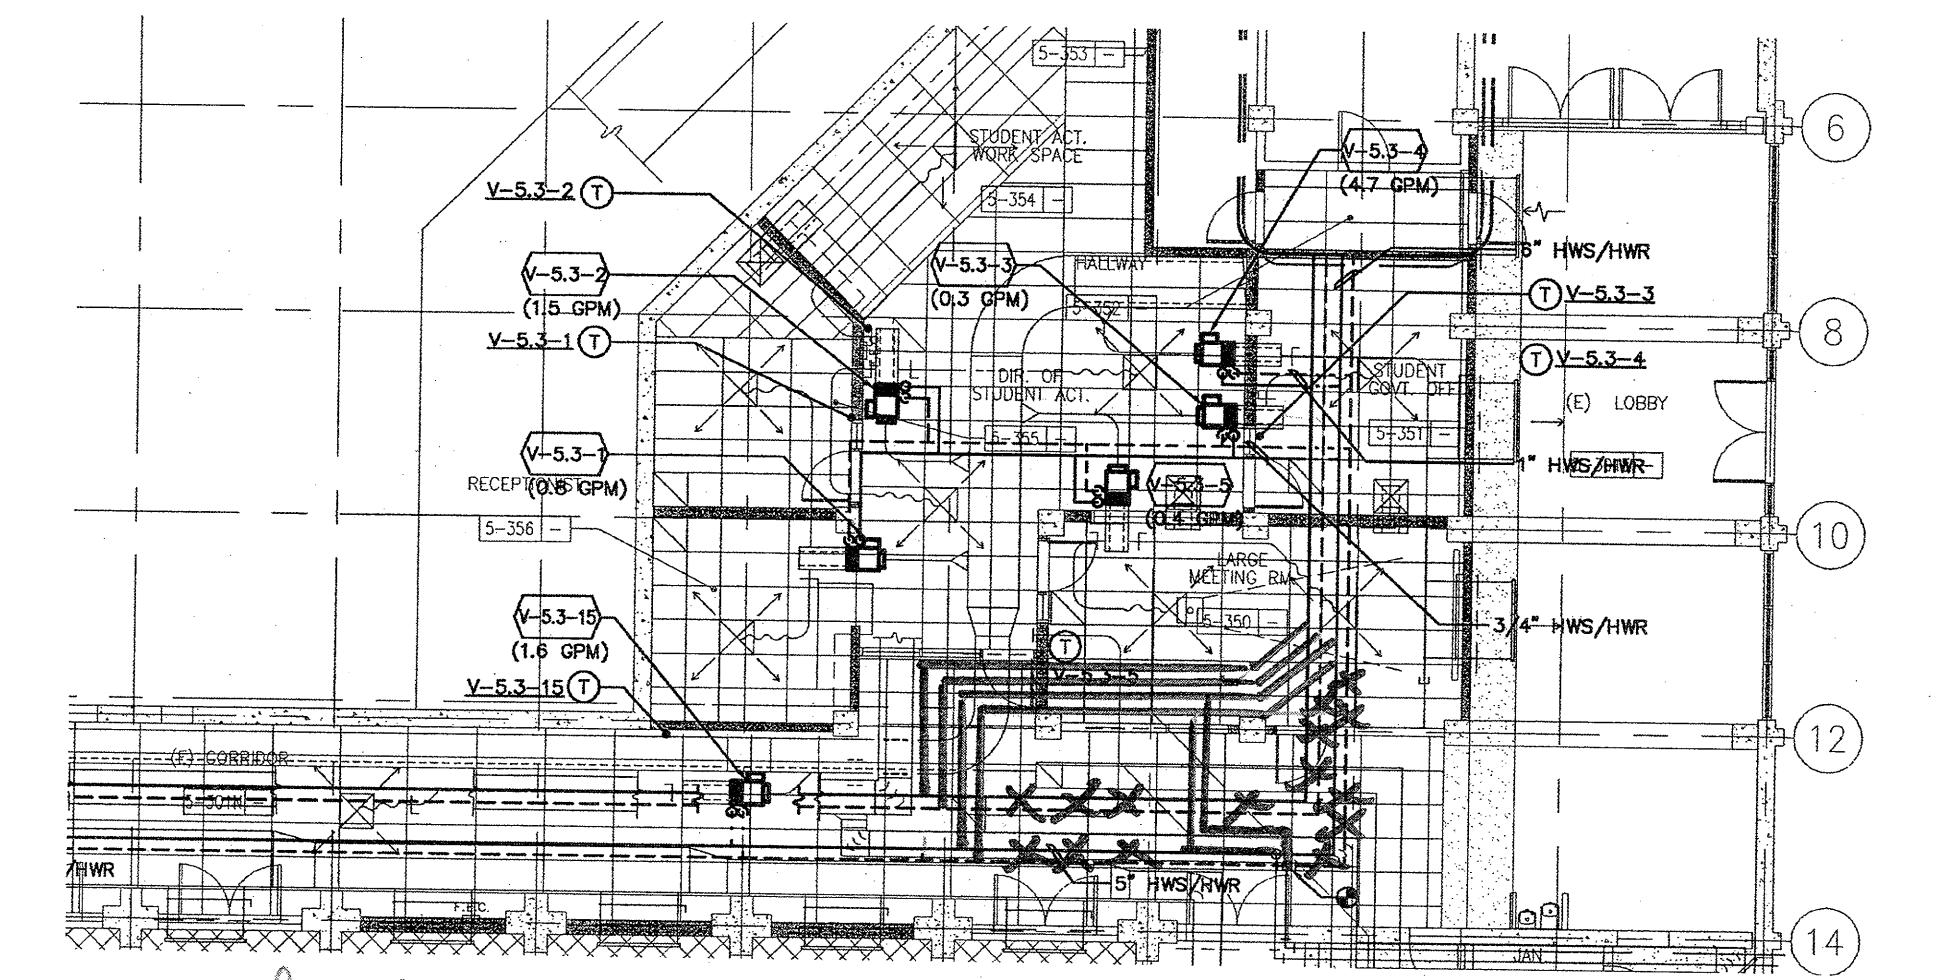

Reroute of HWS (HWR, CHWS/CHWR main's
 to maintain 9'0" ceiling height in Corridor 5-301N
 Peibuss 8-18-10 Sketch PRI#001