

REVISIONS	REMARKS	DATE
1	ADDENDUM NO. 1	08/18/08
2	ADDENDUM NO. 2	11/06/08

DRAWING STATUS	DATE
DESIGN PLAN CHECK	08/28/08
DESIGN BACK CHECK	01/22/09
BIDDING (BID #88693)	08/18/08
CONSTRUCTION	

FILE NO. 41-C1

IDENTIFICATION STAMP
DIV. OF THE STATE ARCHITECT

01-110074

AC _____ FLS _____ SS _____

DATE _____

BUILDINGS 5 & 6 RENOVATIONS

San Mateo County Community College District

BID ADDENDA


APPROVED
DIV. OF THE STATE ARCHITECT
AC *JA* FLS *GBSS* JS
DATE *11/27/08* DASH *JA*

CAÑADA COLLEGE
4200 Farm Hill Boulevard
Redwood City, CA 94061

ENLARGED MECHANICAL
DUCTWORK PLAN

Date 08/29/08
Scale AS NOTED
Project Number 07013


Drawing Number **M3.3**

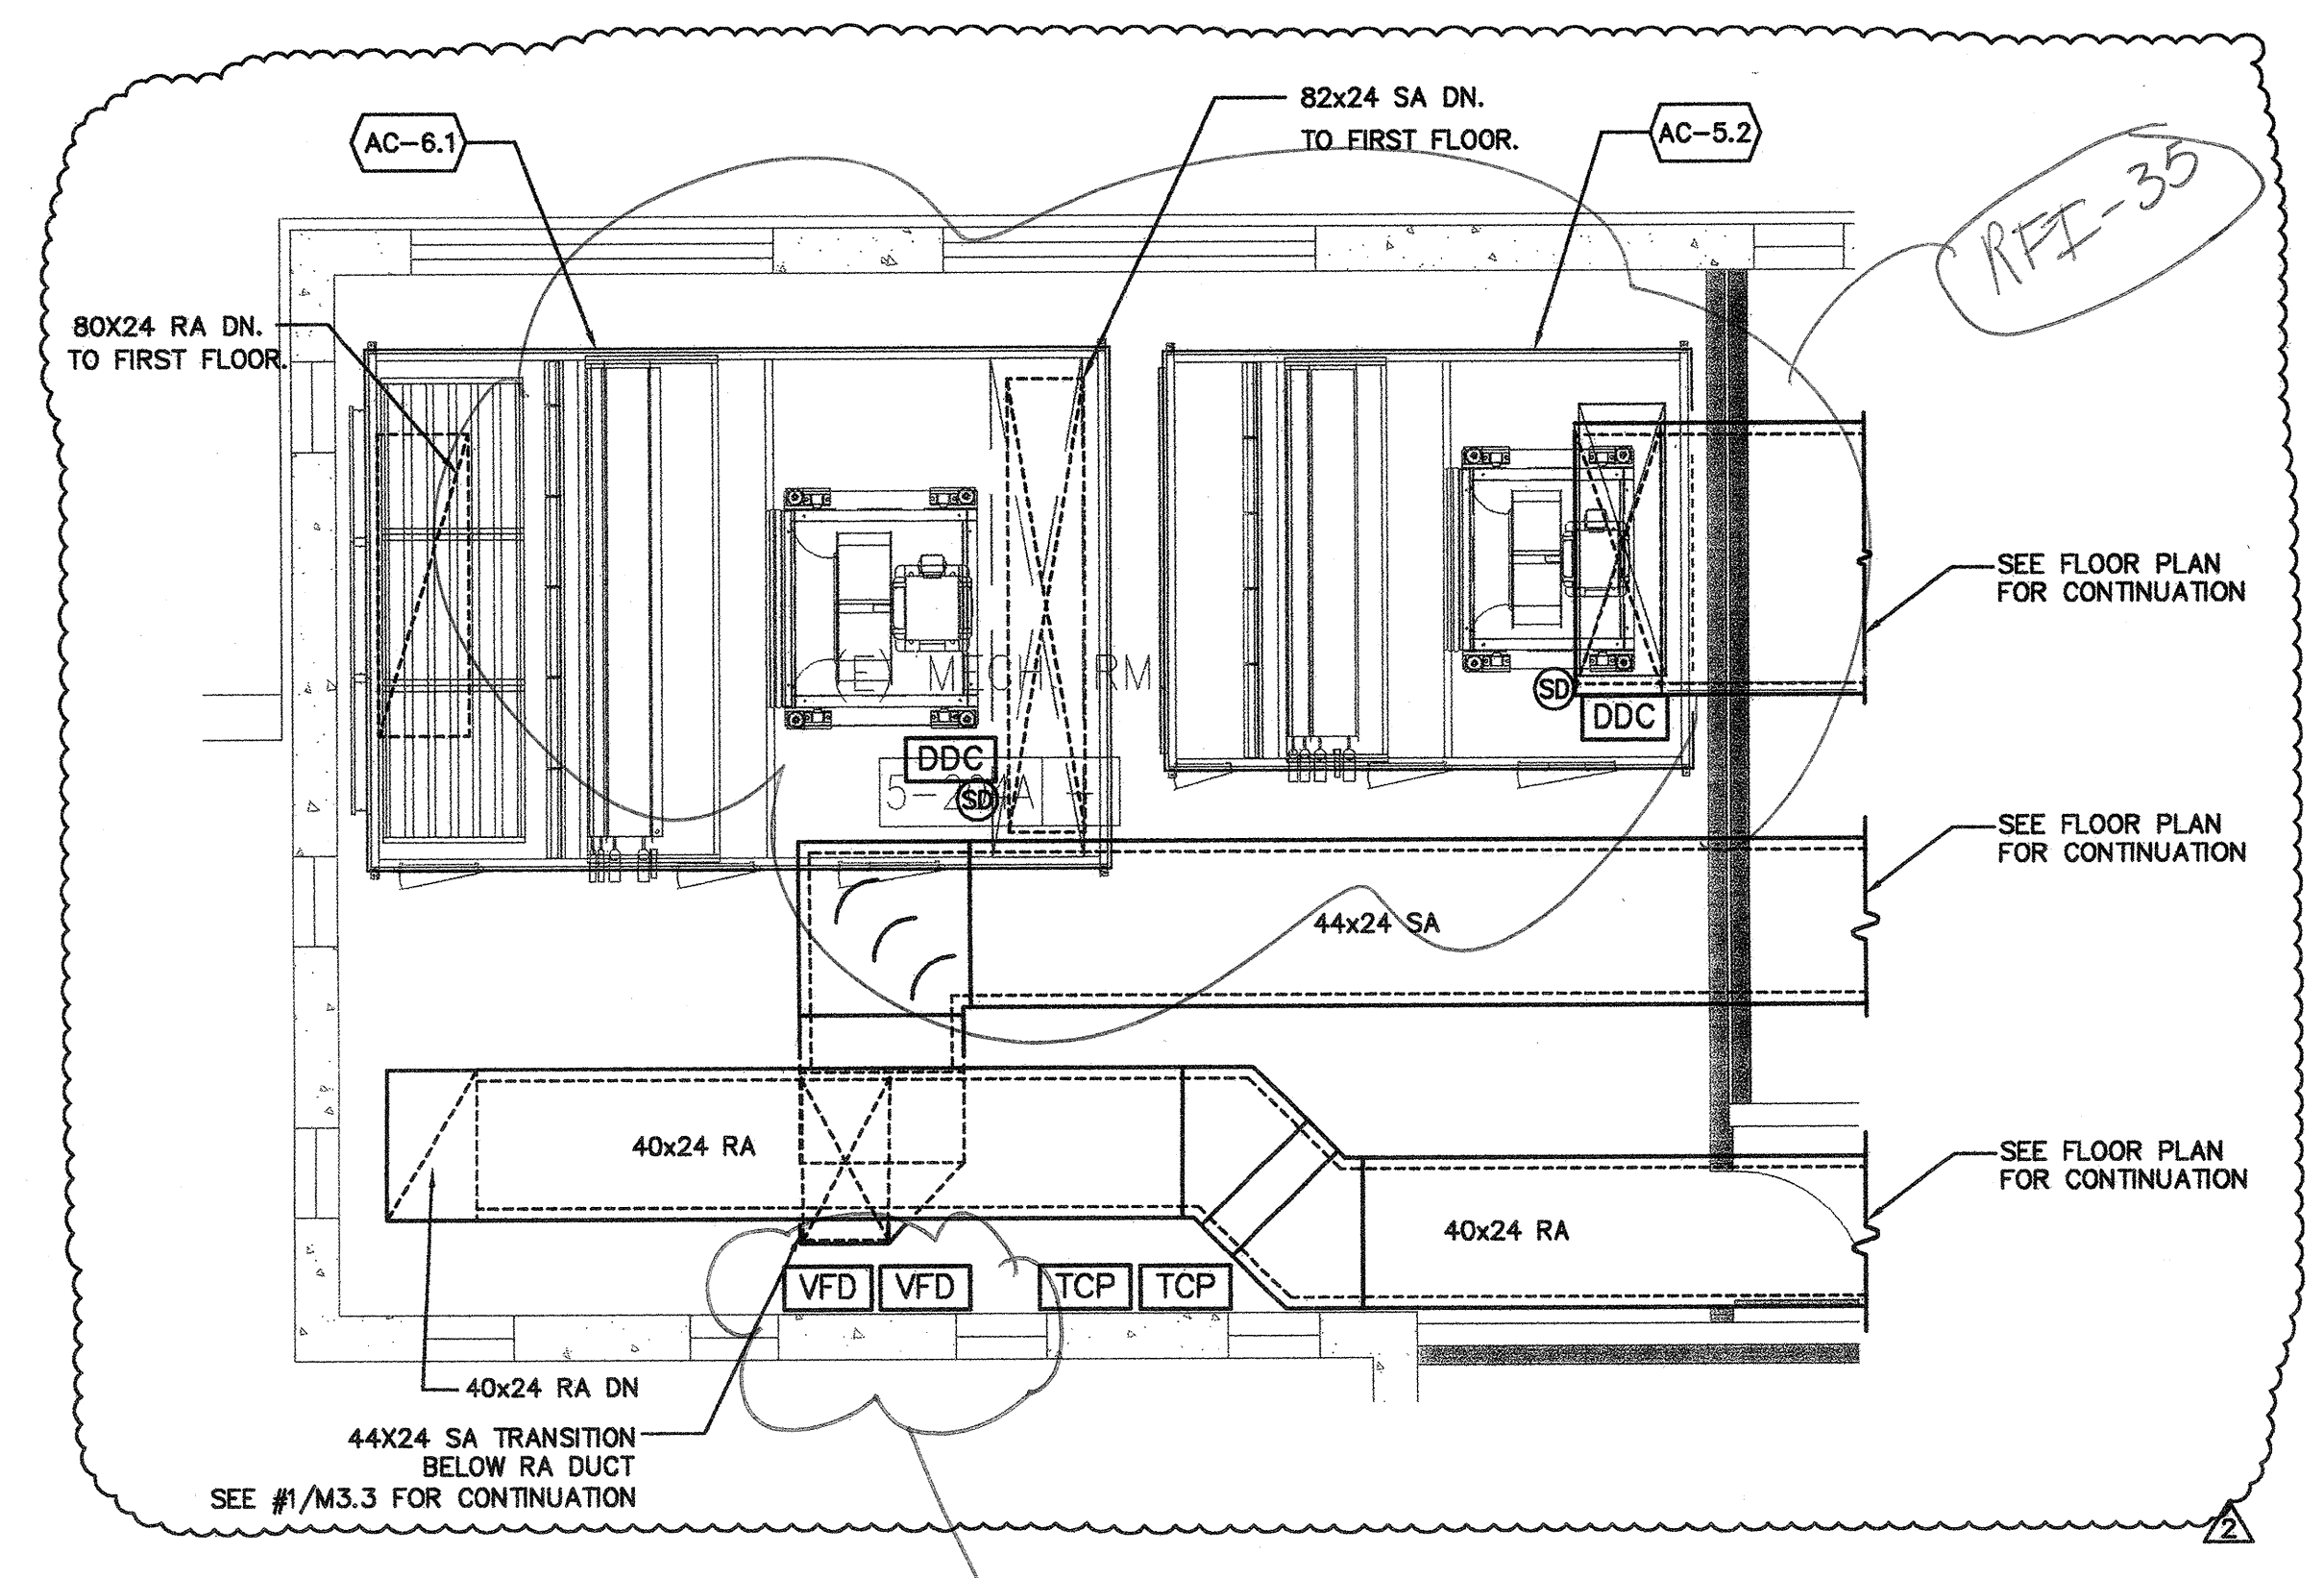

2 ENLARGED MECHANICAL DUCTWORK PLAN - SECOND FLOOR


SCALE: 1/4"=1'-0"

RFI-278
ATTN 6.1 VFD'S

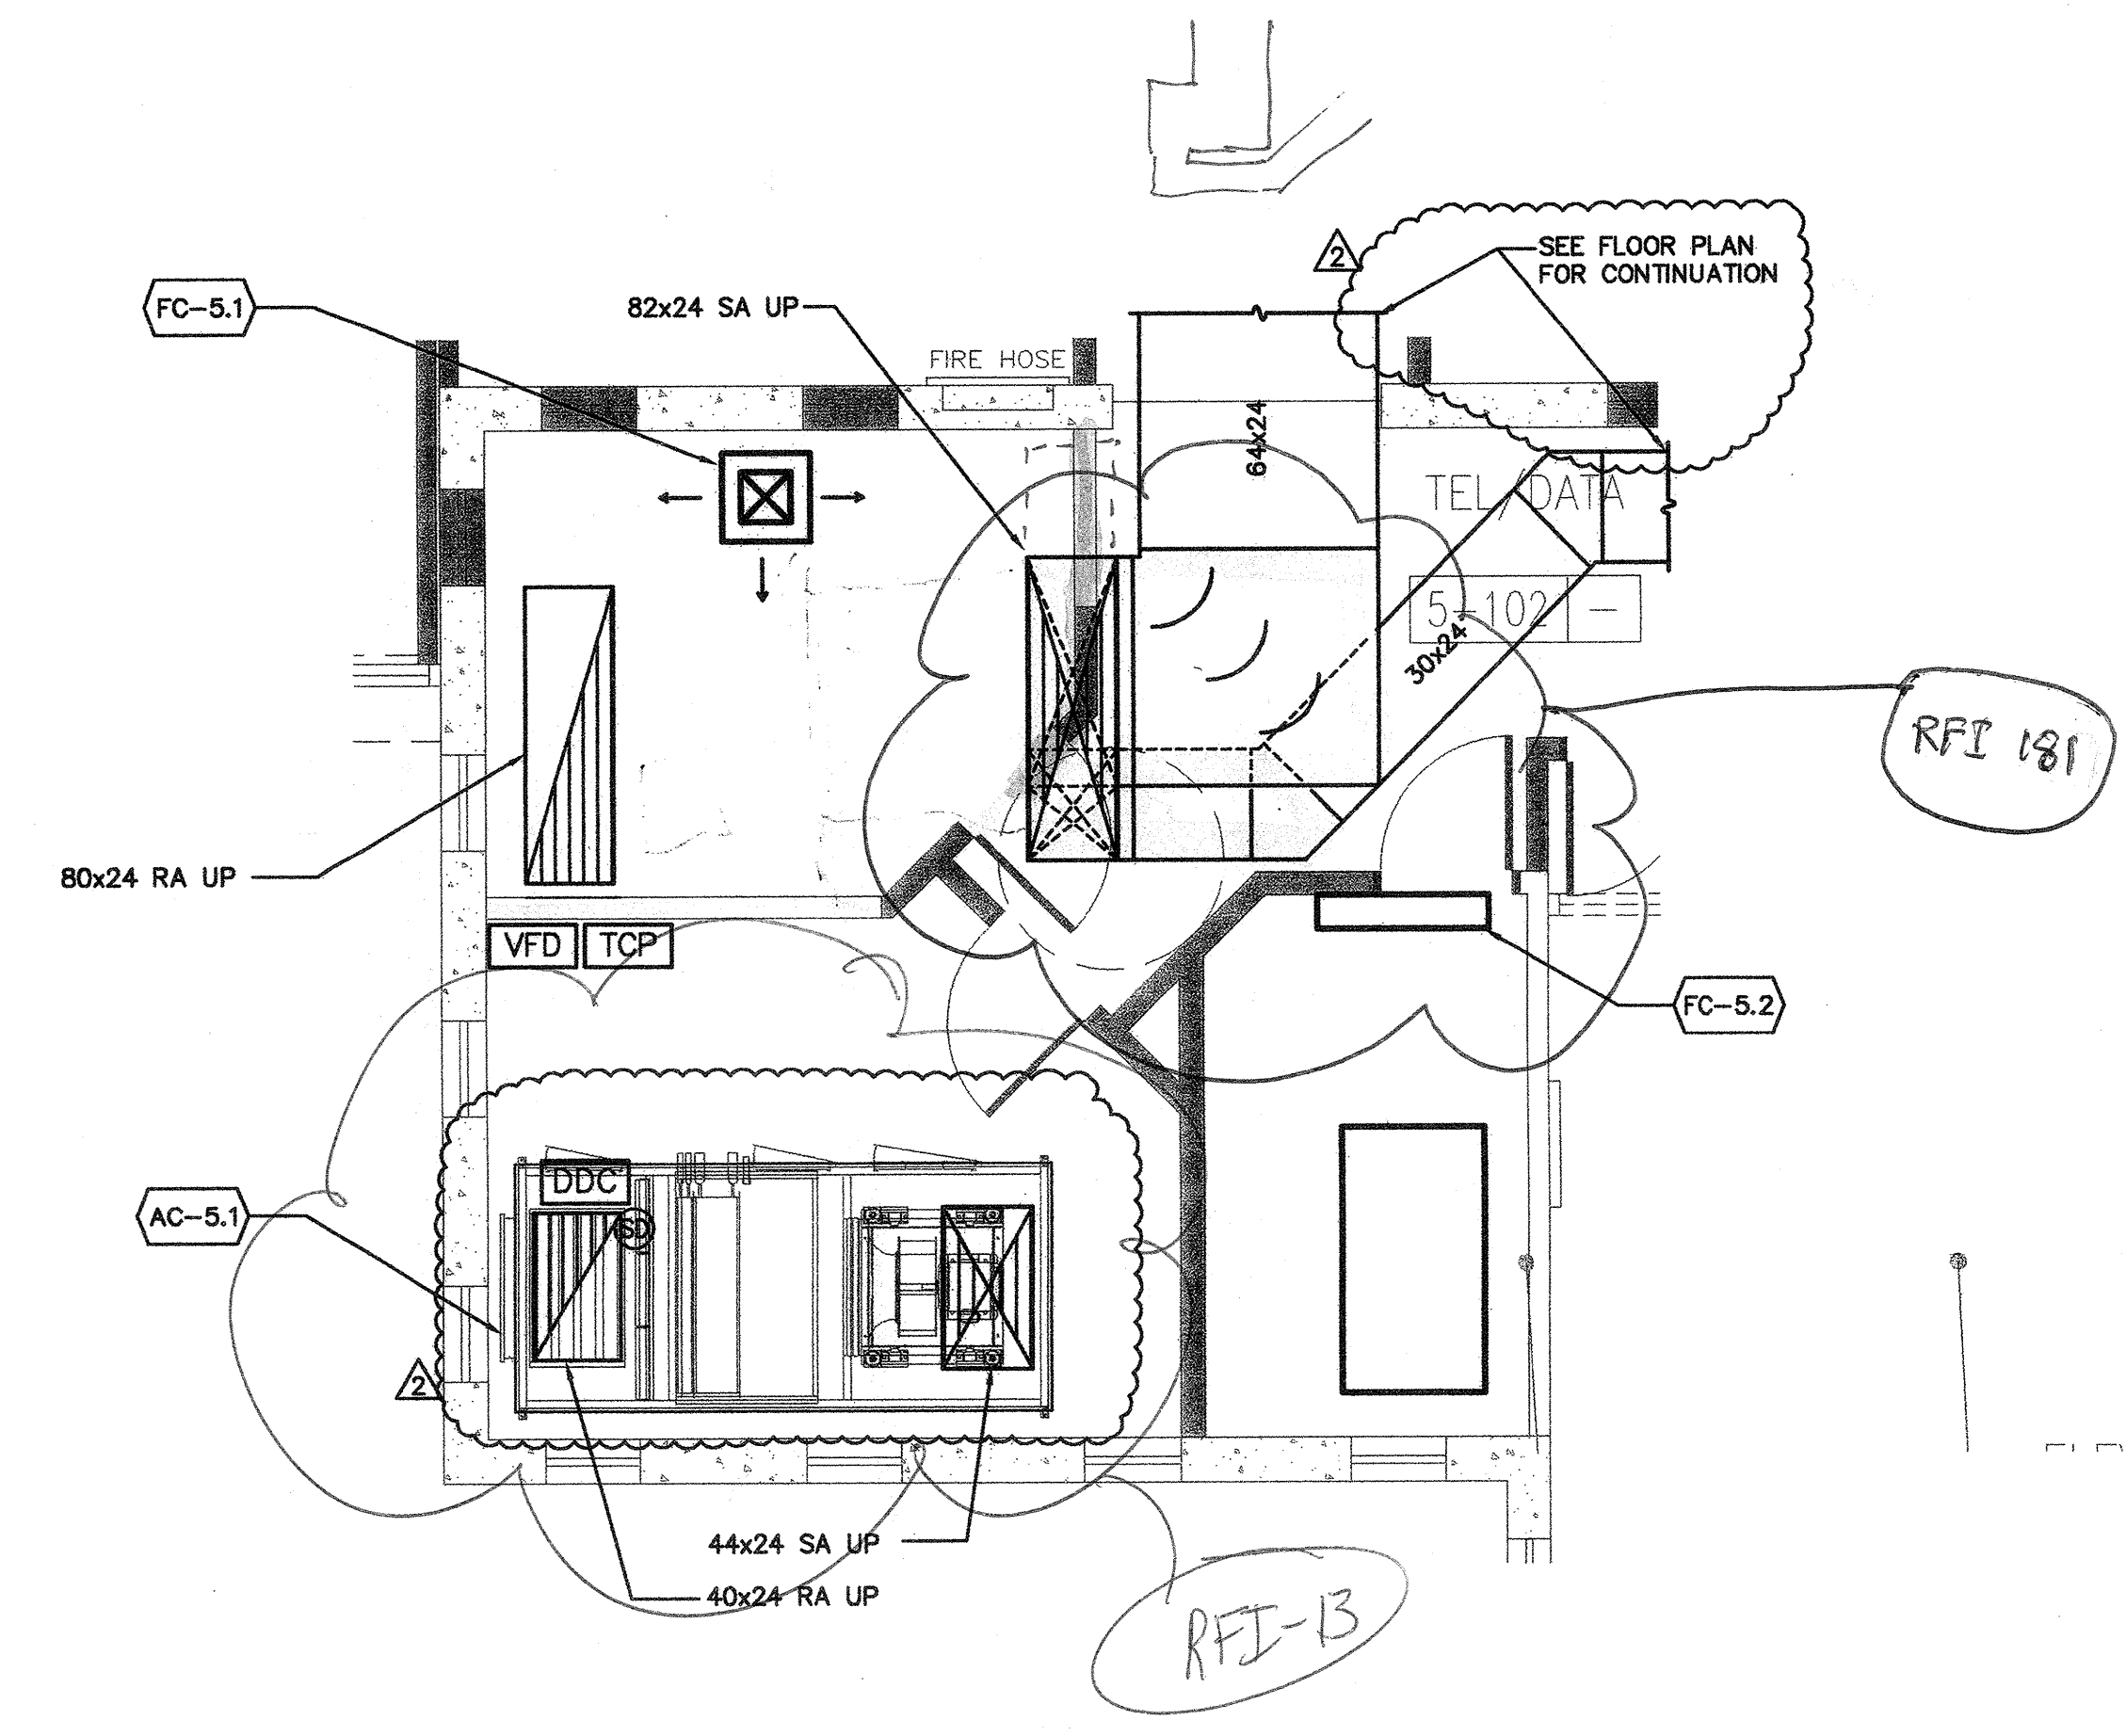

1 ENLARGED MECHANICAL DUCTWORK PLAN - FIRST FLOOR

SCALE: 1/4"=1'-0"

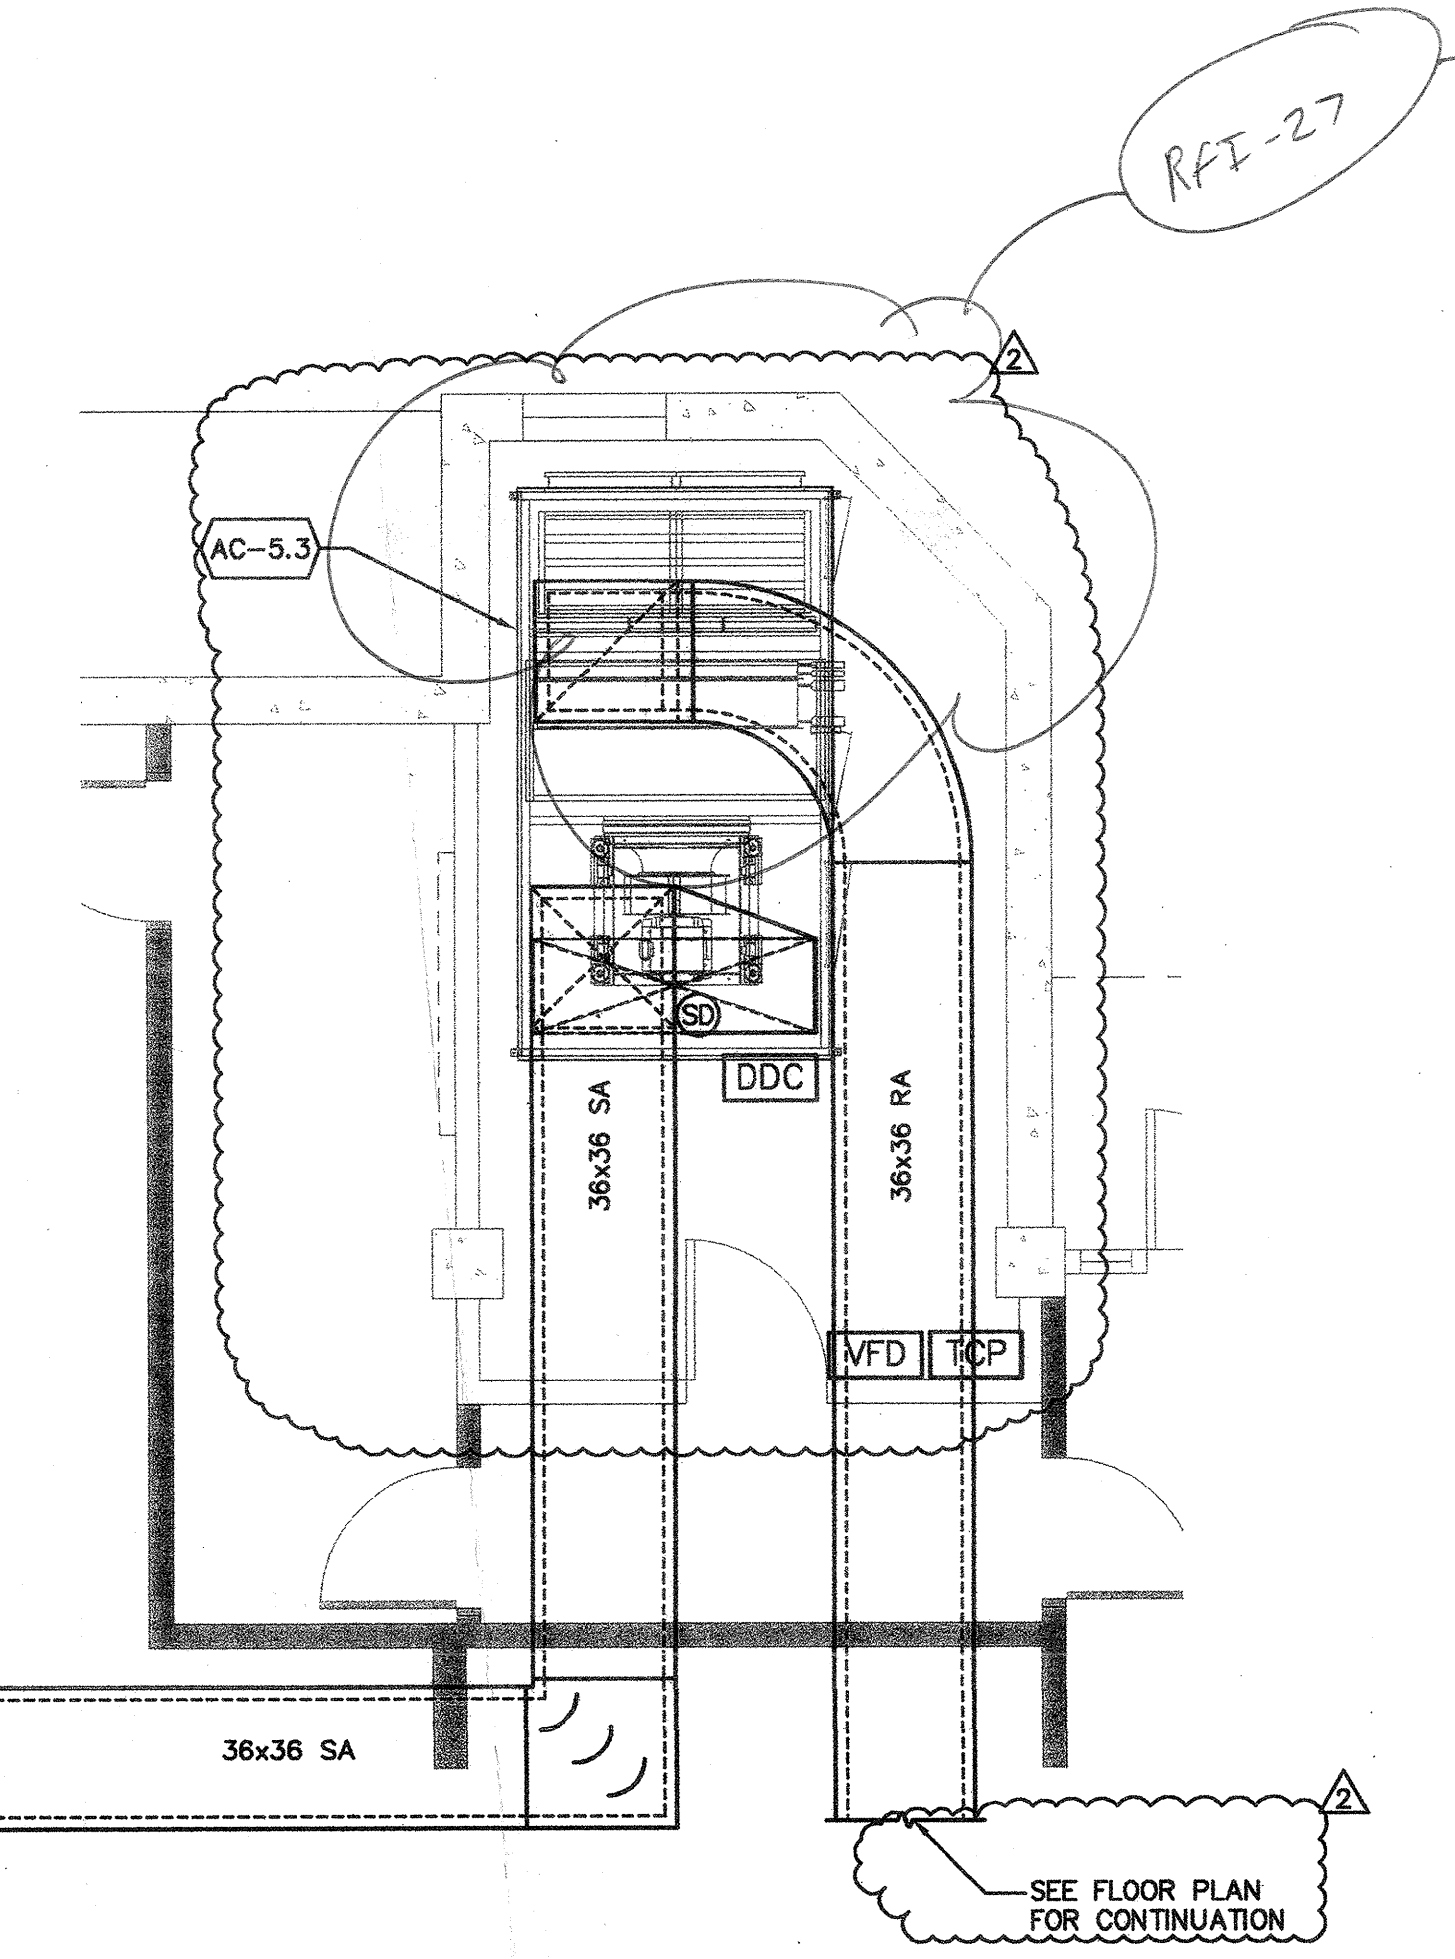

3 ENLARGED MECHANICAL DUCTWORK PLAN - THIRD FLOOR

SCALE: 1/4"=1'-0"