



1ST LEVEL - SWIMMING POOL
SCALE: 1/8" = 1'0"

2ND LEVEL - SWIMMING POOL
SCALE: 1/8" = 1'0"

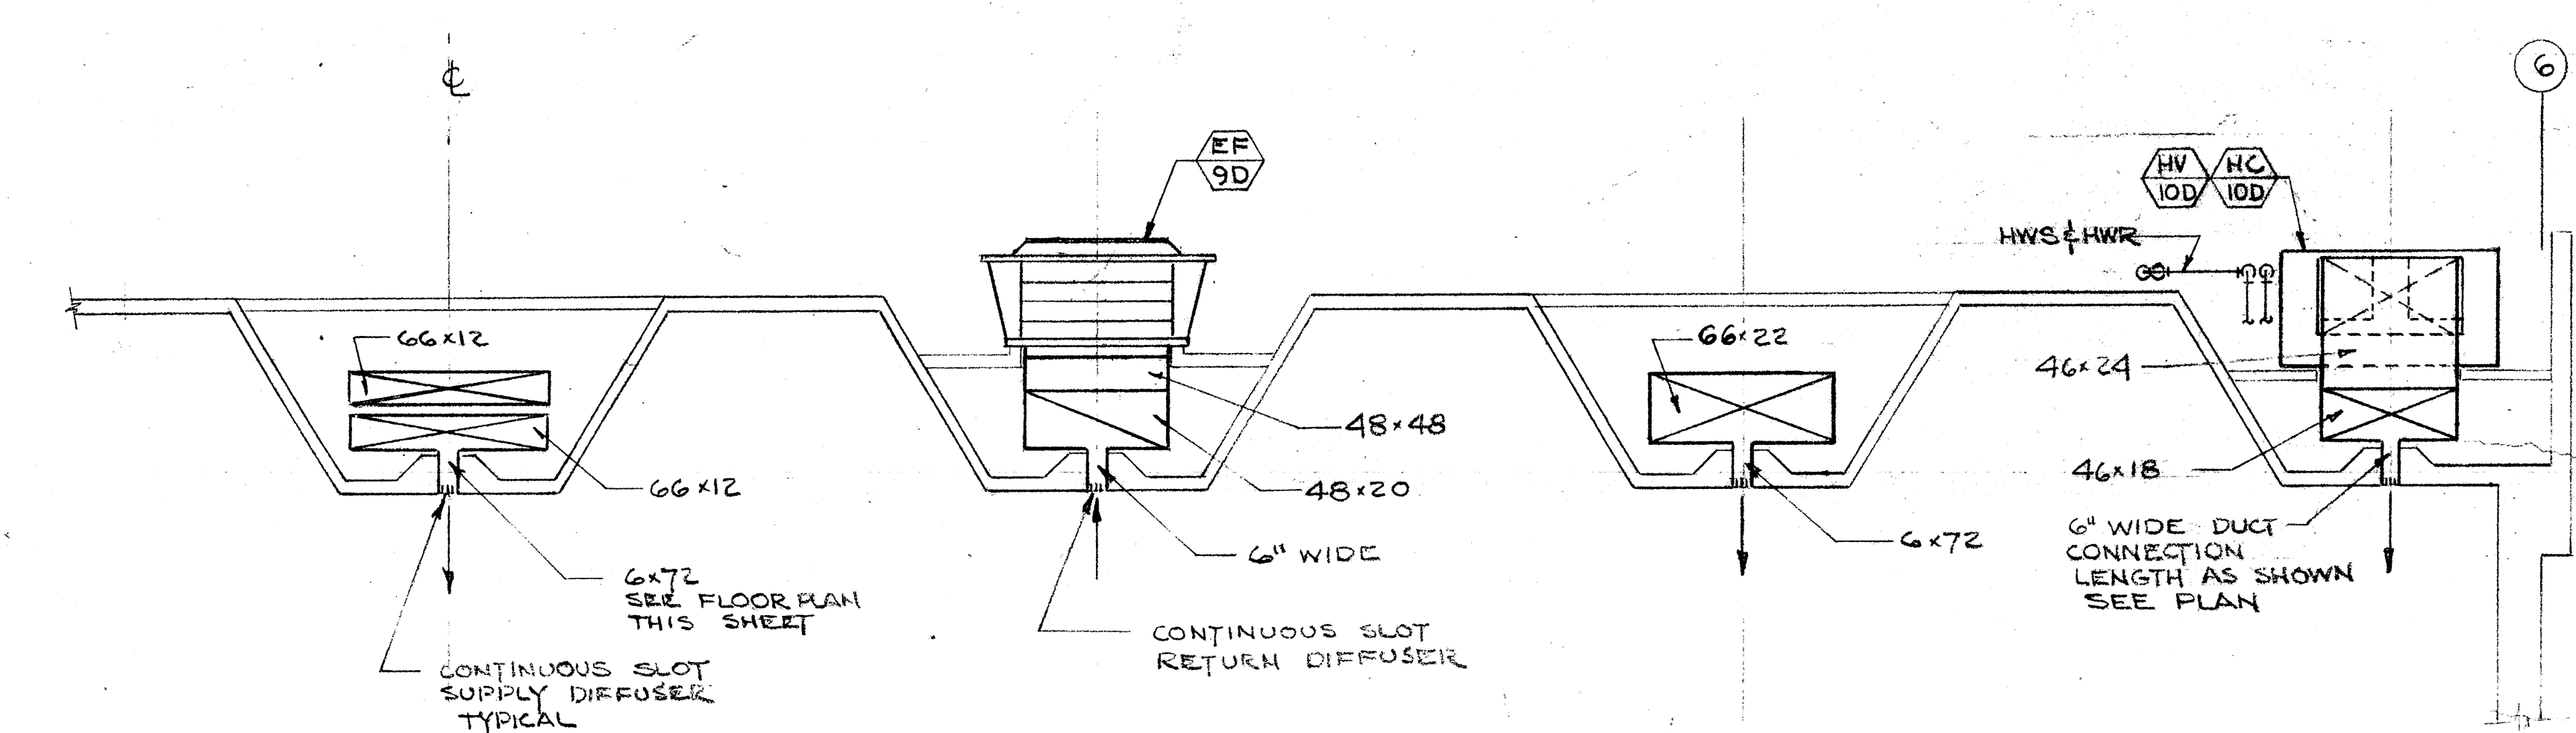

SECTION
SCALE: 1/4" = 1'0"

ROOF-PART PLAN
SCALE: 1/8" = 1'0"

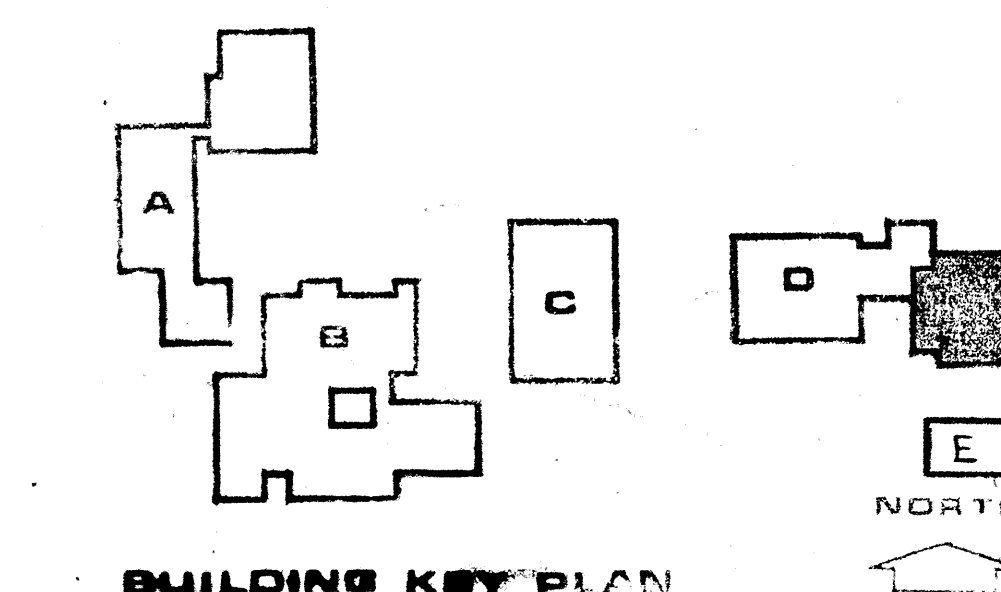

JOHN CARL WARNECKE & ASSOCIATES
ARCHITECTS AND PLANNING CONSULTANTS
61 NEW MONTGOMERY STREET SAN FRANCISCO

LEONARD THOMPSON
STRUCTURAL ENGINEER
M. CARLE KIRKER
MECH. & ELEC. ENGINEERS
CIVIL ENGINEERS

BUILDING D
PHYSICAL EDUCATION
MECHANICAL FLOOR PLANS
COLLEGE OF SAN MATEO
SAN BRUNO CALIFORNIA

SCALE AS SHOWN	DATE	REVISION DESCRIPTION	NO.	DATE	APPROVED
JOB NO. G4-15	DATE FEB. 10, 1967				
D.B. L.F.					
CHECK BY G.R.K.					
SHEET NUMBER	M-133				
OF 3 SHEETS	REVISION NO.				