



NO.	ISSUES/REVISIONS	DATE
	100% SCHEMATIC DESIGN	04/28/06
	50% DESIGN DEVELOPMENT	06/13/06
	100% DESIGN DEVELOPMENT	07/28/06
	INCREMENT 2 80% REVIEW	10/10/06
	DSA INCREMENT 2	
7	STRUCTURE & GFRG PANELS	11/11/06
	DSA INCREMENT #3 50% REVIEW	11/11/06
9	DSA INCREMENT #3 80% REVIEW	12/15/06
10	DSA INCREMENT #3	
	TENANT IMPROVEMENT AND ROOFING SYSTEM	02/09/09
12	HPCO REVIEW	04/30/09
	DSA INCREMENT #3 BACKCHECK	05/12/09
14	ISSUED FOR CONSTRUCTION	10/27/09
	AS-BUILT DRAWINGS	04/06/11
	AS-BUILT DRAWINGS	06/10/11
	AS-BUILT DRAWINGS	06/29/11

DIVISION OF THE STATE ARCHITECT
APPL # 01-110117
FILE # 41-C1
AC _____ FLS _____
SSS _____ DATE _____
IDENTIFICATION STAMP

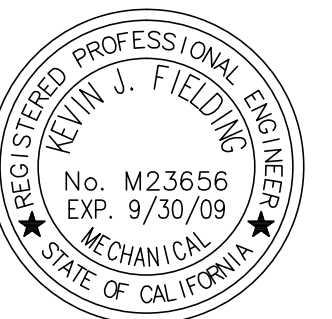

SKYLINE COLLEGE
SAN MATEO COUNTY
COMMUNITY COLLEGE
DISTRICT
**CIP2 DESIGN-BUILD
PROJECT
BUILDING 4
INCREMENT 3**

KEY PLAN
CMT PROJECT NO: 28212 DRAWN BY:
DATE: 1-29-09 CHECKED BY:
SCALE: 0 4' 8' 12' 16' 24' 32'
SHEET TITLE:
**THIRD FLOOR
DOMESTIC
WATER AND
NATURAL GAS
PLUMBING PLAN**
SHEET NO: **P-103**

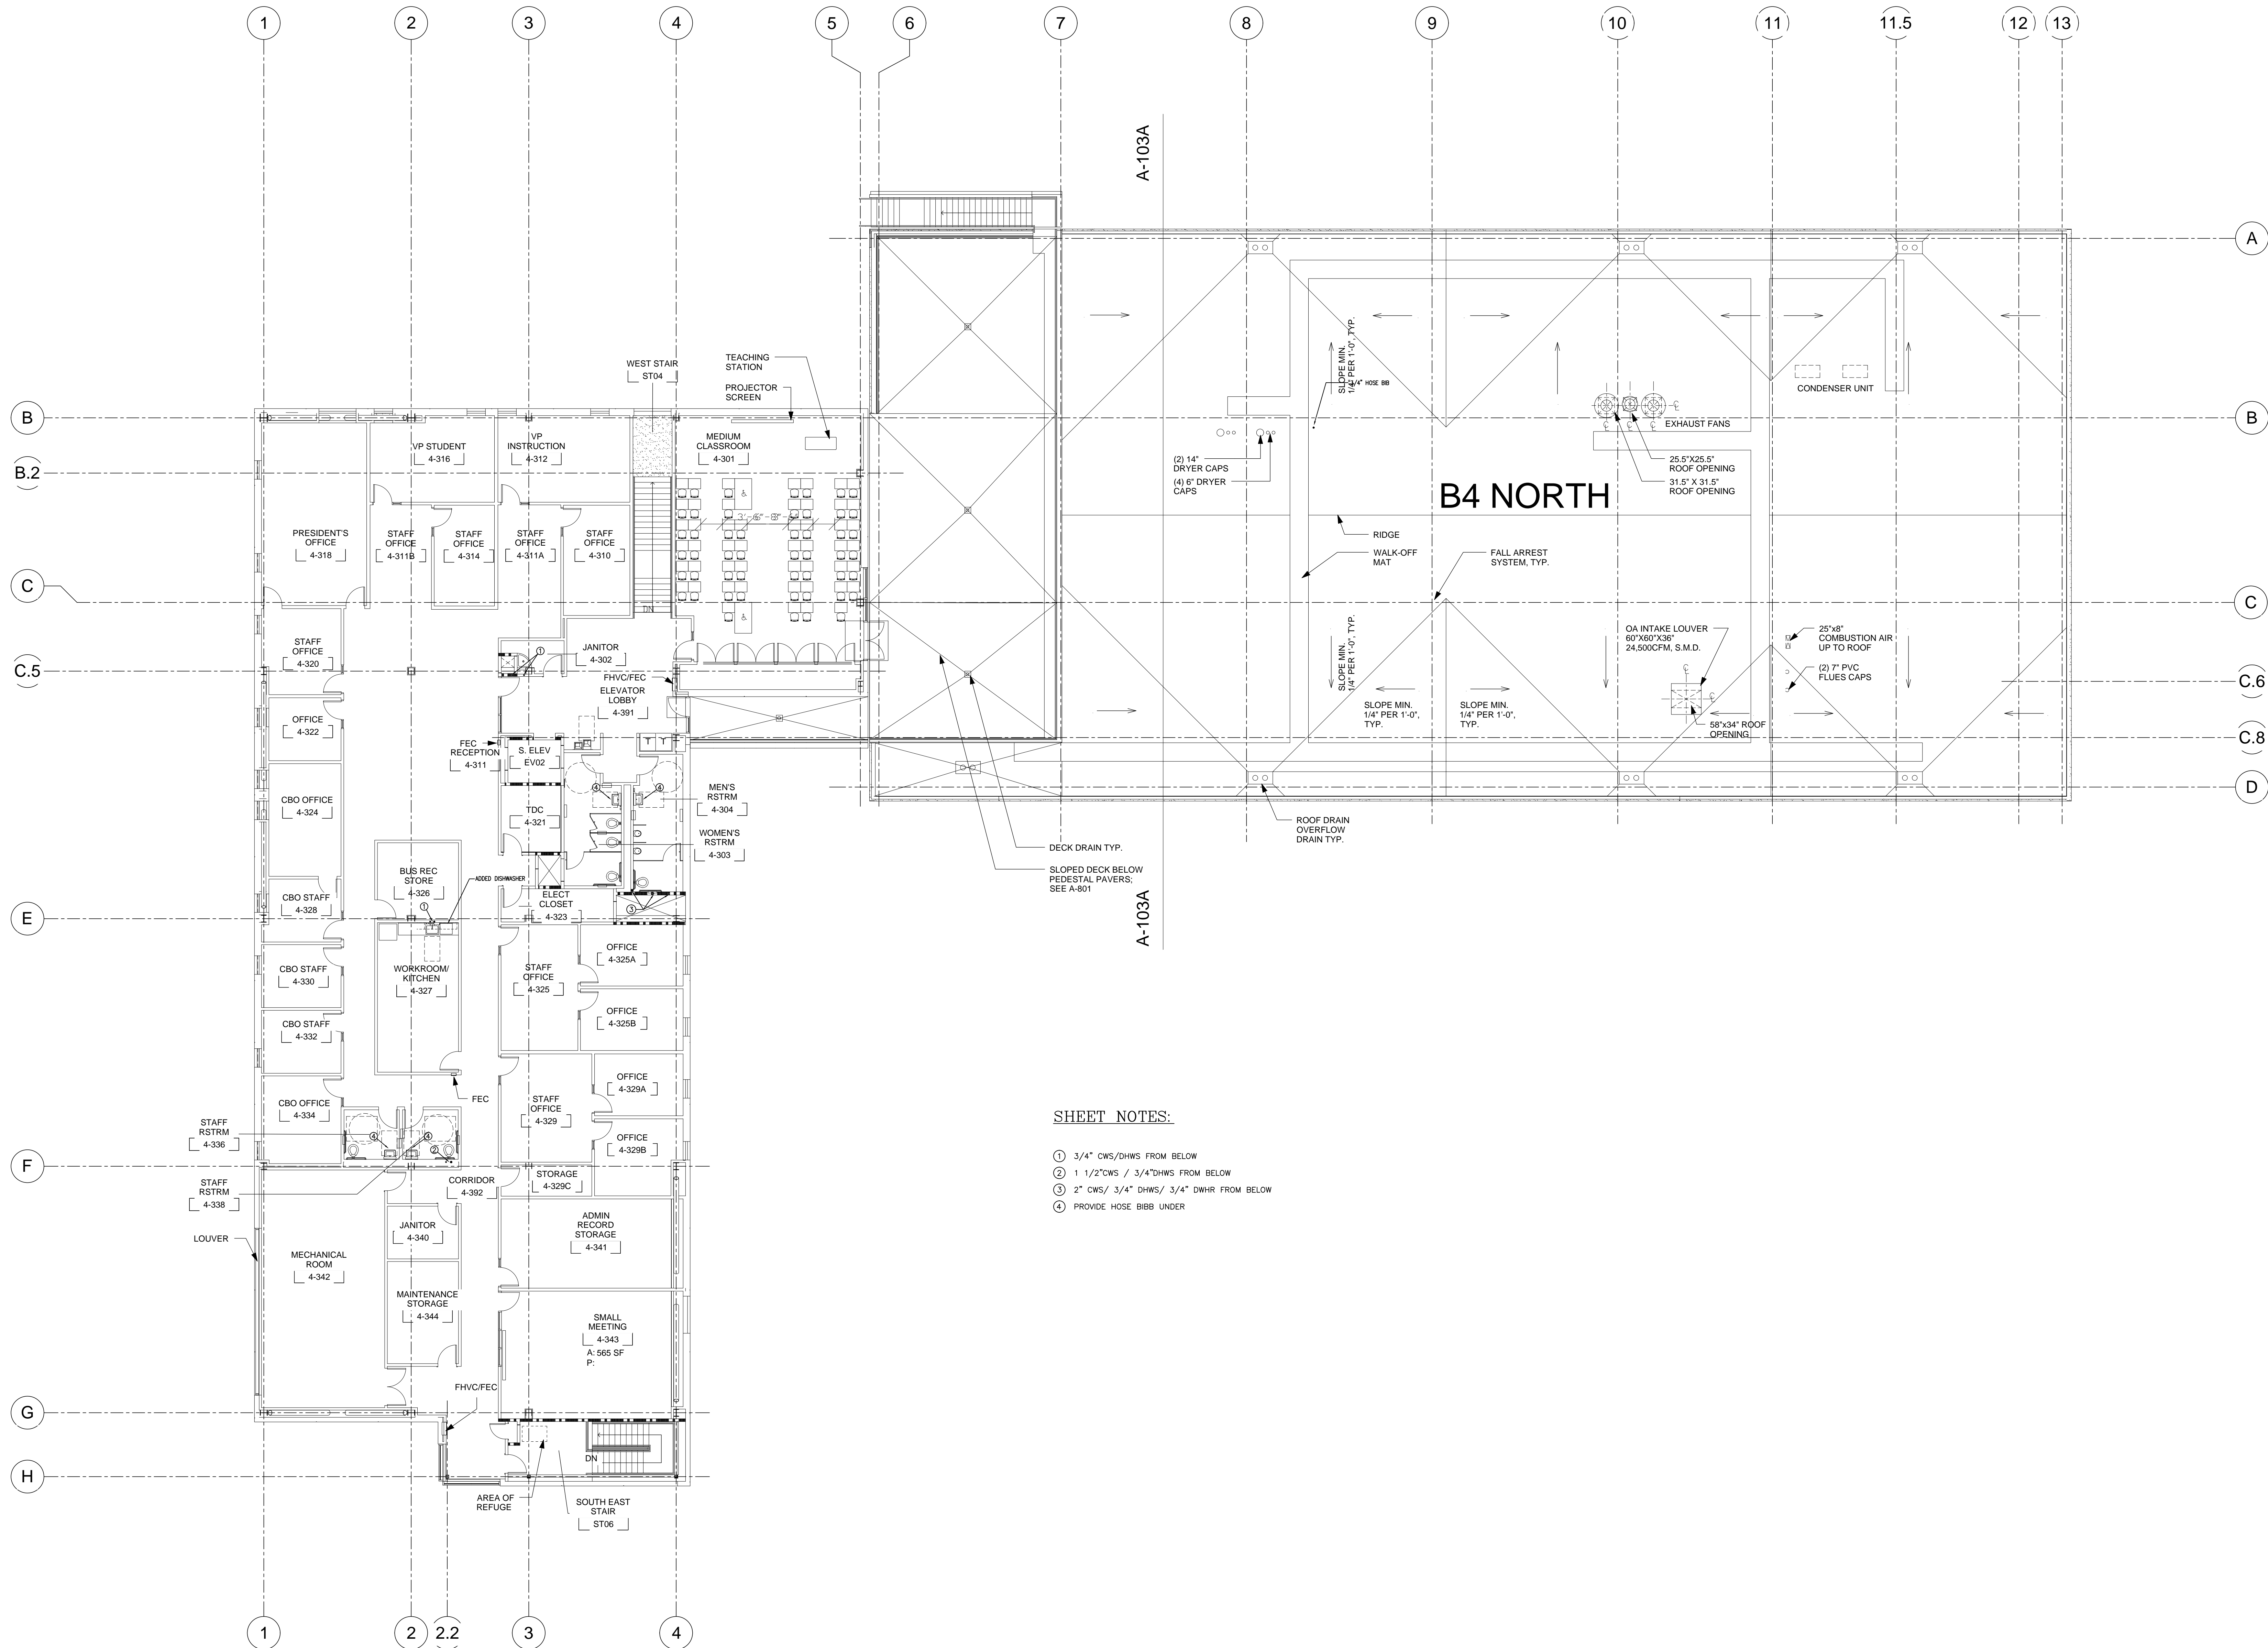

SHEET NOTES:

- ① 3/4" CWS/DHWS FROM BELOW
- ② 1 1/2" CWS / 3/4" DHWS FROM BELOW
- ③ 2" CWS/ 3/4" DHWS/ 3/4" DWHR FROM BELOW
- ④ PROVIDE HOSE BIBB UNDER