


SHEET NOTES


- ① 3" RWL-1 AND 3" OD-1.
- ② 4" RWL-1 AND 4" OD-1.
- ③ 2" DN. FROM GUTTER.
- ④ 1-1/2" VTR.
- ⑤ 2" VTR.
- ⑥ 2-1/2" VTR.

1 ROOF PLAN - PLUMBING
SCALE: 1/8" = 1'-0"

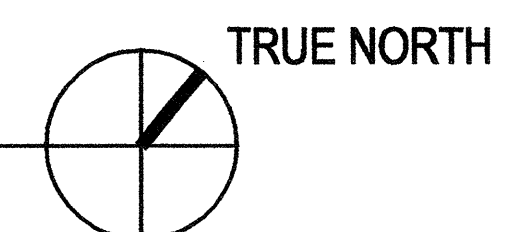

AS-BUILTS

NO.	DATE	REASON	BY
1	03/17/03	CHANGE REQUEST#19	DA

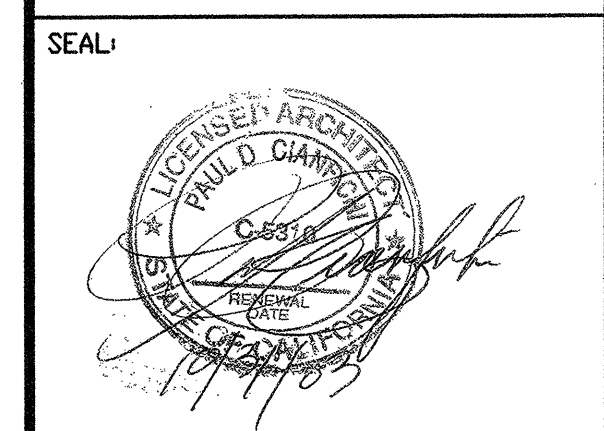

CONSULTANT:
MECHANICAL DESIGN STUDIO inc
1777 Oakland Blvd., Suite 210
Walnut Creek, California 94596
Tel: (925) 256-8638
Fax: (925) 256-8652
www.mds-st.com
PROJECT # 23018.00

ARCHITECT:
CIANFICHI
ARCHITECTURE · PLANNING
30 ANNE COURT
WALNUT CREEK, CA 94598
TEL: (925) 256-8638
FAX: (925) 256-8652

PROJECT:
**CHILD DEVELOPMENT CENTER
CANADA COLLEGE**

STAMP:

APPL. NUMBER:
KEY PLAN:

SHEET TITLE:
**ROOF PLAN-
PLUMBING**

DRAWN BY: J.W./K	PROJECT NO.: 304.99
CHECKED BY: DA	DATE: JULY 3, 2000
APPL. NO.:	SHEET: P1.2r
DATA NO.:	NO. OF:

03/19/03 2:07:07 PM P:\C:\2000\23018.00 CANADA COLLEGE - PROGRAM CHANGES\DRAWINGS\23018P12.DWG