

SHEET NOTES

- CONNECT NEW 4"SD TO EXISTING 5"SD BELOW GRADE. FIELD VERIFY ACTUAL SIZE, LOCATION AND INVERT ELEVATION OF EXISTING STORM DRAIN PIPING.

IDENTIFICATION STAMP
 DIVISION OF THE STATE ARCHITECT
 APPLICATION NUMBER 01-111618
 AC _____ FLS _____ BS _____
 DATE _____

CALIFORNIA STATE FIRE MARSHAL
 APPROVED
APPROVAL OF THIS PLAN DOES NOT AUTHORIZE OR APPROVE ANY
 CHANGE OR DEVIATION FROM APPLICABLE REGULATIONS. FINAL
 APPROVAL IS SUBJECT TO REGISTRATION. ONE SET OF APPROVED
 PLANS SHALL BE AVAILABLE ON THE PROJECT SITE AT ALL TIMES.
 REVIEWED BY: _____ DATE: _____

CAÑADA COLLEGE
 Electrical
 Infrastructure
 Replacement
 Project
 4200 Farm Hill Blvd
 Redwood City, CA 94061


RECORD SET

SHEET TITLE
**PLUMBING
 PARTIAL FLOOR
 PLANS - BLDG 3**

| REVISIONS | | |
|-----------|------|-------------|
| NO. | DATE | DESCRIPTION |
| | | |
| | | |
| | | |
| | | |

DATE June 15, 2012
 DRAWN **VT/AL**
 CHECKED **MW**
 SCALE **AS NOTED**
 JOB NO. 2921.01

SHEET NUMBER
P1.1

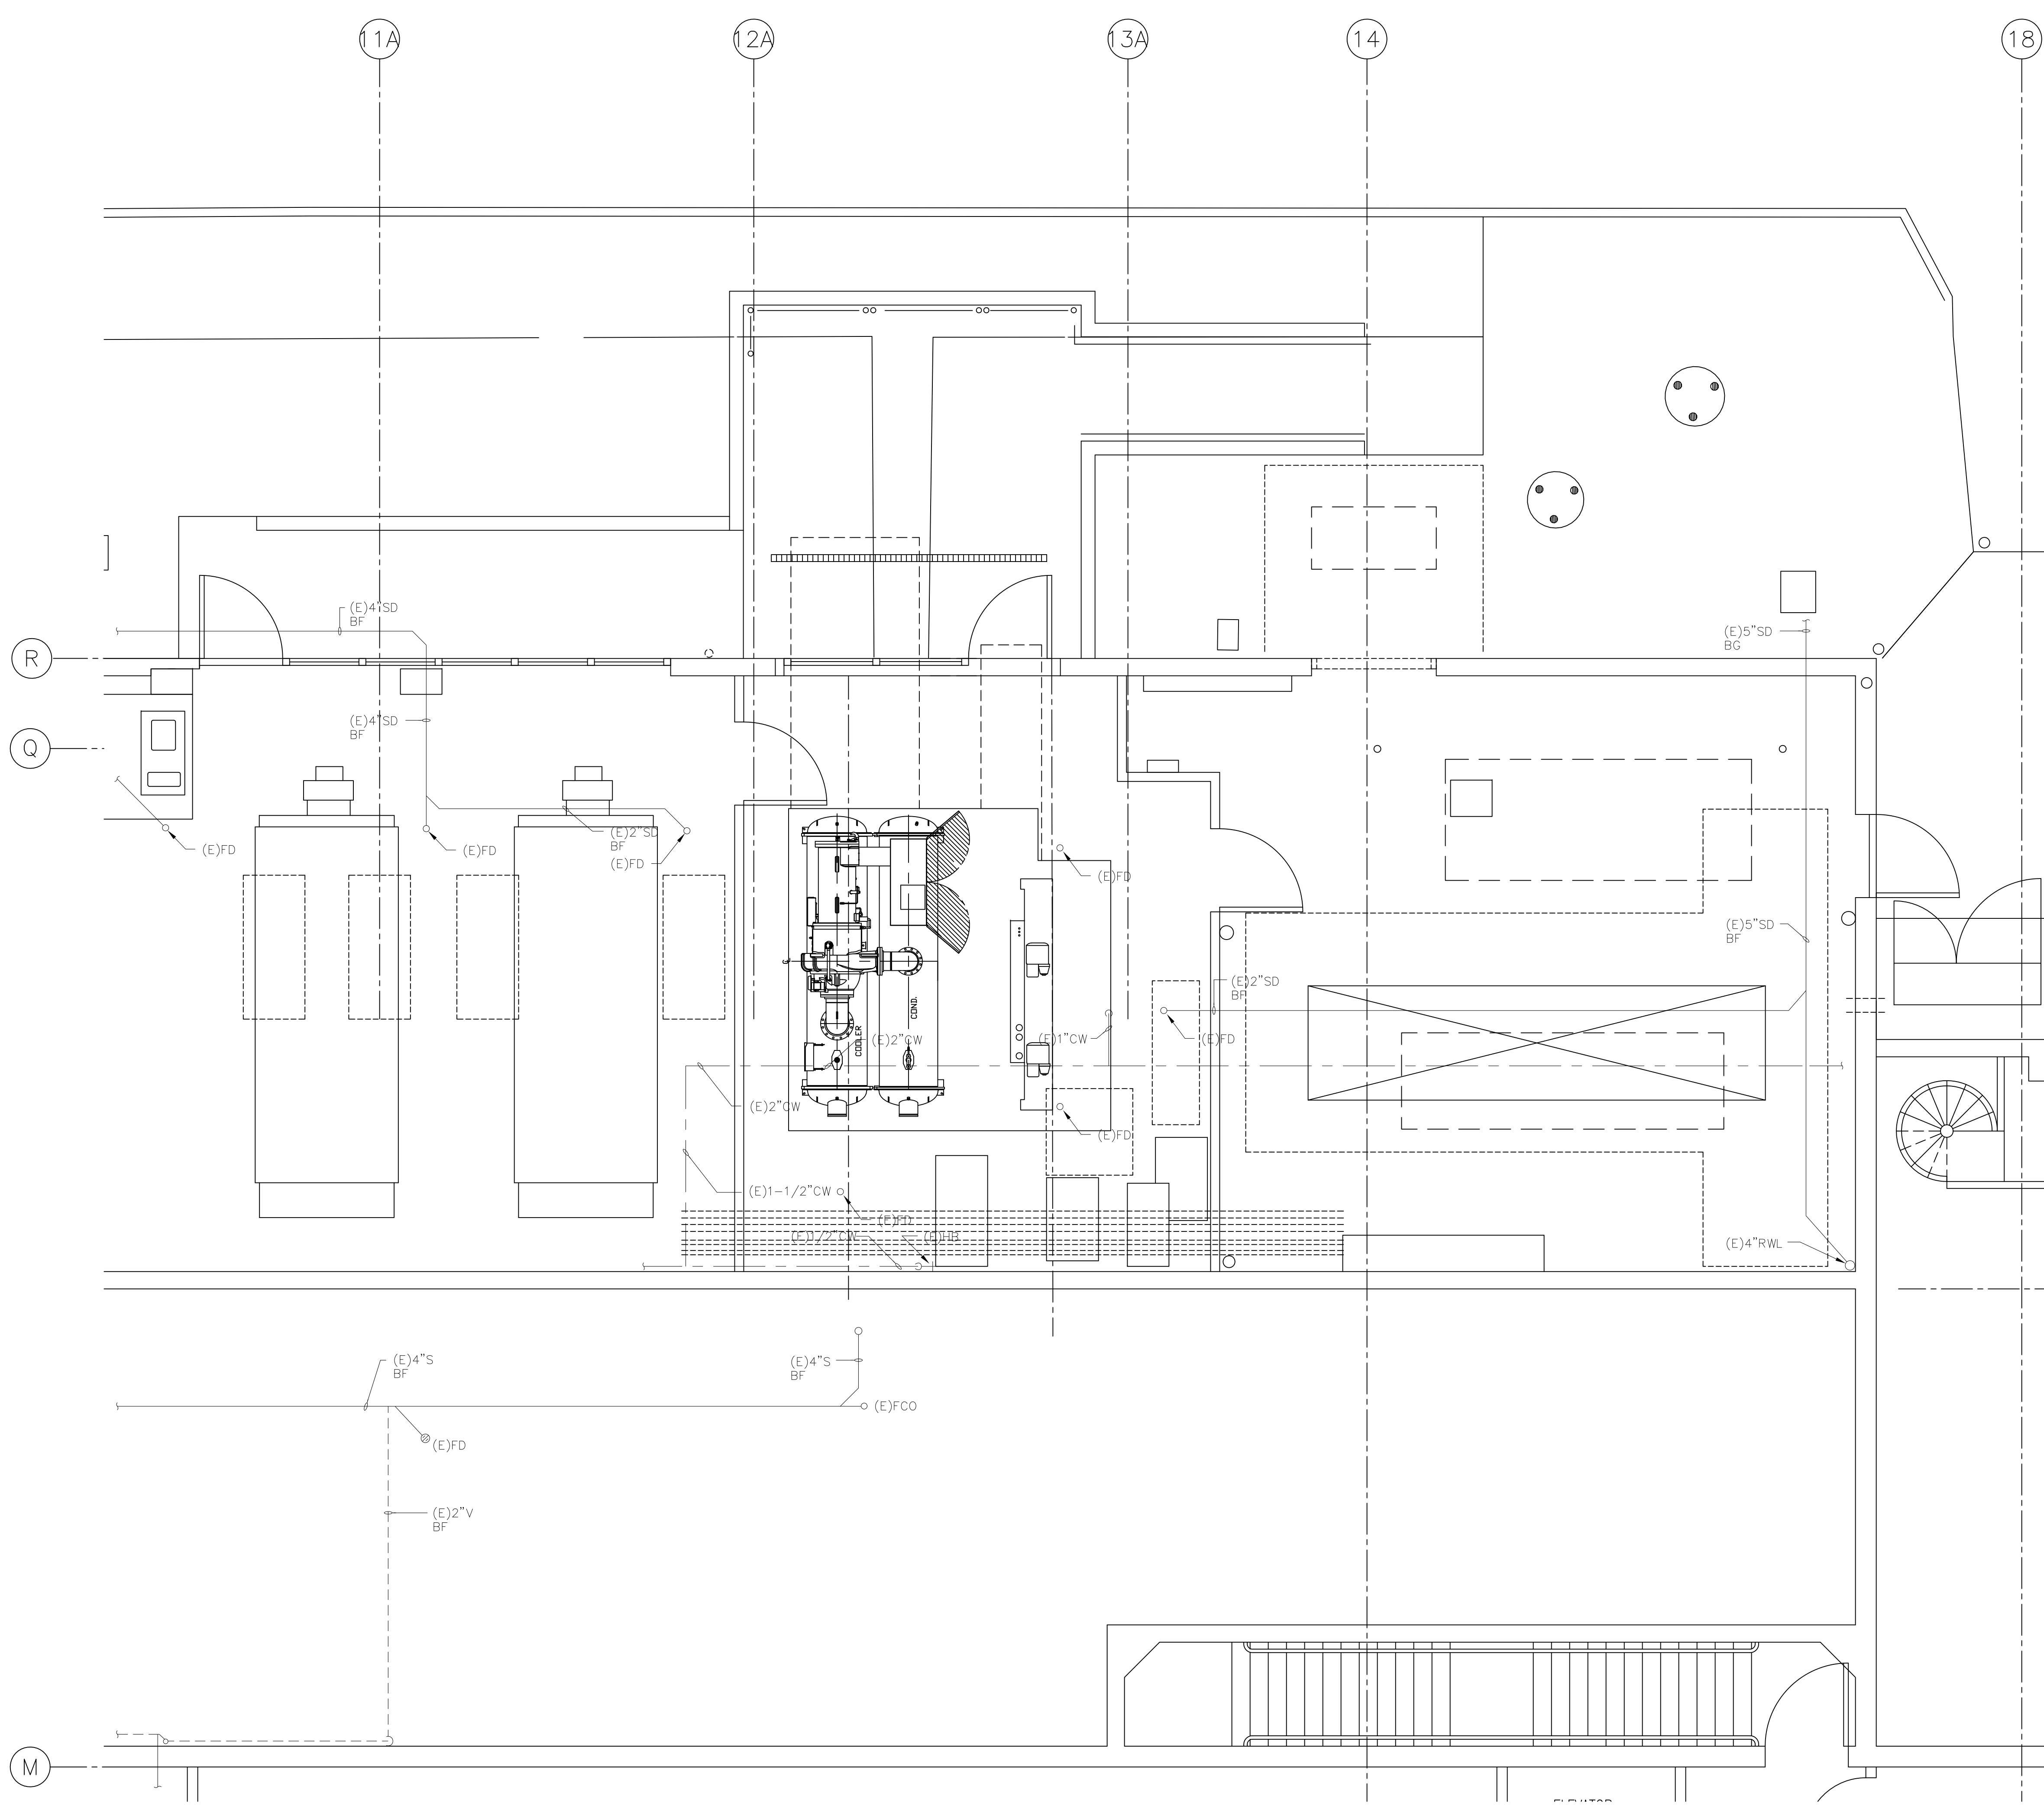

PLUMBING PARTIAL FLOOR PLAN – BLDG 3 LOAD CENTER #1
 SCALE: 1/4" = 1'-0"

