

SHEET KEYNOTES


- ① POINT OF CONNECTION, (N) WORK TO (E) WORK, FIELD VERIFY EXACT SIZE AND LOCATION OF (E) WORK PRIOR INSTALLING (N) WORK.
- ② 2" W DN FROM ABOVE & 1/2" CW UP.
- ③ W DN FROM ABOVE.
- ④ PIPING ABOVE FINISHED CEILING.
- ⑤ PROVIDE 3/4" CD PIPING & REFER TO MECH. DWG. FOR EXACT LOCATIONS OF FC UNITS.



architecture
planning
interiors

Burton Clifford Associates, Inc.
210 Hammond Ave.
Fremont, California 94539
[T] 510.445.1000
[F] 510.445.1005
www.BCAincOnline.com

PROJECT 2007-0731
CONTACT Omar Hawit
717 Market Street
Suite 500
San Francisco, CA 94103
TEL 415.488.7240
FAX 415.488.7288
www.interfaceengineering.com

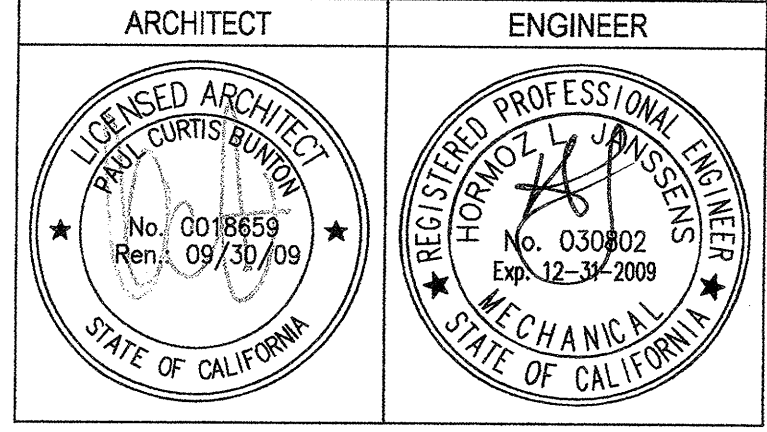

GENERAL NOTES
1. This sheet is part of a set and is not to be used alone.
2. This sheet is not to be used for construction unless the architect's stamp and signature appear on the drawings and the status box indicates drawings have been released for construction.
3. These plans and prints thereof, as instruments of service, are owned by the architect and are for use on this project only. Reproduction and/or distribution without the prior written consent of the architect is forbidden.
4. Copyright © Burton Clifford Associates, 2007

REMARKS	DATE

DRAWING STATUS
 DSA PLAN CHECK
 DSA BACK CHECK
 BIDDING (BID #86688)
 CONSTRUCTION

FILE NO. 41-C1
 IDENTIFICATION STAMP
 DIV. OF THE STATE ARCHITECT
 01-110074
 AC 1/11/09
 DATE MAR 19 2009

**BUILDINGS 5 & 6
RENOVATIONS**
 San Mateo County Community
College District

DSA BACK-CHECK

CAÑADA COLLEGE
 4200 Farm Hill Boulevard
 Redwood City, CA 94061

PLUMBING PLAN
FIRST FLOOR

Date 01/22/09
 Scale AS NOTED
 Project Number 07013
 Drawing Number **P2.1**

1 PLUMBING PLAN - FIRST FLOOR
 SCALE: 1/8"=1'-0"