

1 TOILET 17 PLAN
SCALE: 1/4" = 1'-0"

2 TOILET 26 PLAN
SCALE: 1/4" = 1'-0"

3 TOILET 30 PLAN
SCALE: 1/4" = 1'-0"

4 RESTROOMS 35-37 PLAN
SCALE: 1/4" = 1'-0"

5 RESTROOMS 06-07 PLAN
SCALE: 1/4" = 1'-0"



SHEET NOTES

- ① 2-1/2" CW AND 3/4" HWT FROM CEILING, PROVIDE SHUT-OFF VALVES IN VERTICAL IN WALL, WITH ACCESS PANEL.
- ② 2-1/2" CW AND 3/4" HWT FROM CEILING, PROVIDE SHUT-OFF VALVES IN VERTICAL IN WALL, WITH ACCESS PANEL.
- ③ NOT USED.
- ④ 2" CW FROM CEILING, PROVIDE SHUT-OFF VALVES IN VERTICAL IN WALL, WITH ACCESS PANEL.
- ⑤ 2" W - DN.
- ⑥ 4" W - DN.
- ⑦ 2" V - DN.
- ⑧ 2" VTR.
- ⑨ 2-1/2" VTR.
- ⑩ WATER HAMMER ARRESTER IN WALL, WITH ACCESS PANEL.
- ⑪ TRAP PRIMER FITTING IN WALL, WITH DEDICATED SHUT-OFF VALVE AND ACCESS PANEL.
- ⑫ DRAIN BOX WITH TRAP AND AIR-GAP FITTING.
- ⑬ NOT USED.
- ⑭ NOT USED.
- ⑮ NOT USED.
- ⑯ SUPPLY AND DRAIN PIPING TO FIXTURES TO BE CAPPED BEHIND WALL.
- ⑰ PIPING TO BE CAPPED BELOW FLOOR.

AS-BUILTS



NO.	DATE	REASON	BY
1		ADDENDUM#1	
2	03/17/03	CHANGE REQUEST#19	DA
3	05/20/03	CHANGE REQUEST#20	DA

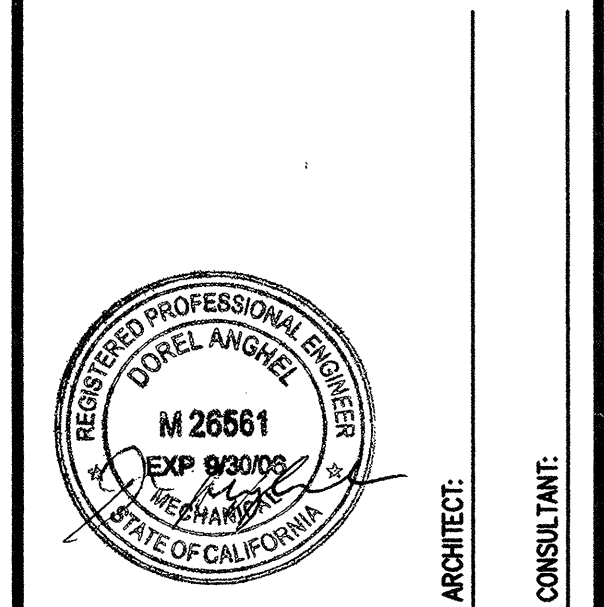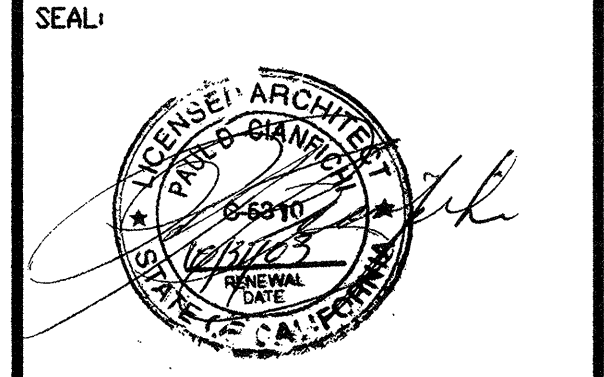

CONSULTANT:
MECHANICAL DESIGN STUDIO inc
1777 Oakland Blvd., Suite 210
Walnut Creek, California 94598
Tel: (925) 256-8636
Fax: (925) 256-0144
www.mds-ef.com
PROJECT # 23018.00

ARCHITECT:
CIANFICHI ARCHITECTURE • PLANNING

30 ANNE COURT
WALNUT CREEK, CA. 94598
TEL: (925) 256-8636
FAX: (925) 256-8652

PROJECT:
**CHILD DEVELOPMENT CENTER
CANADA COLLEGE**

STAMP:
APPROVED
DIV. OF THE STATE ARCHITECT
AO: *AG* FLS: *EP* SS: *SC*
APPL. NO. *102529* DATE: *6/16/03*

APPL. NUMBER:
KEY PLAN:

SHEET TITLE:
PARTIAL FLOOR PLANS - PLUMBING

DRAWN BY: JLW/LK	PROJECT NO.: 304.99
CHECKED BY: DA	DATE: JULY 3, 2000
APPL. NO.:	SHEET: P2.1r
DATE NO.:	NO. OF:

05/20/03 8:14:40 AM F:\C:\23000\23018\00 CANADA COLLEGE - PROGRAM CHANGES\DRAWINGS\23018P2.DWG