


1 ENLARGED FLOOR PLAN
SCALE: SCALE: 1/4"=1'-0"

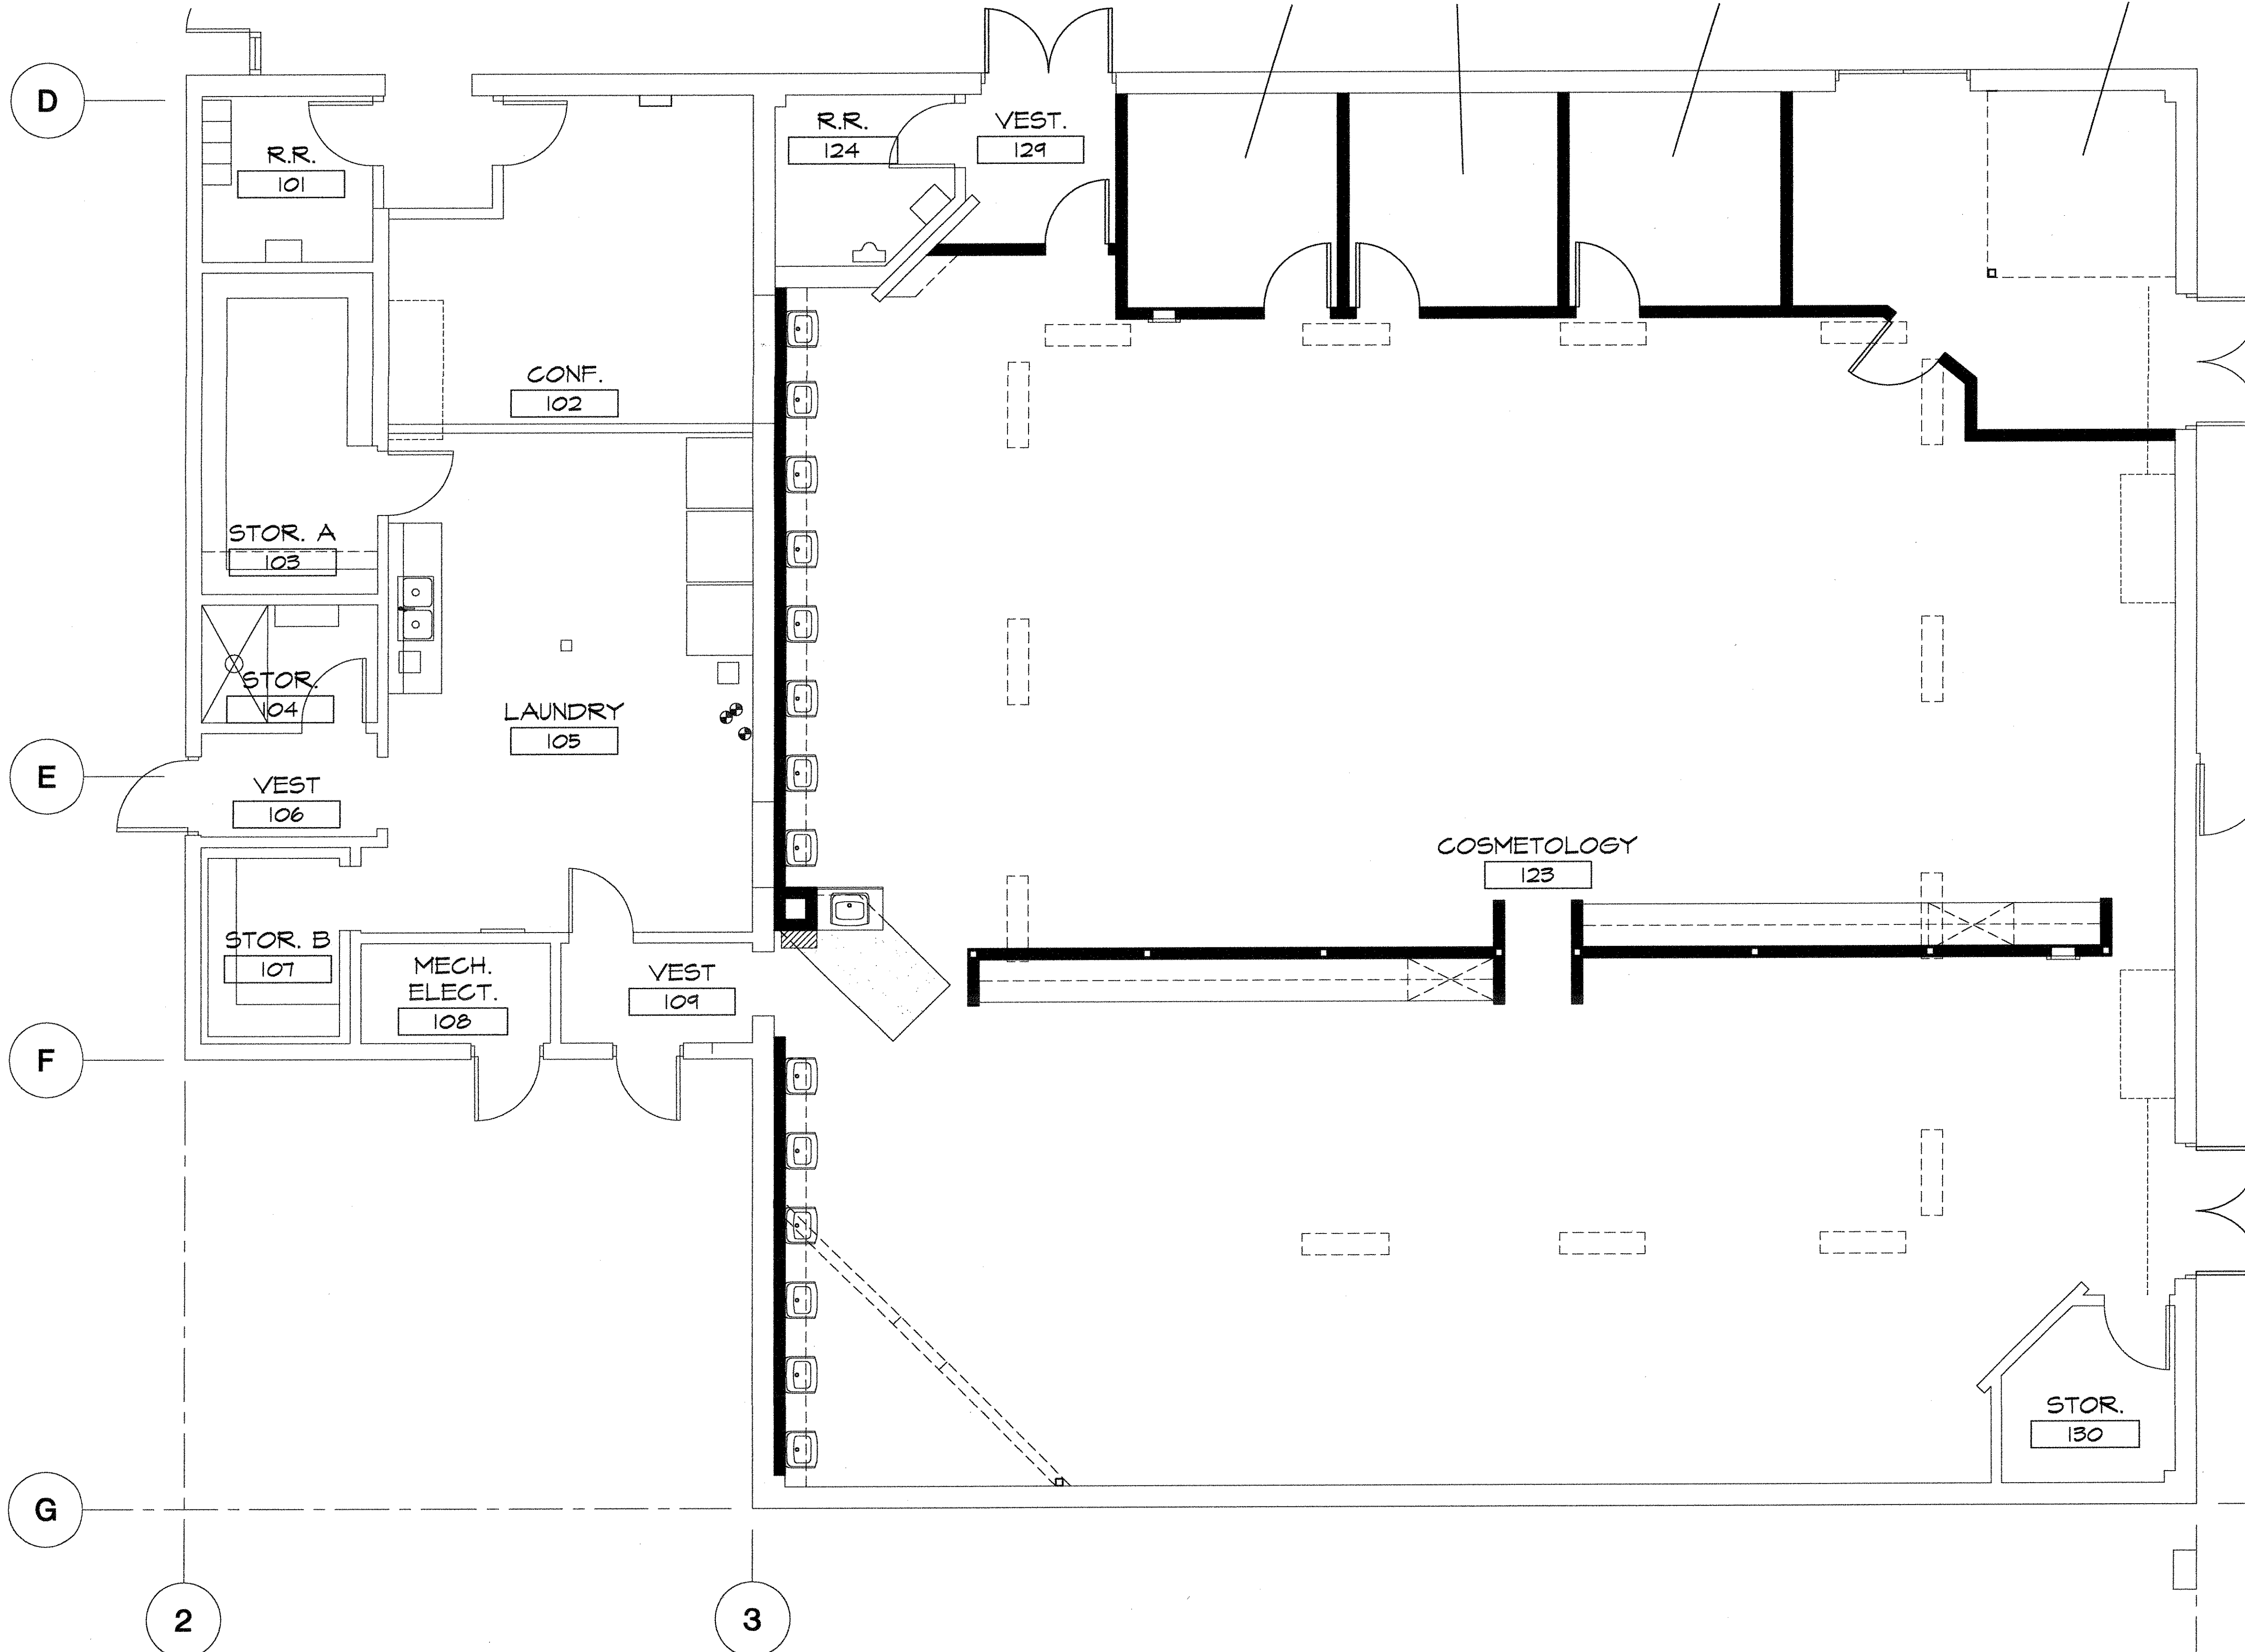

2 ENLARGED FLOOR PLAN
SCALE: SCALE: 1/4"=1'-0"




KEYED NOTES

- 1 CONNECT THE NEW SEWER LINE TO (E) UNDER GROUND SEWER LINE.
- 2 CONNECT THE NEW VENT LINE TO THE (E) VENT LINE.

SHEET NOTES

- 1. CAP THE EXISTING OPEN END OF THE VENT PIPES AFTER DEMOLITION OF THE UNUSED LINES.
- 2. CAP THE EXISTING OPEN END OF THE SEWER PIPES AFTER DEMOLITION OF THE UNUSED LINES.

Sugimura & Associates Architects
 Architecture • Interiors
 Landscape Architecture
 2155 South Bascom Ave., Suite 200
 Campbell, CA 95008
 408-879-0600 FX 408-377-6066
 COPYRIGHT © 2003 Sugimura & Associates Architects

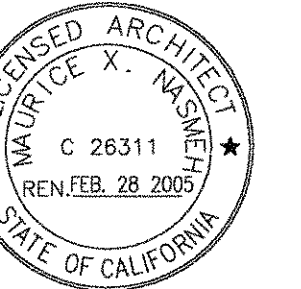

IDENTIFICATION STAMP
 DIVISION OF THE STATE ARCHITECTS
 OFFICE OF REGULATION SERVICES
 APP. NO. _____
 DATE _____
 FILE NO. _____
 Division of the State Architects
 Registration Office, Room 1901
 Oakland, CA 94612

PARTIALS FLOOR PLANS SEWER AND VENT PIPING
BLDG 13
 SKYLINE COLLEGE SWING SPACE
 PERMIT PACKAGE #3
 SKYLINE COLLEGE
 3300 COLLEGE DRIVE
 SAN BRUNO, CA 94066

REVISIONS

NO.	ITEM	DATE

CLIENT APPROVAL: _____
 DRAWN BY: **LS**
 CHECKED BY: **MSL**
 JOB NO: 2145.002 DATE: 13 FEB 2004

KEY PLAN

