


1 ENLARGED FLOOR PLAN
SCALE: SCALE: 1/4"=1'-0"


KEYED NOTES

1 CONNECT THE NEW COLD WATER LINES TO THE EXISTING AND COLD WATER LINES.

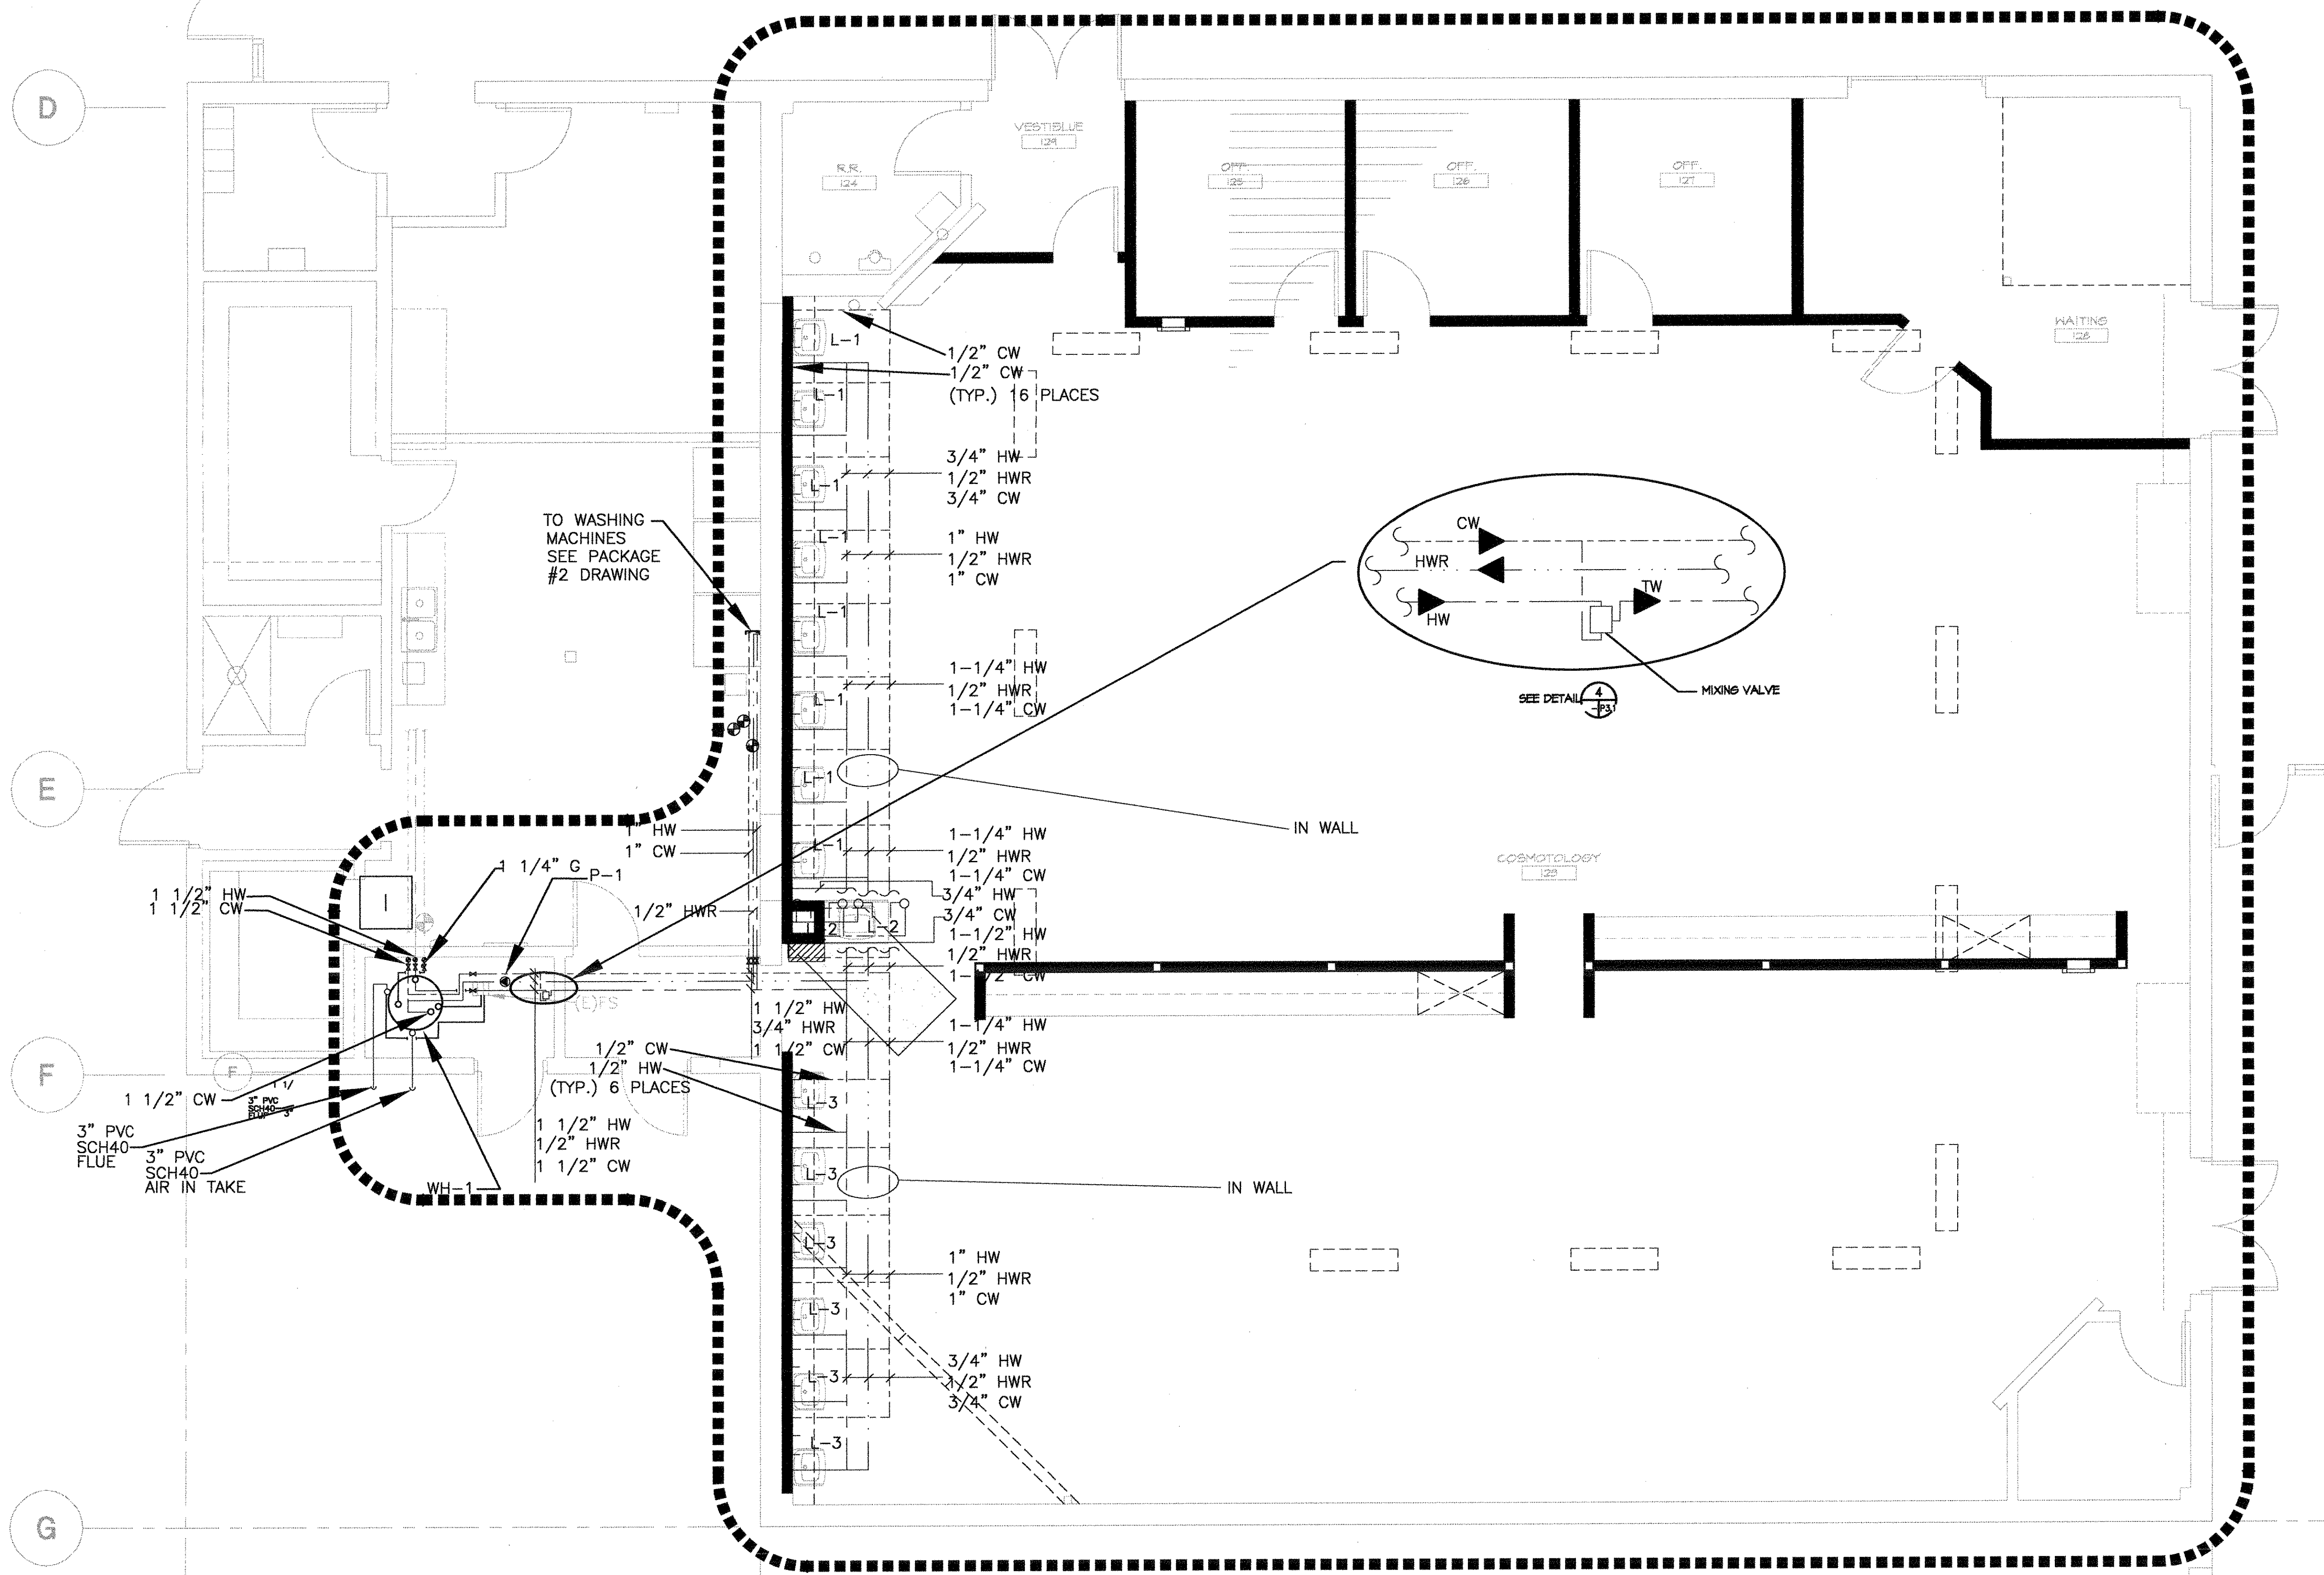


2 ENLARGED FLOOR PLAN
SCALE: SCALE: 1/4"=1'-0"

KEY PLAN

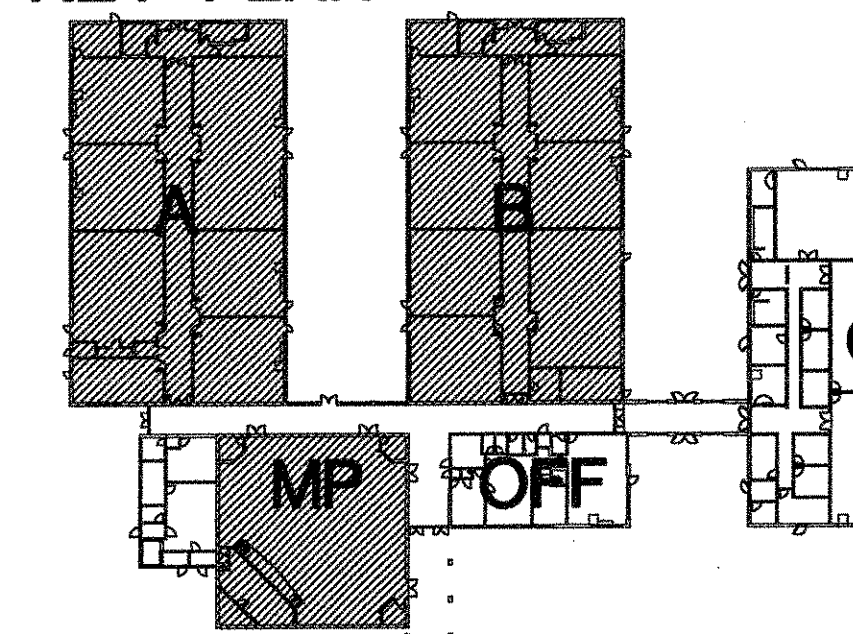

Sugimura & Associates Architects
Architecture • Planning • Interiors
Landscape Architecture
2155 South
Boscam Ave.
Suite 608
Campbell, CA 95008
408-879-0600 FAX 408-377-6066
COPYRIGHT © 2003 Sugimura & Associates Architects

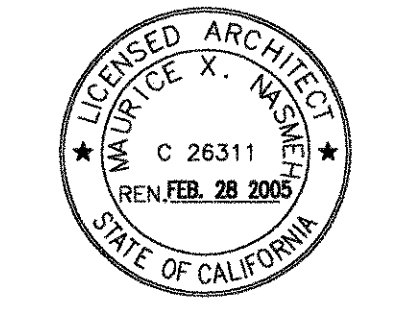

STATE OF CALIFORNIA
DIVISION OF INDUSTRIAL MANUFACTURE
OFFICE OF REGULATION SERVICES
APP. NO. _____
AC: _____ FLS: _____ SS: _____
DATE: _____
FILE NO. _____
Division of the State Architect
1215 Clay St., Suite 2001
Oakland, CA 94612

PARTIAL FLOOR PLANS COLD AND HOT WATER PIPING
BLDG. 13
SKYLINE COLLEGE SWING SPACE
PERMIT PACKAGE #3
SKYLINE COLLEGE
3300 COLLEGE DRIVE
SAN BRUNO, CA 94066

REVISIONS

NO.	ITEM	DATE
3	Miscellaneous Changes	7/01/04

CLIENT APPROVAL:
DRAWN BY: **JLS**
CHECKED BY: **NOEL**
JOB NO: 2145.002
DATE: 13 FEB 2004

P2.5
OF SHEETS