

PLUMBING EQUIPMENT SCHEDULE		
SYMBOL	DESCRIPTION	ELECTRICAL
CP-1 W/ (HW-2)	CIRCULATING PUMP: MANUFACTURER BELL & GOSSETT, MODEL NBF-8 S/P, 2.0 GPM, 7' OF HEAD	120 V 1 # 1 AMP 60 Hz
WH-1 W/ ET-1	ULTRA SUPERSTOR MODEL SSU-119C WITH INTERNAL DOUBLE WALL HEAT EXCHANGER, 119 GALLONS STORAGE, INPUT 180°F, OUTPUT = 480 GPH AT 140°F OF HOT WATER. 210 LBS.	----
WH-2 W/ ET-2	ULTRA SUPERSTOR MODEL SSU-80DW WITH INTERNAL DOUBLE WALL HEAT EXCHANGER 80 GALLONS STORAGE, INPUT 180°F, OUTPUT = 138 GPH AT 140°F OF HOT WATER. 141 LBS.	----
WHA-1	WATER HAMMER ARRESTER ZURN SHOKTROLS Z1700 SERIES	----
GI-1	GREASE INTERCEPTOR, 1000 GAL. CONCRETE TANK UTILITY VAULT MODEL 4484-GA.	----
BV-1	BALANCING VALVE - NIBCO MODEL - 1/2" FIG. T 1710.	----
ET-1 & ET-2	"AMITROL" - THERM-X-TROL # ST-25V	----
BFP-1	BACKFLOW PREVENTER - "WILKINS" MODEL 950 XLTS 1"	----

PLUMBING FIXTURE SCHEDULE					
SYMBOL	DESCRIPTION	CONNECTION			
		W	V	CW	HW
DF-1 ADA	DRINKING FOUNTAIN: WALL HUNG, STAINLESS STEEL, DUAL HEIGHT, ADA COMPLIANT, FLEXI-GUARD SAFETY BUBBLER, FRONT PUSH BUTTON, SELF-CLOSING VALVE, AUTOMATIC STREAM REGULATION VANDAL-RESISTANT BOTTOM PLATE. HAWS 1119, MOUNTING PLATE 8700.4 FITTINGS: 1-1/2 IN. TAIL PIECE, SCREWDRIVER STOP, TUBING SUPPLY. SUPPORT CARRIER: MODEL 8800.	1-1/2"	1-1/2"	1/2"	----
FD-1	FLOOR DRAIN: CAST IRON BODY WITH ADJUSTABLE ROUND POLISHED NICKEL BRONZE STRAINER. STANDARD SCREWS. TRAP PRIMER CONNECTION. J.R. SMITH 2005-A	2"	1-1/2"	----	----
FD-2	FLOOR DRAIN: CAST IRON BODY WITH ADJUSTABLE ROUND TOP ANTI-FLOOD RIM, NICKEL BRONZE STRAINER HEAD AND RECESSED STRAINER, LOOSE GRATE. STANDARD SCREWS. TRAP PRIMER CONNECTION. J.R. SMITH 2005-F37	2"	1-1/2"	----	----
HB-1	HOSE BIBB: WALL FAUCET, INSIDE USE, WITH E27JKCP INTEGRAL VACUUM BREAKER, POLISHED CHROME, TEE HANDLE, CHICAGO-293-CP	----	----	3/4"	----
JS-1	JANITOR SINK: FLOOR MOUNTED, 28 IN. X 28 IN., CORNER TYPE, ACID-RESISTANT, ENAMELED CAST IRON, [RIM GUARDS.] KOHLER K-6710 "WHITBY" FAUCET: HOSE-END SPOUT TYPE WITH INTEGRAL VACUUM BREAKER, ADJUSTABLE ARMS WITH INTEGRAL STOPS, AND WALL BRACE. CHROME. CHICAGO 897-CP	3"	1-1/2"	1/2"	1/2"
L-1	LAVATORY: WALL HUNG, VITREOUS CHINA, 20-3/4 IN. BY 18-3/4 IN., FRONT OVERFLOW, ANTI-BACKSPASH. KOHLER K-2032 "GREENWICH" WITH 4 IN. CENTER FAUCET HOLES. FITTINGS: 1-1/4 IN. BY 1-1/2 IN. P-TRAP. SUPPLIES AND STOPS. CARRIER: FLOOR MOUNTED WITH CONCEALED ARMS. J.R. SMITH AS APPLICABLE. FAUCET: METERING/SELF-CLOSING TYPE, 4 IN. CENTERS, ADJUSTABLE SLOW CLOSING, TEMPERATURE LIMIT STOP, IN-LINE CHECK/SCREEN ASSEMBLIES, 0.5 GPM AERATOR, GRID STRAINER, CHROME. SYMMONS S-60-1-H WITH POP-UP DRAIN INSTEAD OF GRID STRAINER	1-1/2"	1-1/2"	1/2"	1/2"
L-2 ADA	SAME AS L-1 EXCEPT FOR ADA COMPLIANT & PROVIDE INSULATION KIT TO P-TRAP AND SUPPLIES. SEE SPECIFICATIONS.	1-1/2"	1-1/2"	1/2"	1/2"
REC-1	ROOF CEPTOR, DURA-COATED CAST IRON BODY ZURN MODEL-Z-122	3"	----	----	----
S-1 ADA	SINK: JUST MODEL SL-ADA-2122-A-GR, 18 GAUGE TYPE 304 18-8 STAINLESS 21" FRONT TO BACK X 22" LEFT TO RIGHT X 6" DEPTH, WITH FAUCET AND BUBBLE LEDGE. FAUCET: CHICAGO 786-SWCP, DECK-MOUNTED, WITH GN28 RIGID/SWING GOOSENECK SPOUT, 317 WRIST BLADE	2"	1-1/2"	1/2"	1/2"
S-2 ADA	EXAM SINK: JUST MODEL SL-ADA-2217-A-GR, 18 GAUGE TYPE 304 18-8 STAINLESS STEEL, INSIDE DIMENSION: 16" FRONT-TO-BACK X 14" LEFT TO RIGHT X 6-1/2" DEEP WITH FAUCET AND BUBBLE LEDGE. FAUCET: CHICAGO 626; DECK MOUNTED SINGLE WATER INLET, WITH GN2A GOOSENECK SPOUT WITH LAMINAR FLOW OUTLET; CHICAGO-625-SLO COMBINATION PEDAL VALVE WITH 62BSLSLO NAAD ADJUSTABLE SELF-CLOSING CARTRIDGE. DRAIN: JUST J-35-SSF, STAINLESS STEEL FLAT GRID DRAIN.	----	----	----	----
TPV-1	TRAP PRIMER MIFAB TRAP SEAL PRIMER MODEL MR-500 SERIES	----	----	----	----
U-1	URINAL: SIPHON JET, VITREOUS CHINA, WALL MOUNTED, HIGH EFF. URINAL SYSTEM 3/4 IN. (UP SPUD). ZURN Z5798 FLUSH VALVE: 0.125 GAL. PER FLUSH, TOP SPUD. (INFRARED SENSOR/BATTERY) CARRIER: FLOOR MOUNTED. J.R. SMITH 0600 SERIES URINAL SUPPORT WITH SUPPORTING STUDS AND BOTTOM BEARING PLATE.	2"	1-1/2"	3/4"	----
U-2	SAME AS U-1 EXCEPT ADA COMPLIANT	2"	1-1/2"	3/4"	----
WC-1	WATER CLOSET: WALL HUNG, SIPHON JET ACTION, VITREOUS CHINA, ELONGATED BOWL, 1-1/2 IN. TOP SPUD FOR EXPOSED FLUSH VALVE, BOLT CAPS. MOUNTING HEIGHT STANDARD. KOHLER K-4330 "KINGSTON" SEAT: OPEN FRONT, COMMERCIAL WEIGHT HEAVY-DUTY PLASTIC, STAINLESS STEEL CHECK HINGE, WHITE, WITHOUT COVER. CHURCH 9500C. FLUSH VALVE: 1.6 GAL. PER FLUSH DOWN/1.1 GAL. PER FLUSH UP, TOP SPUD. SLOAN WES-111 (MANUAL OPERATION) CARRIER: J.R. SMITH 0200 SERIES OR EQUAL.	4"	2"	1-1/2"	----
WC-2 ADA	WATER CLOSET: WALL HUNG, SIPHON JET ACTION, VITREOUS CHINA, ELONGATED BOWL, 1-1/2 IN. TOP SPUD FOR EXPOSED FLUSH VALVE, BOLT CAPS. MOUNTING HEIGHT ADA COMPLIANT. KOHLER K-4330 "KINGSTON" SEAT: OPEN FRONT, COMMERCIAL WEIGHT HEAVY-DUTY PLASTIC, STAINLESS STEEL CHECK HINGE, WHITE, WITHOUT COVER. CHURCH 9500C. FLUSH VALVE: 1.6 GAL. PER FLUSH DOWN/1.1 GAL. PER FLUSH UP, TOP SPUD. SLOAN WES-111 (MANUAL OPERATION) CARRIER: J.R. SMITH 0200 SERIES OR EQUAL.	4"	2"	1-1/2"	----
HB-2	WOODFORD TRIMLINE WALL HYDRANT MODEL B75, CONCEALED BOX TYPE, INTEGRAL ANTI-SIPHON VACUUM BREAKER, 3/4" MALE HOSE THREAD, 3/4" FEMALE INLET PIPE THREAD W/ 360 DEGREE INLET ORIENTATION. BRASS WALL BOX, BRASS COVER AND KEY. FITS INSIDE A 4" WALL.	----	----	3/4"	----

REF-184-0  
Janitor sink  
mounting Height.

REF-90  
REF-155  
POP-UP drains  
REF-209


REF-210  
S-2 sink Ada  
compliance

REF-198  
urinal flush valve.

Bunton Clifford Associates, Inc.  
210 Hammond Ave.  
Fremont, California 94539  
[T] 510.445.1000  
[F] 510.445.1005  
www.BCAincOnline.com

PROJECT 2007-0731  
CONTACT Omar Hawit

717 Market Street  
Suite 500  
San Francisco, CA 94103  
TEL 415.489.7240  
FAX 415.489.7289  
www.interfaceengineering.com

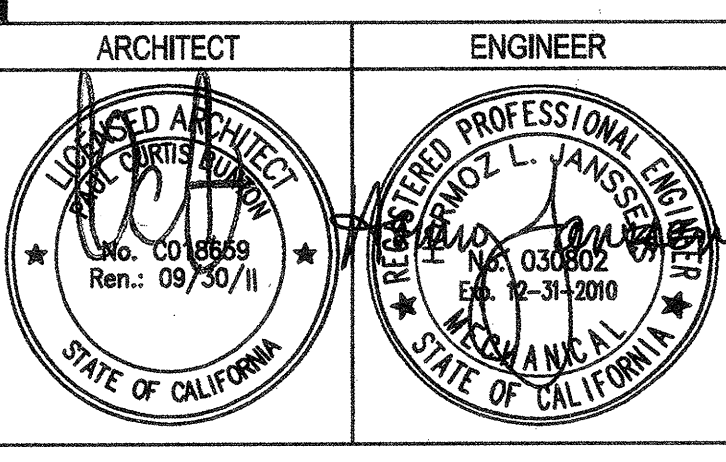

GENERAL NOTES  
1. This sheet is part of a set and is not to be used alone.  
2. This sheet is not to be used for construction unless the architect's stamp and signature appear on the drawings and the status box indicates drawings have been released for construction.  
3. These plans and prints thereof, as instruments of service, are owned by the architect and are for use on this project only. Reproduction and/or distribution without the prior written consent of the architect is forbidden.  
4. Copyright Bunton Clifford Associates, 2007

REVISIONS	DATE
ADDENDUM NO. 1	09/18/09

DRAWING STATUS	DATE
● DSA PLAN CHECK	09/28/08
● DSA BACK CHECK	01/22/09
● BIDDING (AND ABBREV)	08/18/09
○ CONSTRUCTION	

FILE NO. 41-C1

IDENTIFICATION STAMP  
DIV. OF THE STATE ARCHITECT

01- 110074

AC \_\_\_\_\_ FLS \_\_\_\_\_ SS \_\_\_\_\_

DATE \_\_\_\_\_

**BUILDINGS 5 & 6  
RENOVATIONS**

San Mateo County Community  
College District

**BID ADDENDA**

APPROVED  
DIV. OF THE STATE ARCHITECT  
AC 01 FLS RC SS  
APPL NO. 42024 DATE 2/7/10

**CAÑADA COLLEGE**  
4200 Farm Hill Boulevard  
Redwood City, CA 94061

PLUMBING  
FIXTURE SCHEDULE

Date 08/29/08  
Drawing Number  
Scale AS NOTED  
Project Number 07013

**P4.1**