




1M CAMPUS MAP

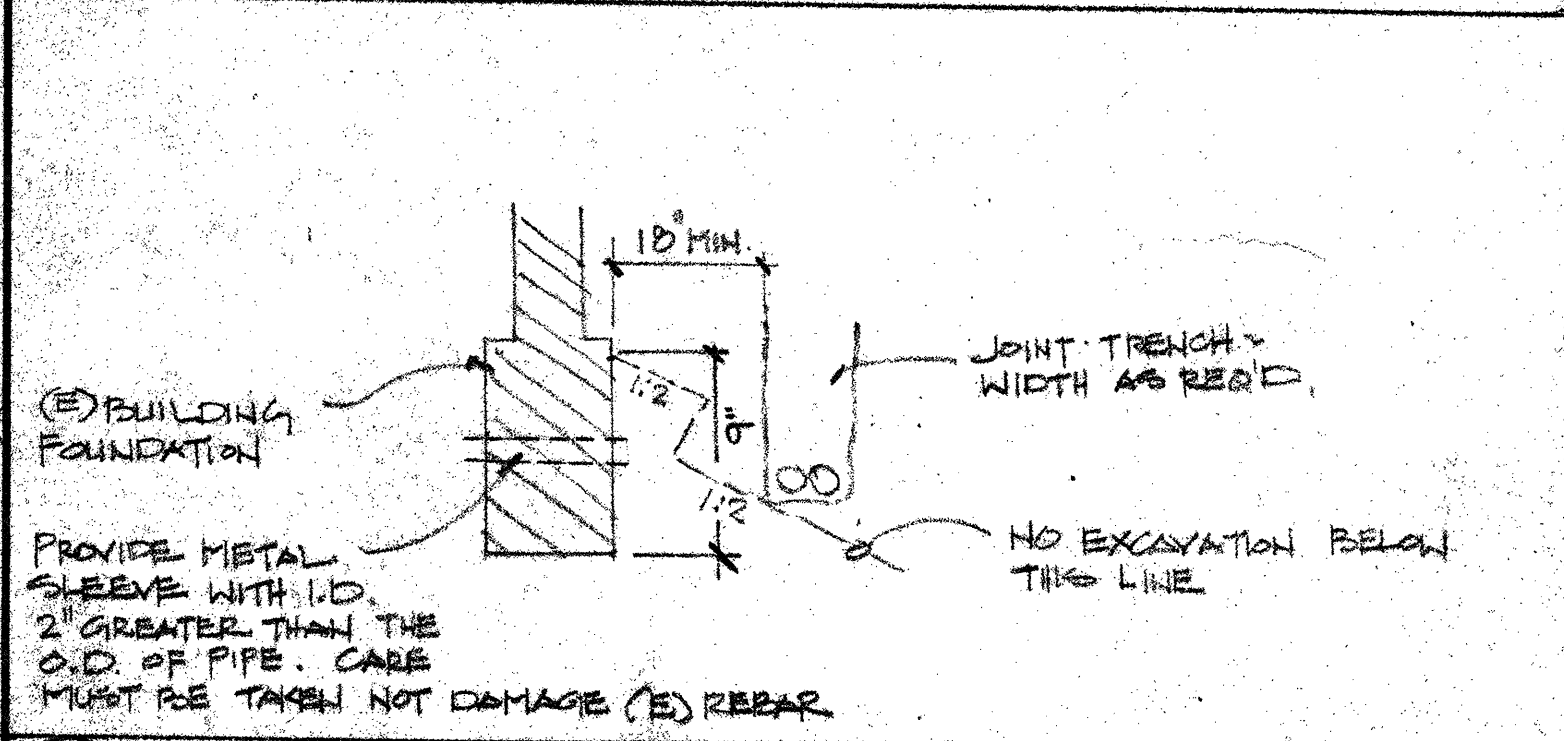


1J JOINT TRENCH

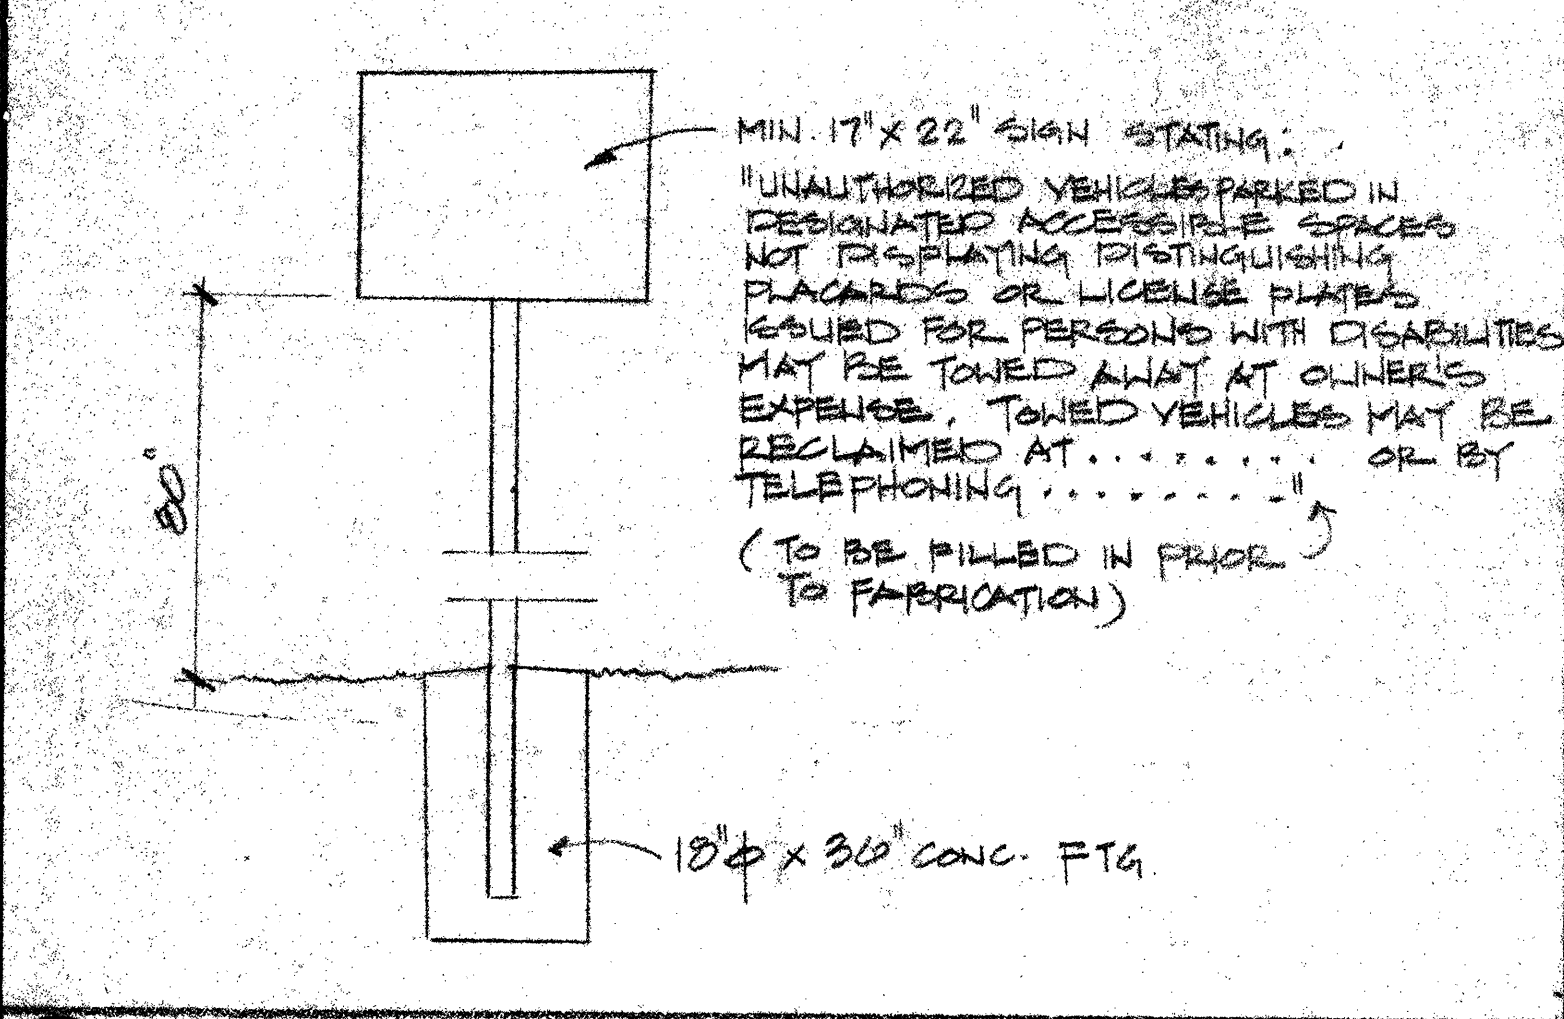


1E POLE MOUNTED SIGN

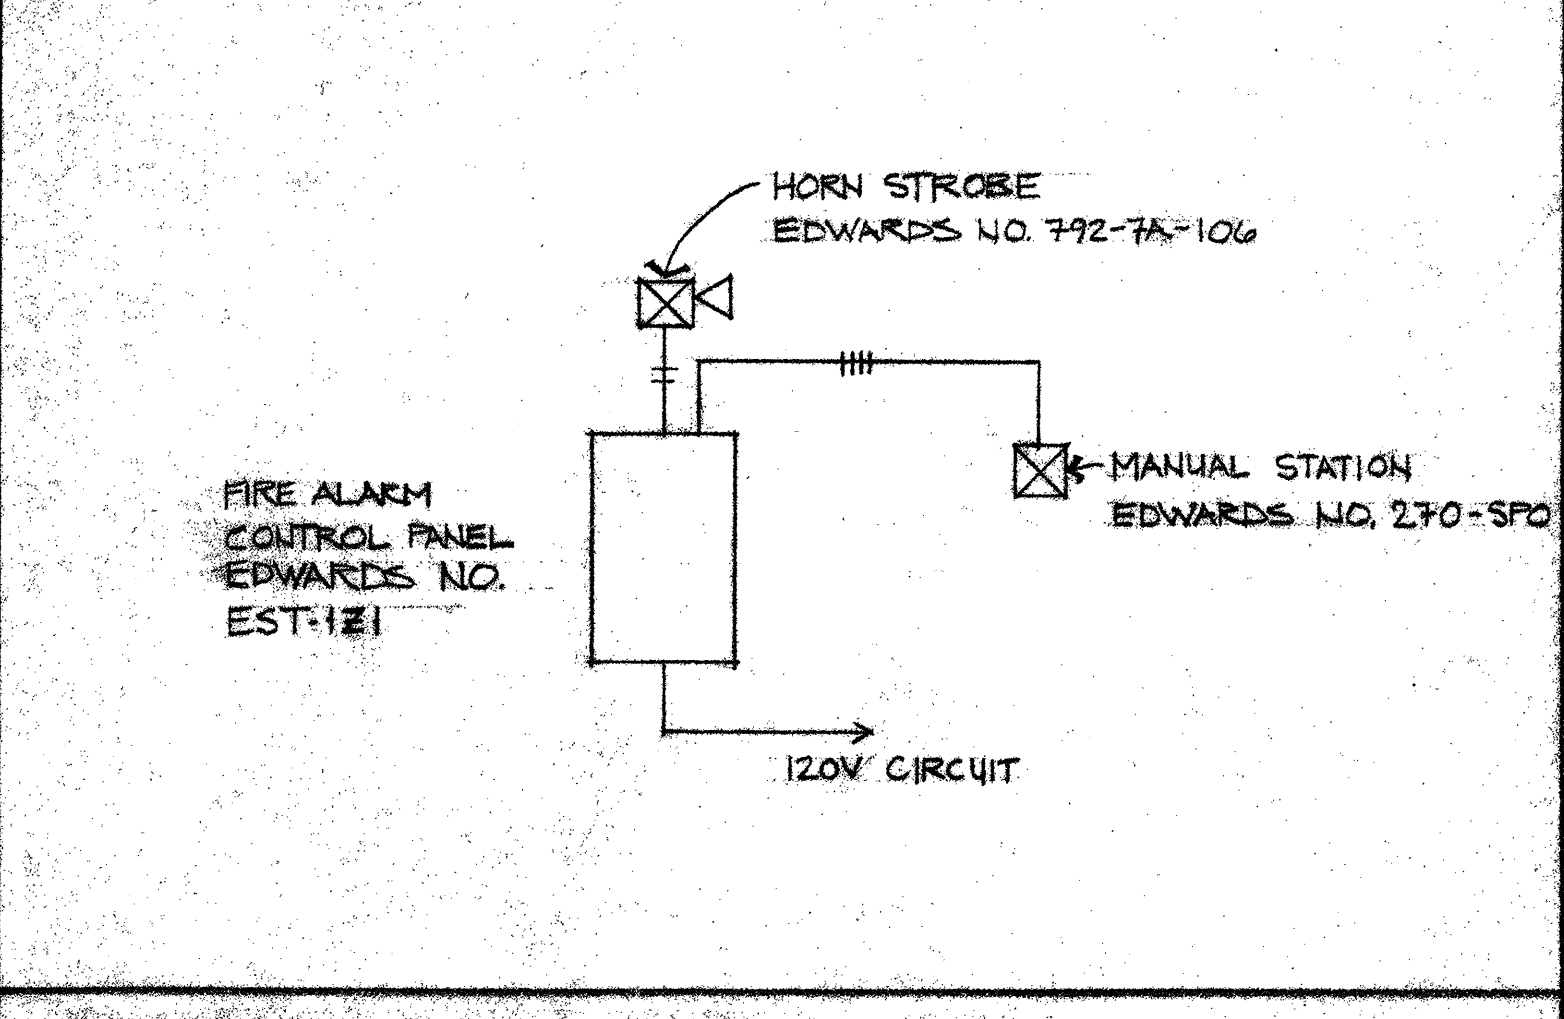

FIRE ALARM RISER DIAGRAM

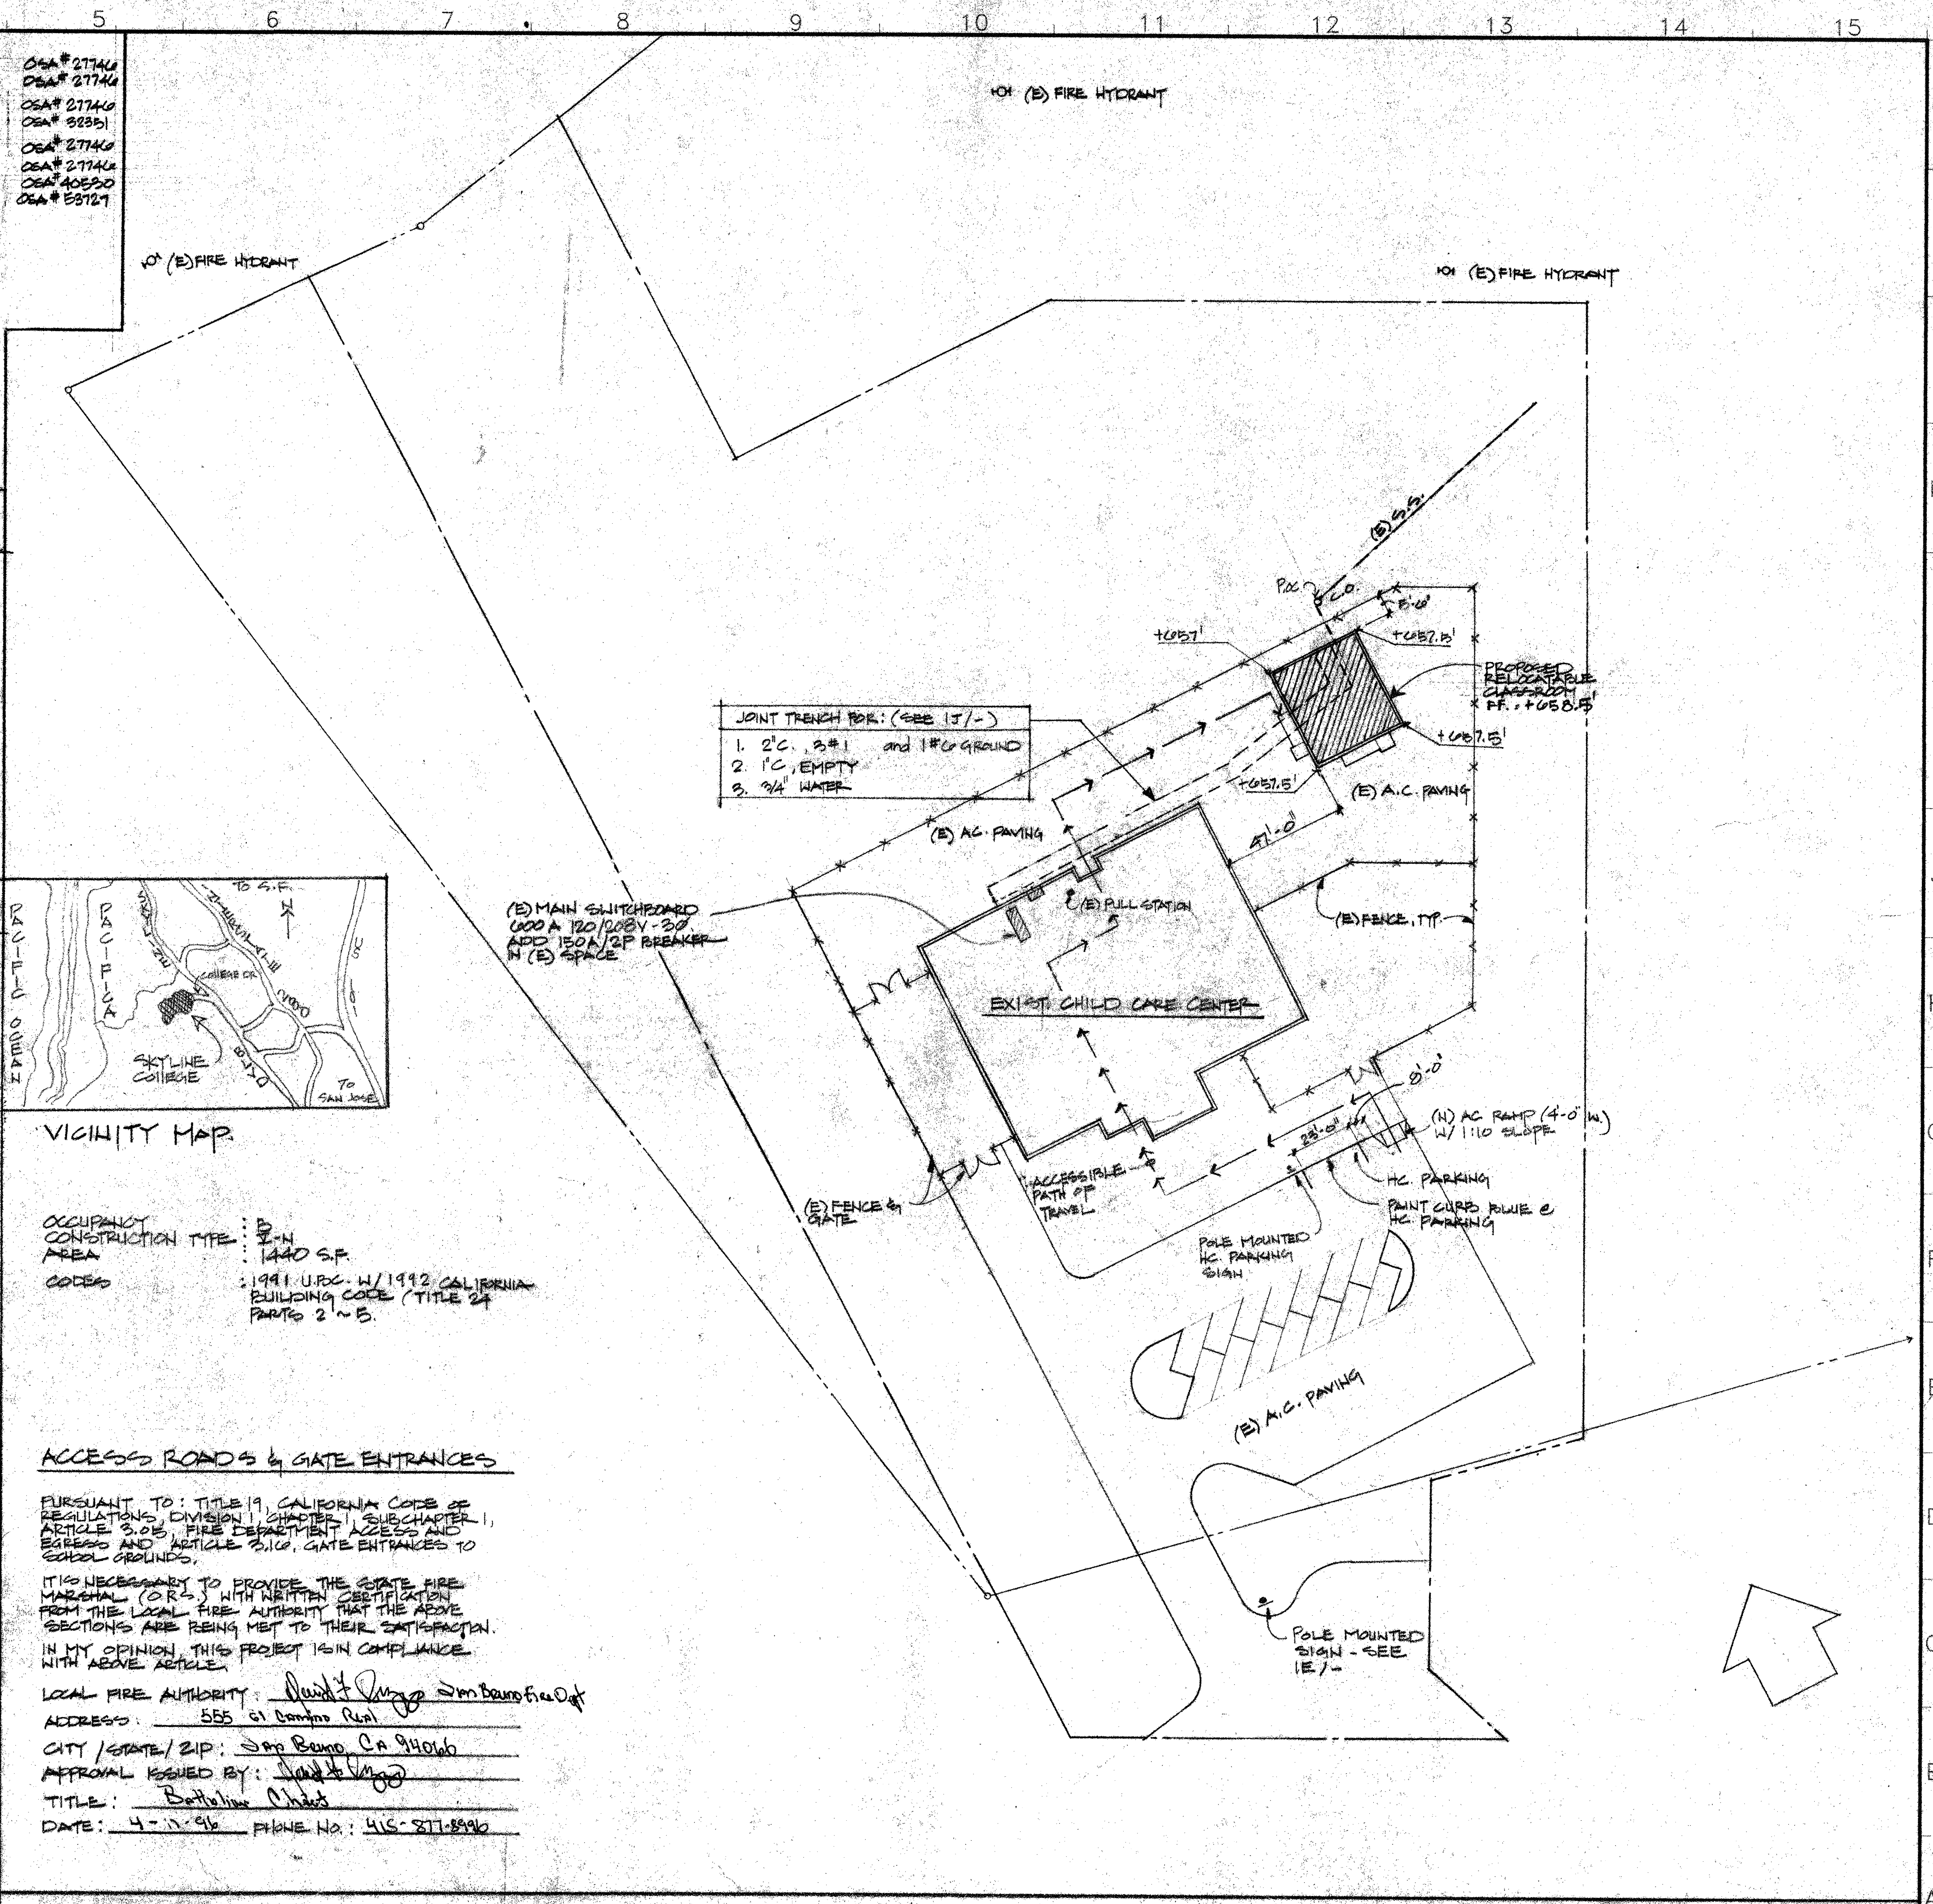

SITE PLAN 1/8" = 1'-0"

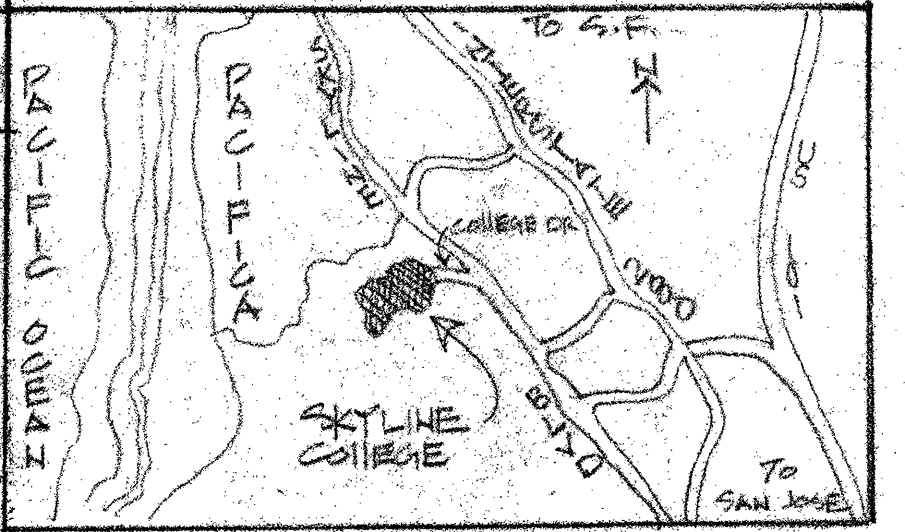

VICINITY MAP

OCCUPANCY CONSTRUCTION TYPE: B
 AREA: 1440 S.F.
 CODES: 1991 U.P.C. W/ 1992 CALIFORNIA BUILDING CODE (TITLE 24 PARTS 2 & 5)

ACCESS ROADS & GATE ENTRANCES

FURSUANT TO: TITLE 19, CALIFORNIA CODE OF REGULATIONS, DIVISION CHAPTER 1, SUBCHAPTER 1, ARTICLE 3.05, FIRE DEPARTMENT ACCESS AND EGRESS AND ARTICLE 2.10, GATE ENTRANCES TO SCHOOL GROUNDS.


IT IS NECESSARY TO PROVIDE THE STATE FIRE MARSHAL (S.F.M.) WITH WRITTEN CERTIFICATION FROM THE LOCAL FIRE AUTHORITY THAT THE ABOVE SECTIONS ARE BEING MET TO THEIR SATISFACTION.

IN MY OPINION, THIS PROJECT IS IN COMPLIANCE WITH ABOVE ARTICLE.

LOCAL FIRE AUTHORITY: San Bruno Fire Dept
 ADDRESS: 555 G. Camino Real
 CITY / STATE / ZIP: San Bruno, Ca 94066
 APPROVAL ISSUED BY: [Signature]
 TITLE: Battalion Chief
 DATE: 4-11-96 PHONE No.: 415-877-8996

REVISION	DATE	DESCRIPTION	INITIAL

ISSUE FOR PRELIMINARY
 ISSUE FOR 50% C.D.
 ISSUE FOR 90% C.D.
 ISSUE FOR 100% C.D.
 ISSUE FOR BID

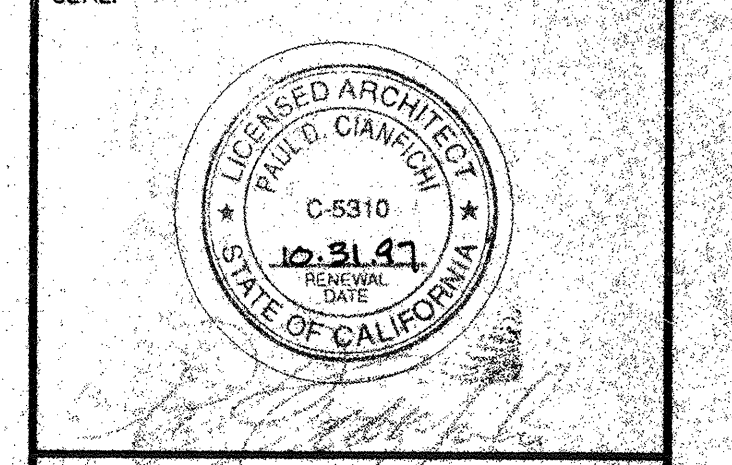


CONSULTANT:

INTERACTIVE RESOURCES
 ARCHITECTURE • PLANNING • ENGINEERING
 117 PARK PLACE
 POINT RICHMOND
 CALIFORNIA 94801
 (510) 236-7435
 (FAX) 232-5325

PROJECT:
RELOCATABLE CLASSROOM

SKYLINE COLLEGE
3300 COLLEGE DR.
SAN BRUNO, CA. 94066

SAN MATEO COUNTY COMMUNITY COLLEGE DISTRICT

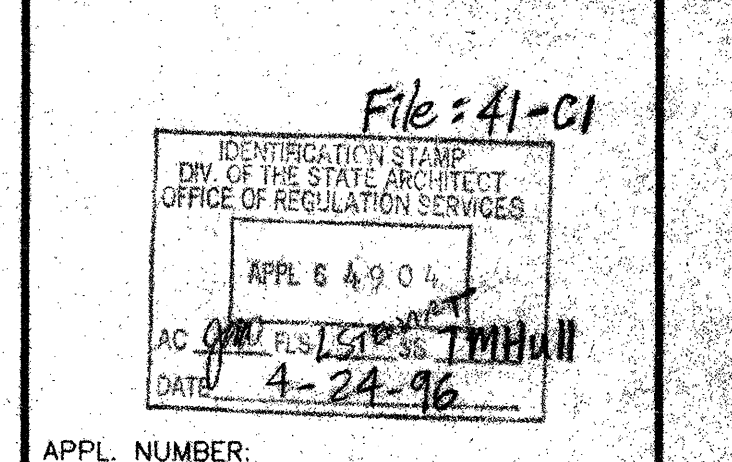

APPL NUMBER: _____
 SHEET TITLE: _____

SCALE	PROJ. NO.	PREPARATION AND REVIEW
	9503-14	

SHEET NUMBER: _____

SA-1

NUMBER: _____ OF: _____