


CABLE SCHEDULE CCTV			
TYPE	DESCRIPTION	MANUFACTURER	PART #
F	DATA CENTER CABLES	PAULER	DISCREETLY
G	100 FT. CABLES (CONCATENATED)	PAULER	CONCAT

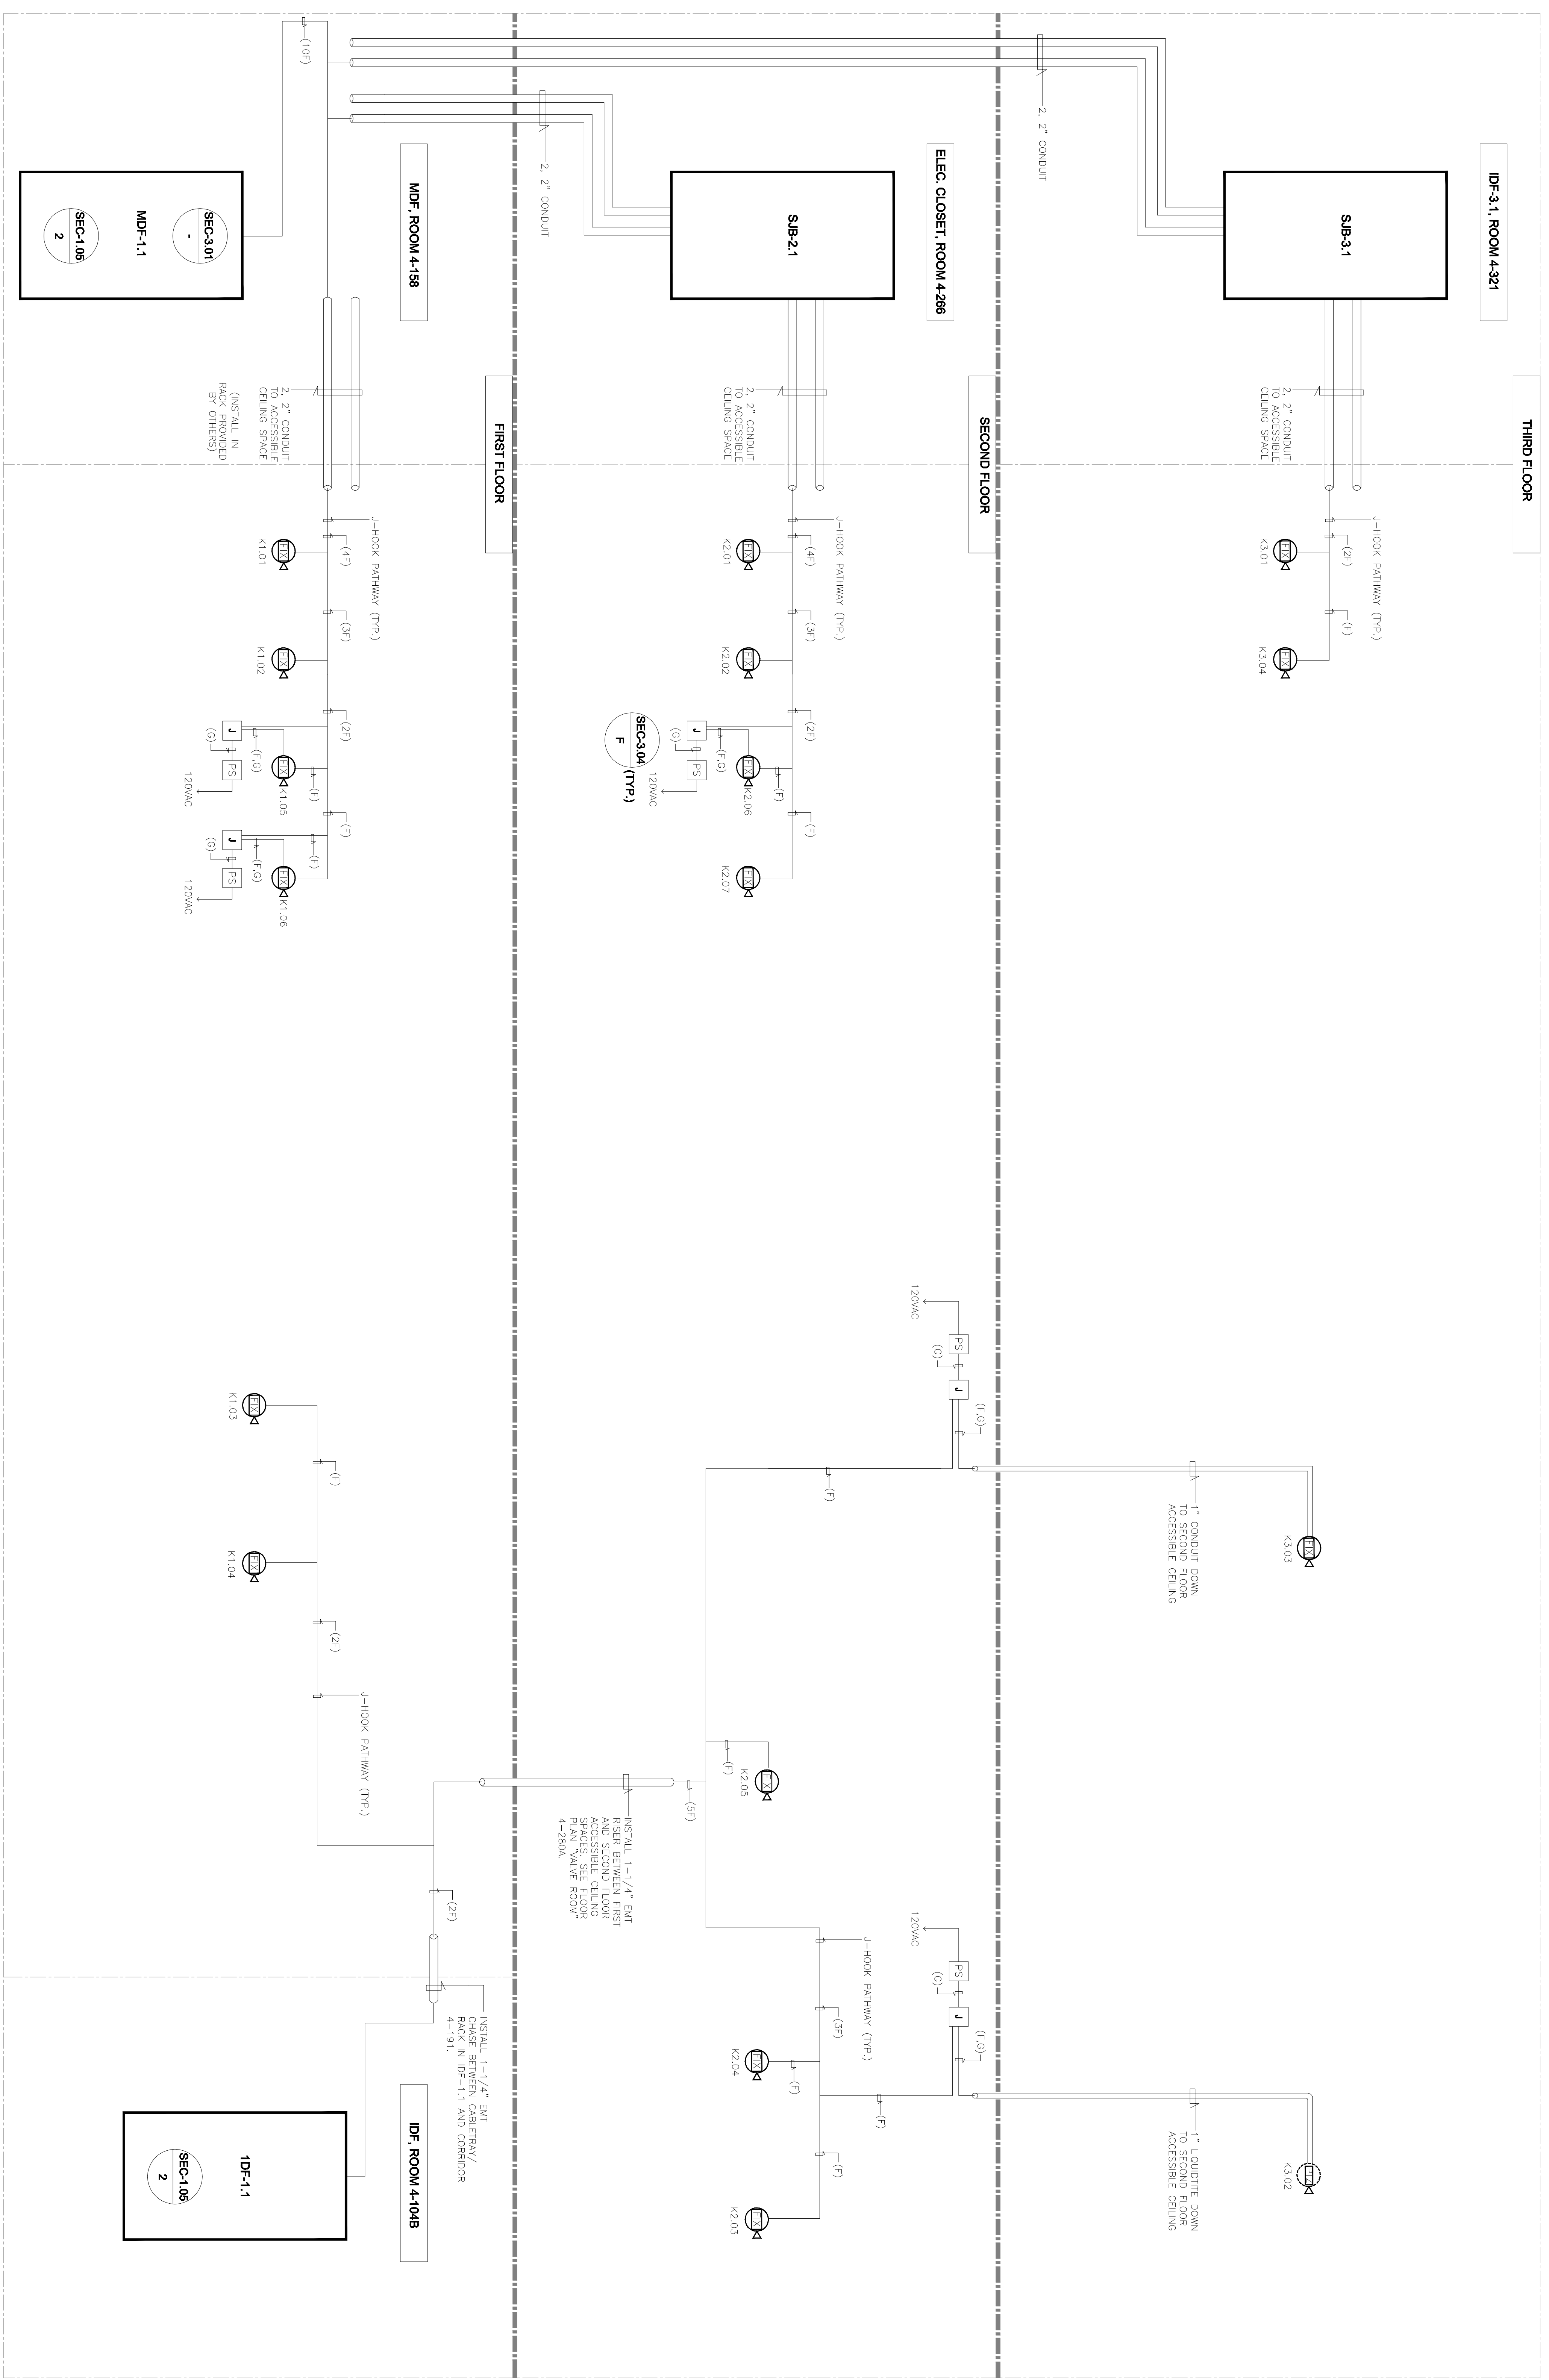

1 CCTV RISER DIAGRAM
 SCALE: NTS

NETVERSANT
Inspiring Technology Solutions

NO.	REVISIONS/REVISIONS	DATE
1	100% SCHEMATIC DESIGN SUBMITTAL	04/04/08
2	50% DESIGN DEVELOPMENT SUBMITTAL	06/13/08
3	100% DESIGN DEVELOPMENT SUBMITTAL	07/29/08
4	50% INSTALLMENT #1	08/29/08
5	INSTALLMENT #2	09/18/08
6	INSTALLMENT #3	11/11/08
7	OSM INCORPORATE AS BSM REVIEW	11/11/08
8	OSM INCORPORATE #1 BACK CHECK	11/19/08
9	OSM INCORPORATE #2 BSM REVIEW	12/18/08
10	OSM INCORPORATE #3	02/02/09
11	OSM INCORPORATE #4	03/17/09
12	OSM INCORPORATE #5 BACKCHECK	06/12/09
13	PROJECT RECORD SET	01/01/11

PROJECT RECORD SET

**SKYLINE COLLEGE
 CIP2 DESIGN-BUILD
 BUILDING 4N**

PROJECT NO.	07012.00	DRAWN BY	ML
DATE	01/21/11	CHECKED BY	CW/COS
SCALE	AS NOTED		

**CCTV
 RISER
 DIAGRAM**

All drawings and designs remain the property of the undersigned and shall not be reproduced, copied, or disseminated without the written consent of the undersigned. If this drawing is not 100% complete, the drawings have been prepared from the original data. No other source shall be used.