



SCHEDULE OF LIGHTING FIXTURES	
LOCATION	TYPE
MEN, WOMEN	240-J2
CORRIDORS	FIXTURE C
STAIRS	240-A1
EXITS	225-QQ
ALL OTHERS (EXCEPT NOTED ON PLANS)	440-A


LIGHTING FLOOR PLAN
2ND LEVEL FLOOR PLAN
SCALE 1/8"=1'-0"

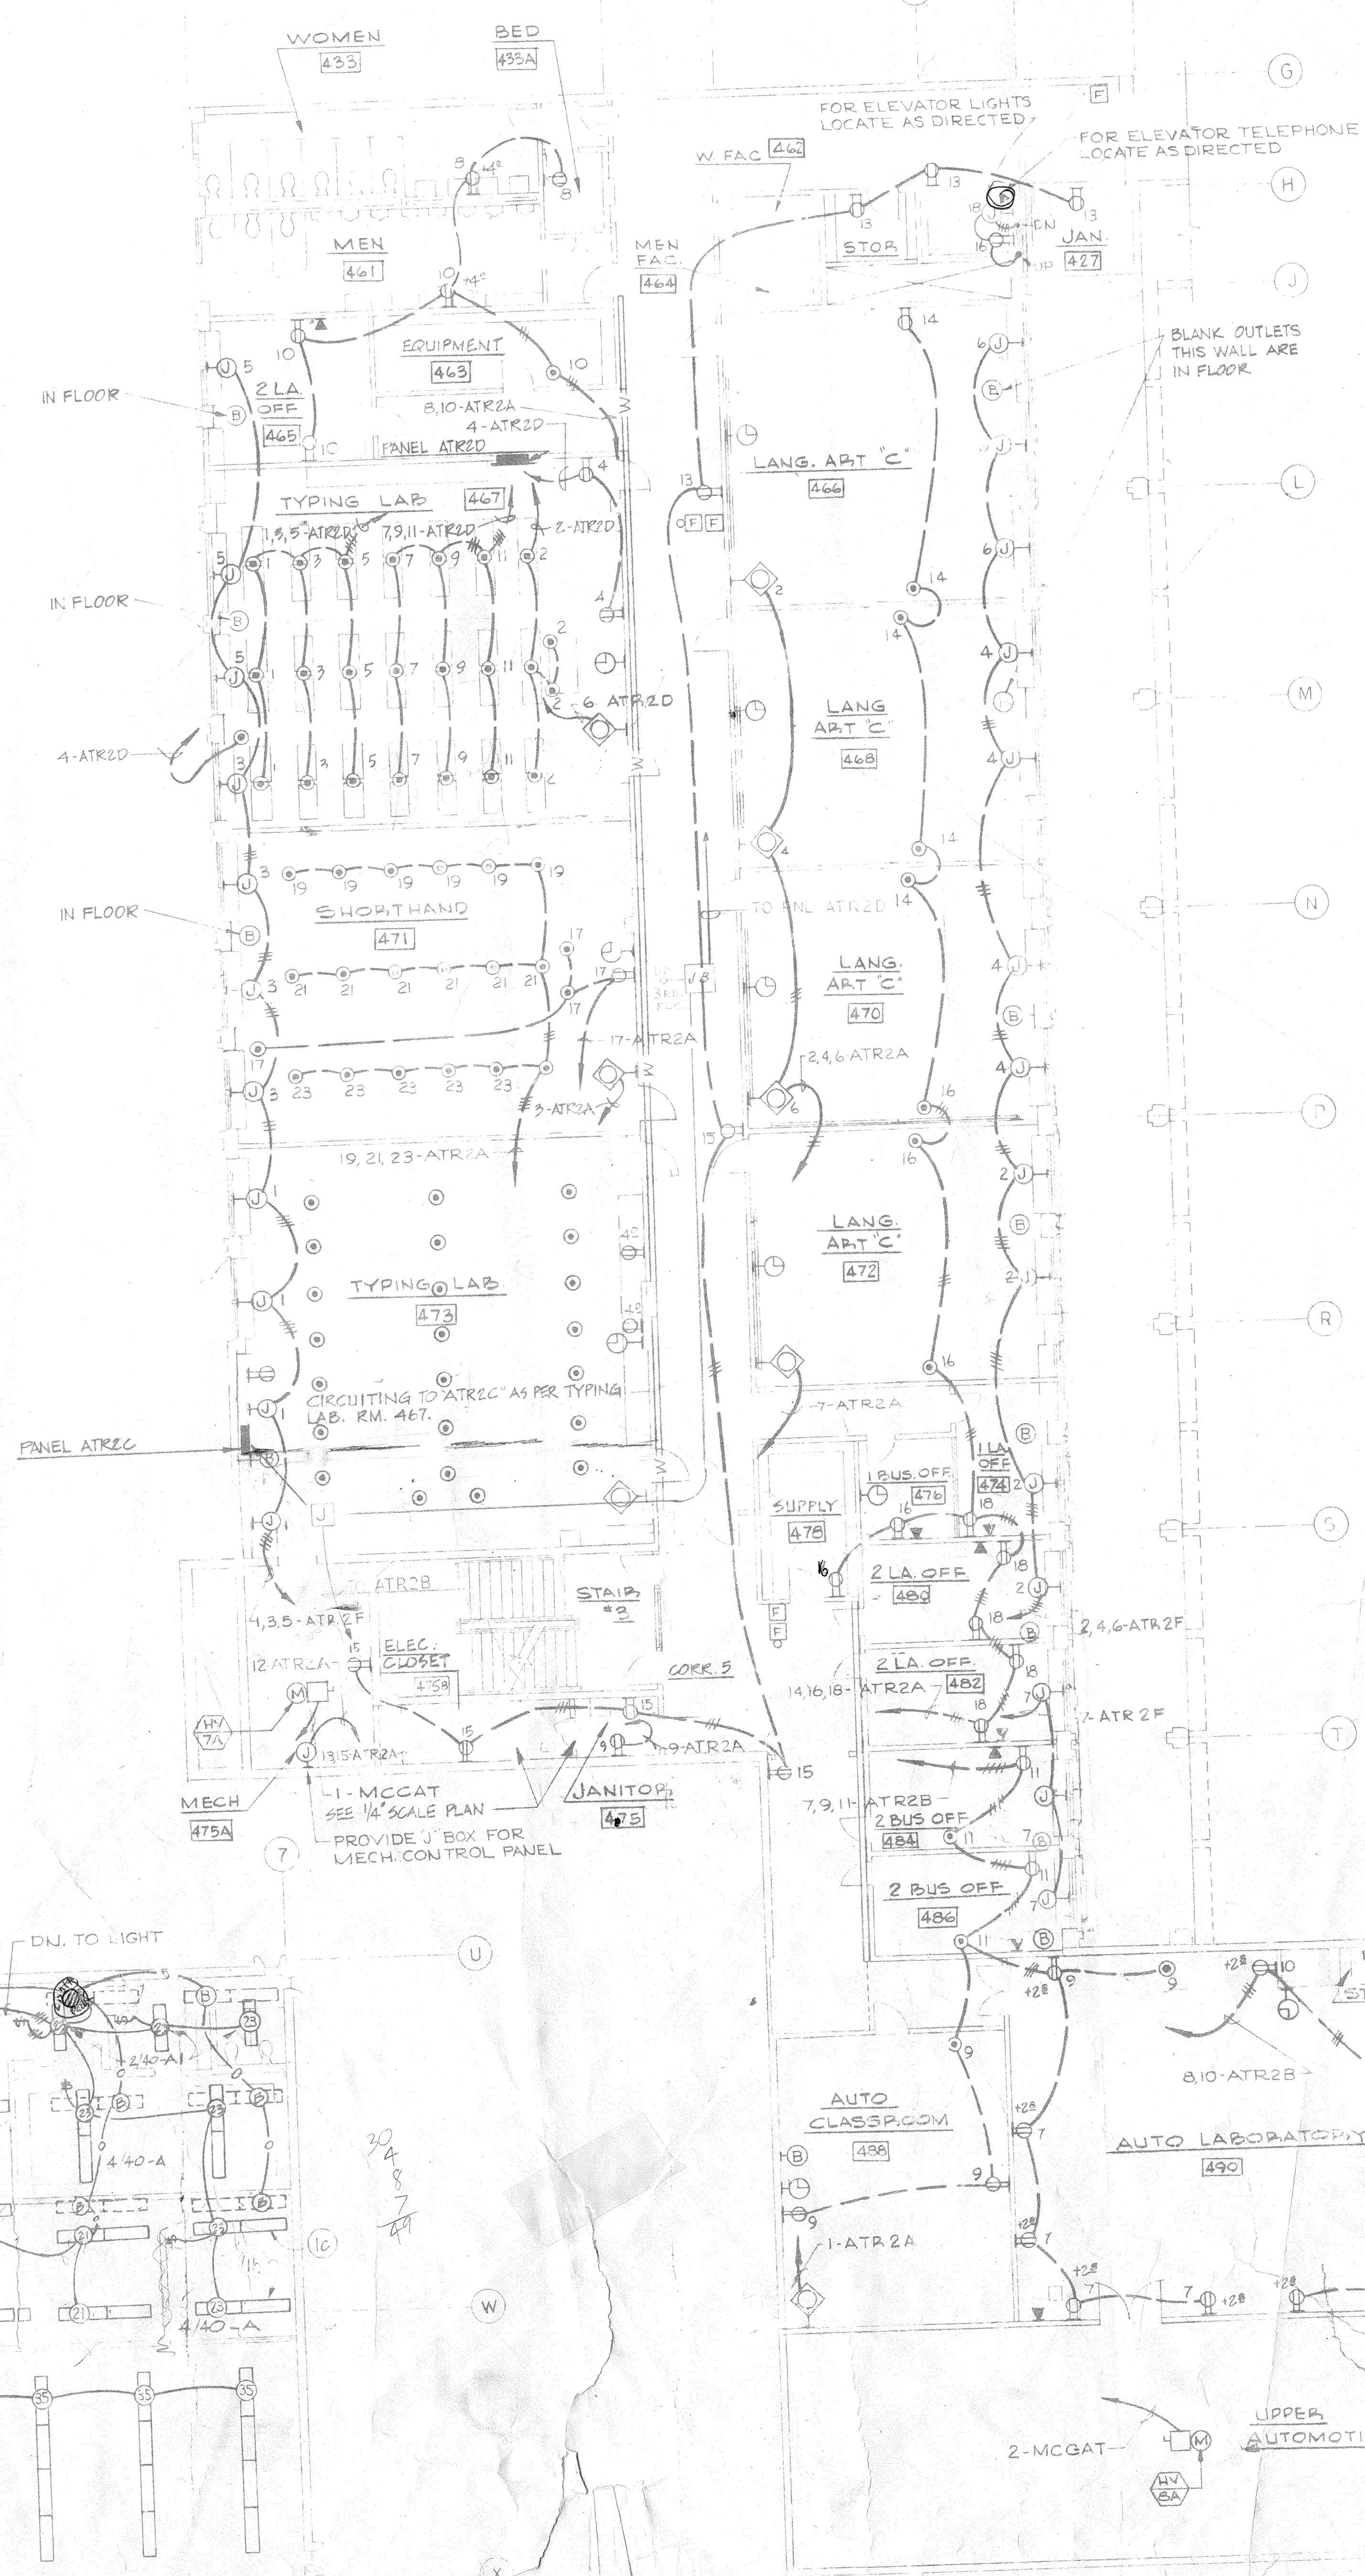

MISCELLANEOUS SYSTEMS
2ND LEVEL FLOOR PLAN
SCALE 1/8"=1'-0"

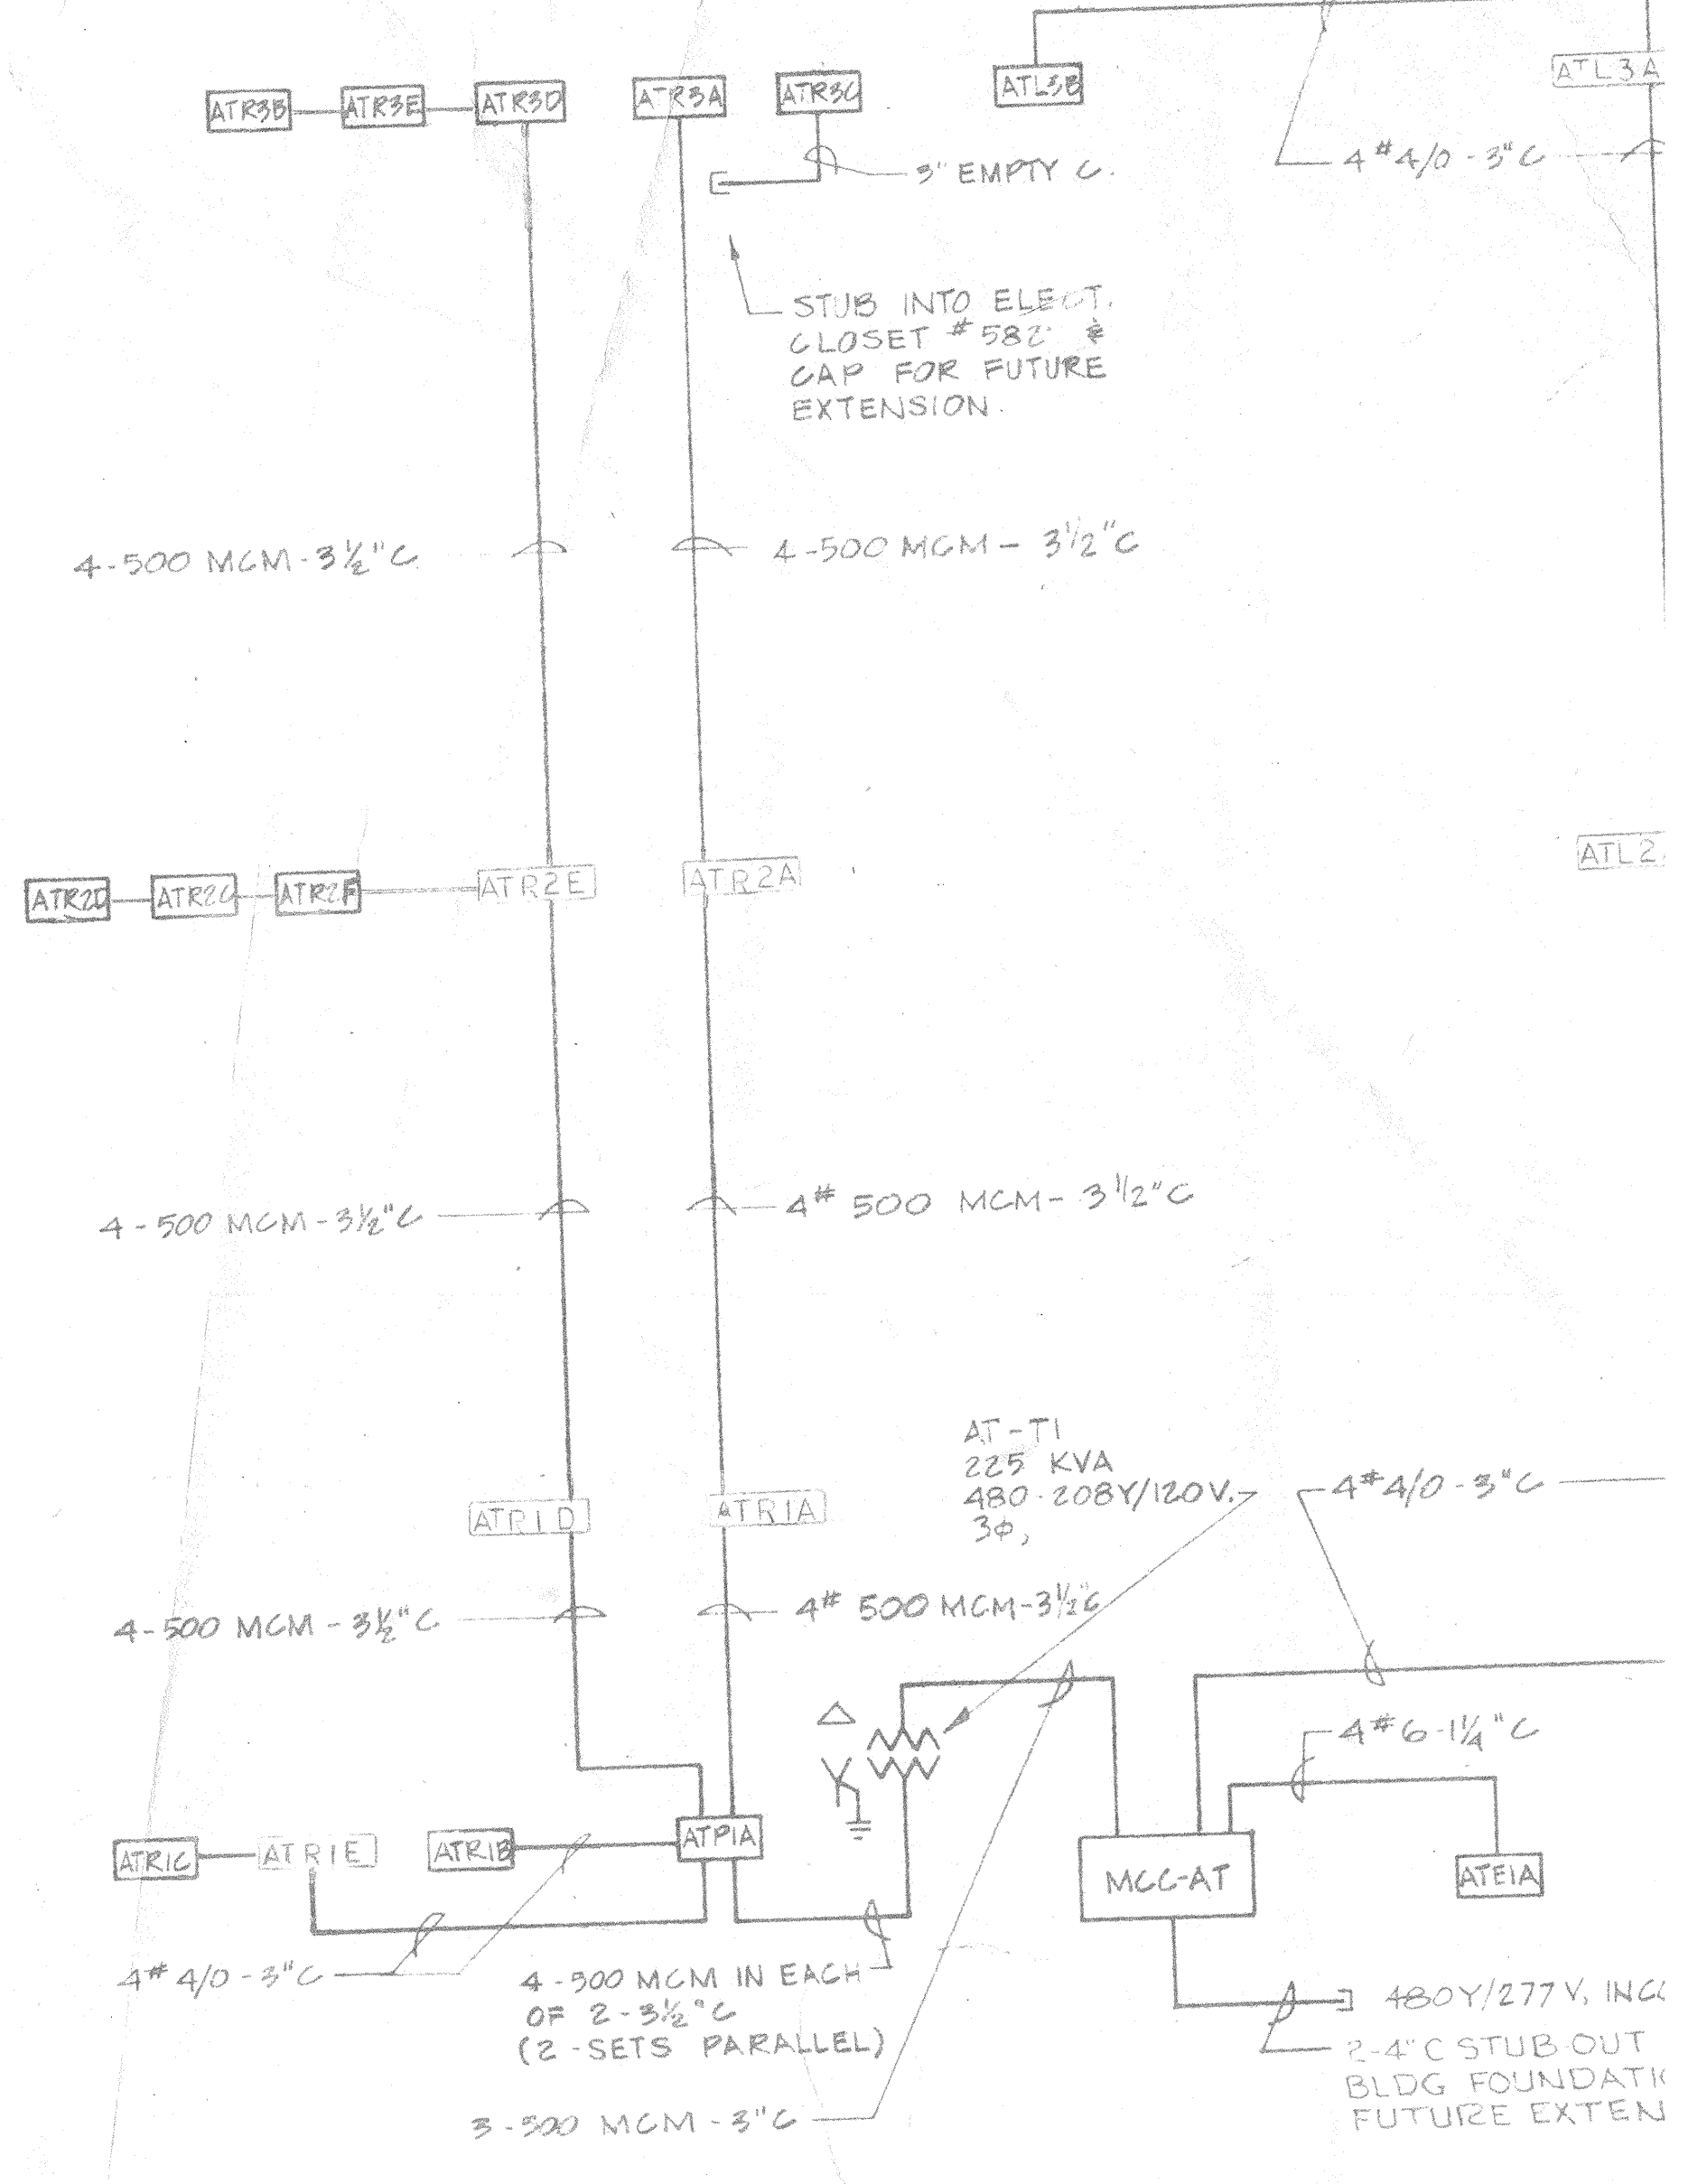

BUILDING "A" RISER DIAGRAM - (WEST PORTION)

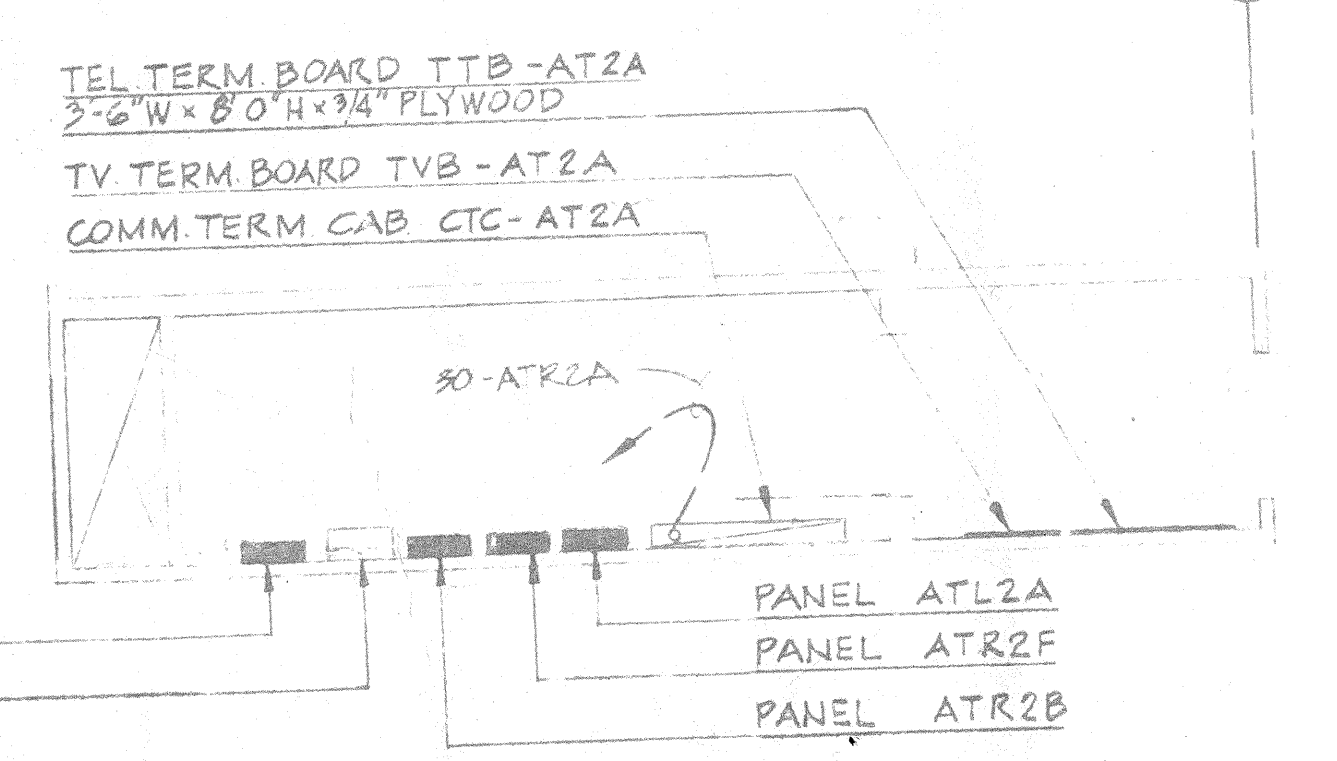

ELECTRIC CLOSET #475
SCALE 1/4"=1'-0"

NOTES:
1. SEE NOTES 1 TO 4 ON SHEET E-4

ADDENDUM NO. 1 ITEM #4
(A) IN BUILDING A, PROVIDE REMOTE CONTROL SWITCH AND LIGHT TO BE ACTIVATED IN "IN" POSITION LOCATED NEAR ROOMS 457 & 473.
(B) PROVIDE 3-POLE CONTACTOR AT MAIN BREAKER IN "IN" ABOVE ROOMS TO BE OPERATED BY SWITCH DESCRIBED