


SHEET NOTES

- COORDINATE TCP/IP ADDRESS FOR ACCESS CONTROL SYSTEM CONTROLLERS AND IP CAMERAS WITH CAÑADA COLLEGE IT DEPARTMENT REPRESENTATIVE.
- ACAMS AND CCTV BLOCK DIAGRAMS ARE DIAGRAMMATIC ONLY. PROVIDE ACU PANELS AND POWER SUPPLIES TO SUPPORT THE FIELD DEVICES SHOWN ON FLOOR PLANS.

NUMBERED NOTES

- SECURITY:**
- [S-1] PROVIDE PATCH CORD FROM OWNER PROVIDED SWITCH TO DEVICE.
 - [S-2] PROVIDE INDIVIDUAL POWER FEED TO EACH 12VDC FIELD DEVICE.
 - [S-3] PROVIDE INDIVIDUAL POWER FEED FOR EACH LOCK.
 - [S-4] INTERCONNECT LOCK OUTPUTS FOR EACH CARD READER DOOR WITH DRY CONTACT INPUT ON LOCK POWER SUPPLY. DO NOT SWITCH LOCK COIL LOAD THROUGH ACU RELAYS.


- TELECOMMUNICATIONS:**
- [T-1] PROVIDE PATCH CORD FROM OWNER PROVIDED SWITCH TO DEVICE.

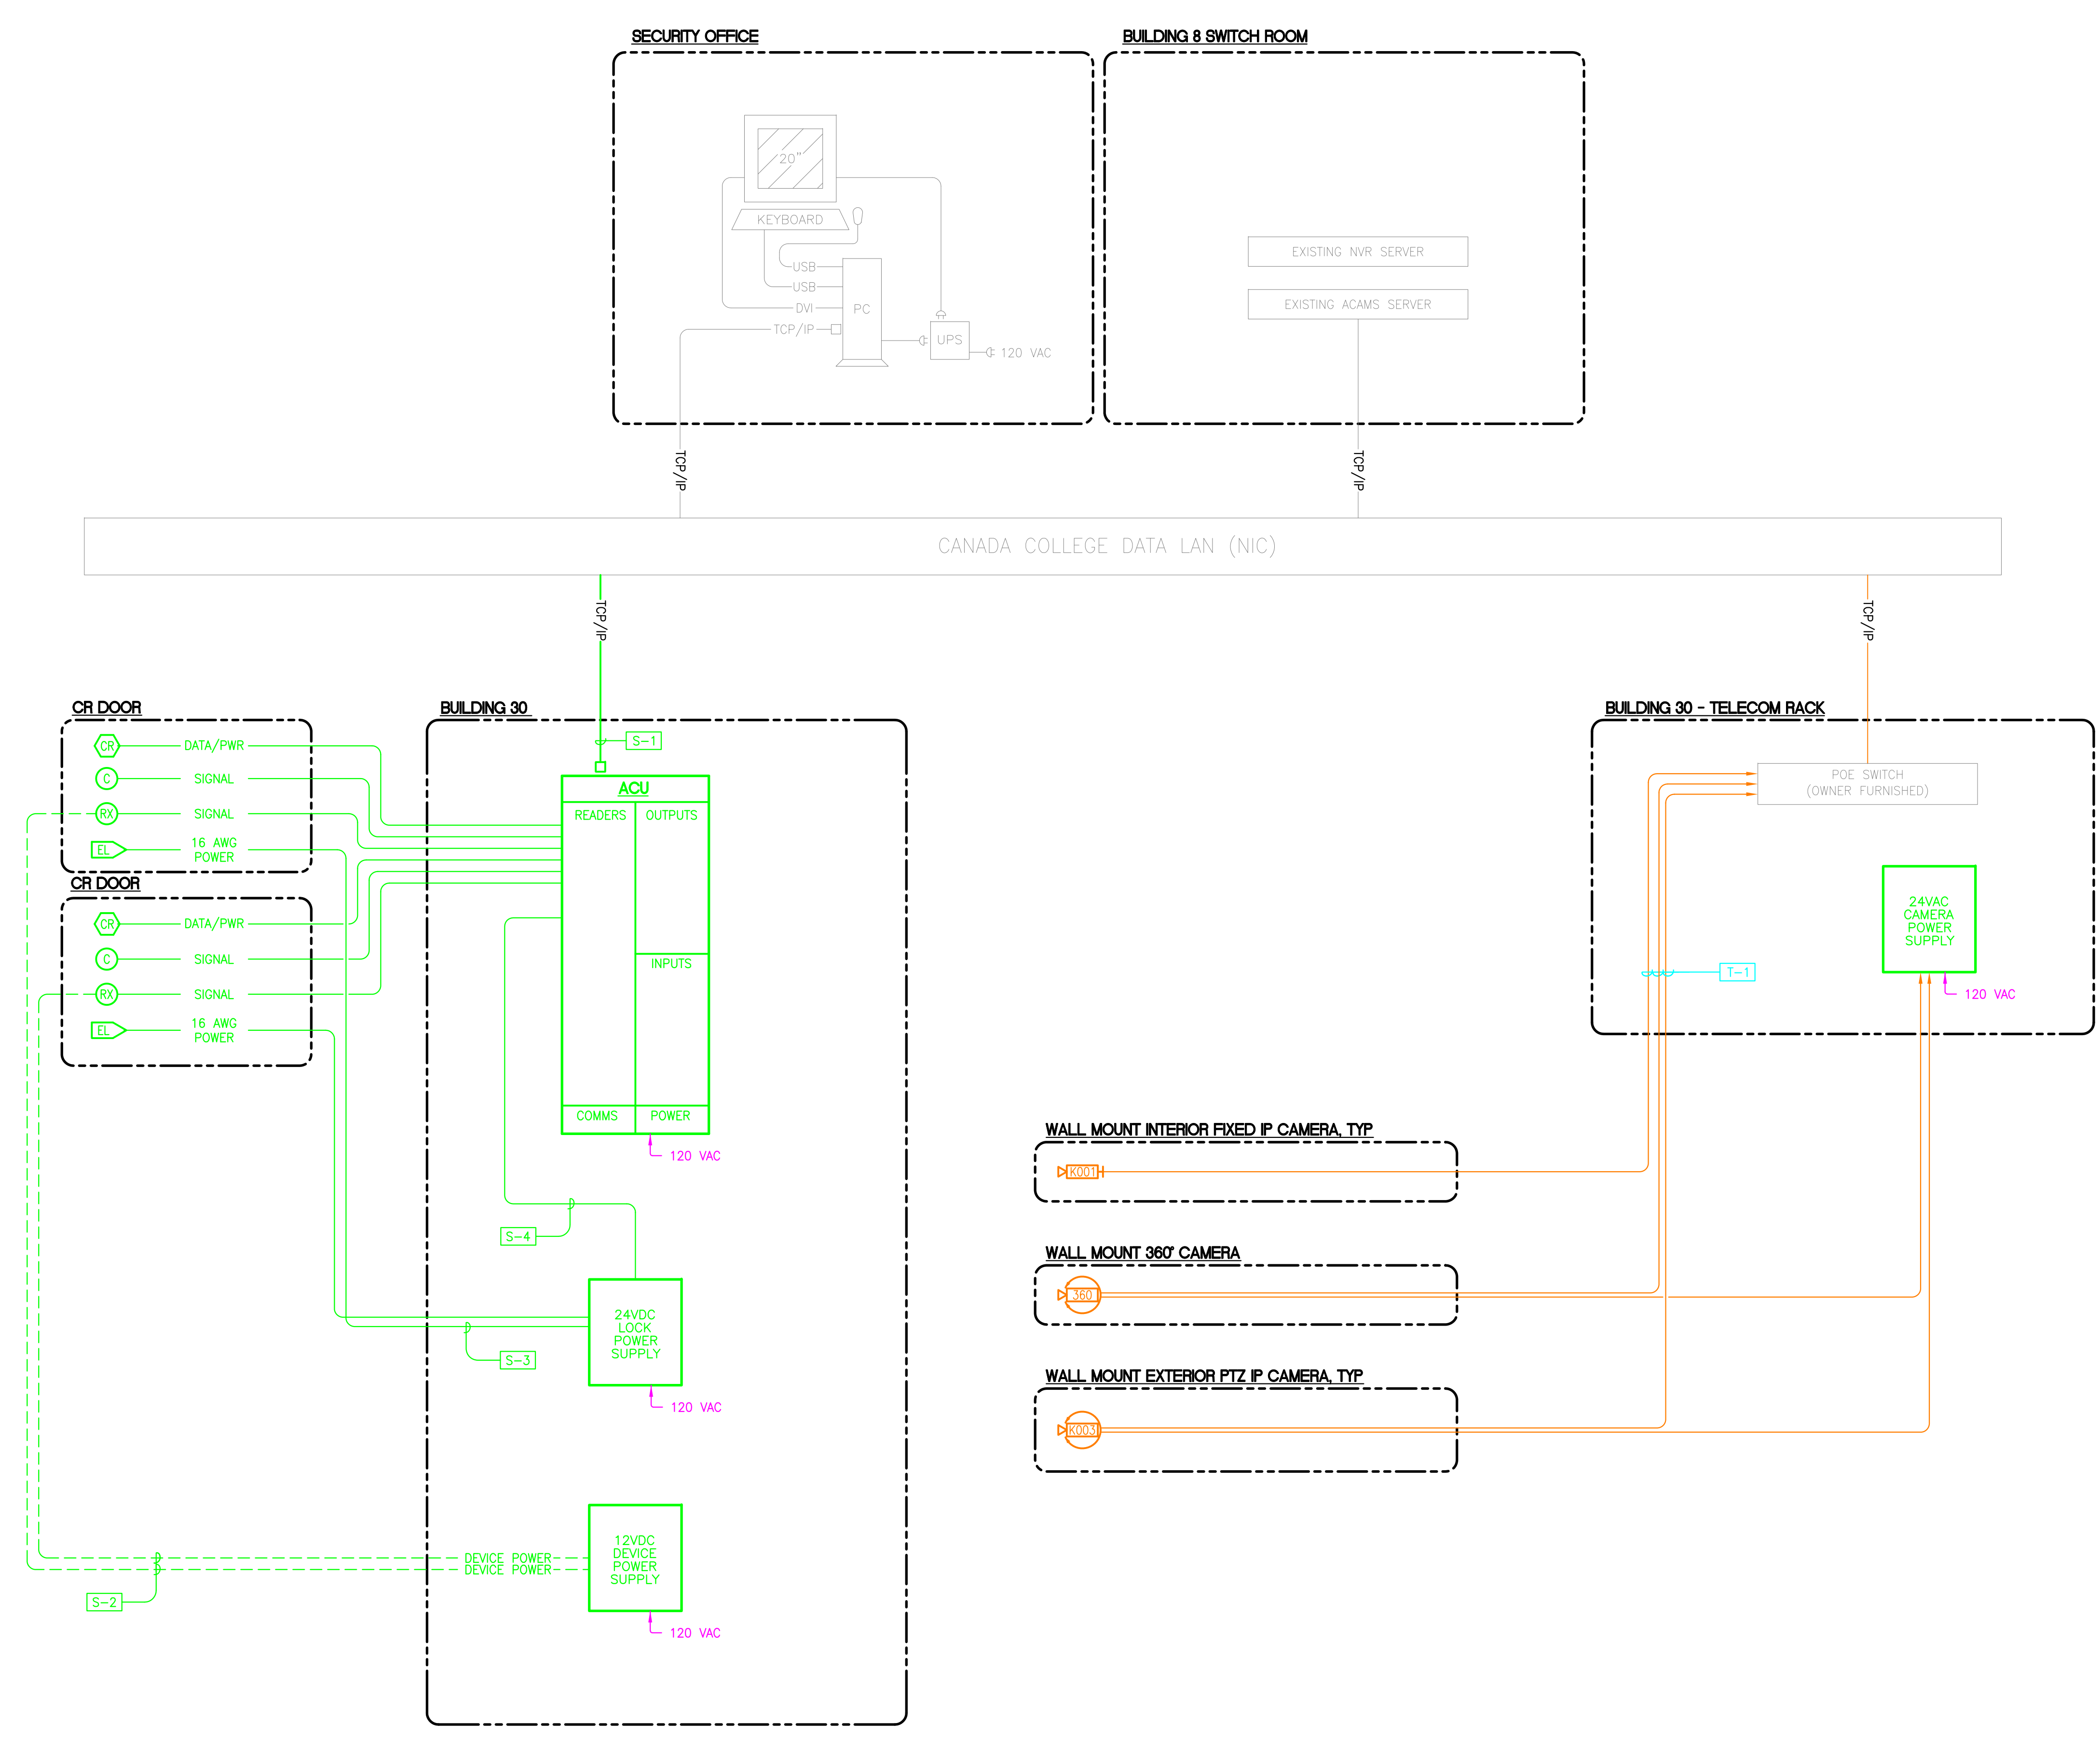

IDENTIFICATION STAMP
DIVISION OF THE STATE ARCHITECT
APPLICATION NUMBER 01-111618
AC _____
DATE _____

CALIFORNIA STATE FIRE MARSHAL
APPROVED
APPROVAL OF THIS PLAN DOES NOT AUTHORIZE OR APPROVE ANY
CONSTRUCTION OR DEVIATION FROM APPLICABLE REGULATIONS. FINAL
APPROVAL IS SUBJECT TO REGISTRATION. ONE SET OF APPROVED
PLANS SHALL BE AVAILABLE ON THE PROJECT SITE AT ALL TIMES.
REVIEWED BY: _____ DATE: _____

CAÑADA COLLEGE
Electrical
Infrastructure
Replacement
Project
4200 Farm Hill Blvd
Redwood City, CA 94061

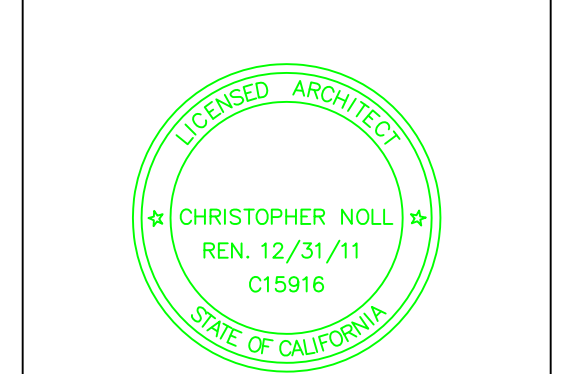

RECORD DRAWING

SHEET TITLE
**BLOCK DIAGRAM
ACAMS + VSS**

REVISIONS		
NO.	DATE	DESCRIPTION

DATE July 9, 2012
DRAWN T&CM
CHECKED MAPA
SCALE NTS
JOB NO. 2921.01

SHEET NUMBER
SYO.11

BLOCK DIAGRAM - ACAMS + VSS
SCALE: NTS

File: A44_122228.dwg Date: 7/11/2012 10:02 AM 100% C:\12228\12228.dwg