
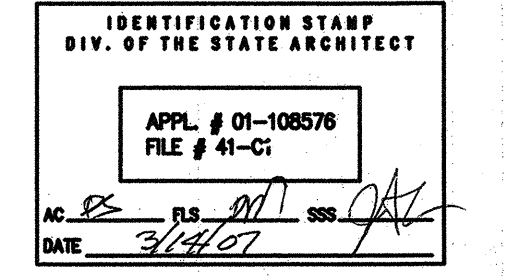


Copyright © 2007 Steinberg Architects. All rights reserved. This drawing is the property of Steinberg Architects. No part of this drawing may be reproduced without the written consent of Steinberg Architects.

STEINBERG ARCHITECTS
1000 UNIVERSITY AVENUE, SUITE 1000
SAN FRANCISCO, CALIFORNIA 94133
PHONE: 415.774.1000
FAX: 415.774.1001
WWW.STEINBERGARCHITECTS.COM

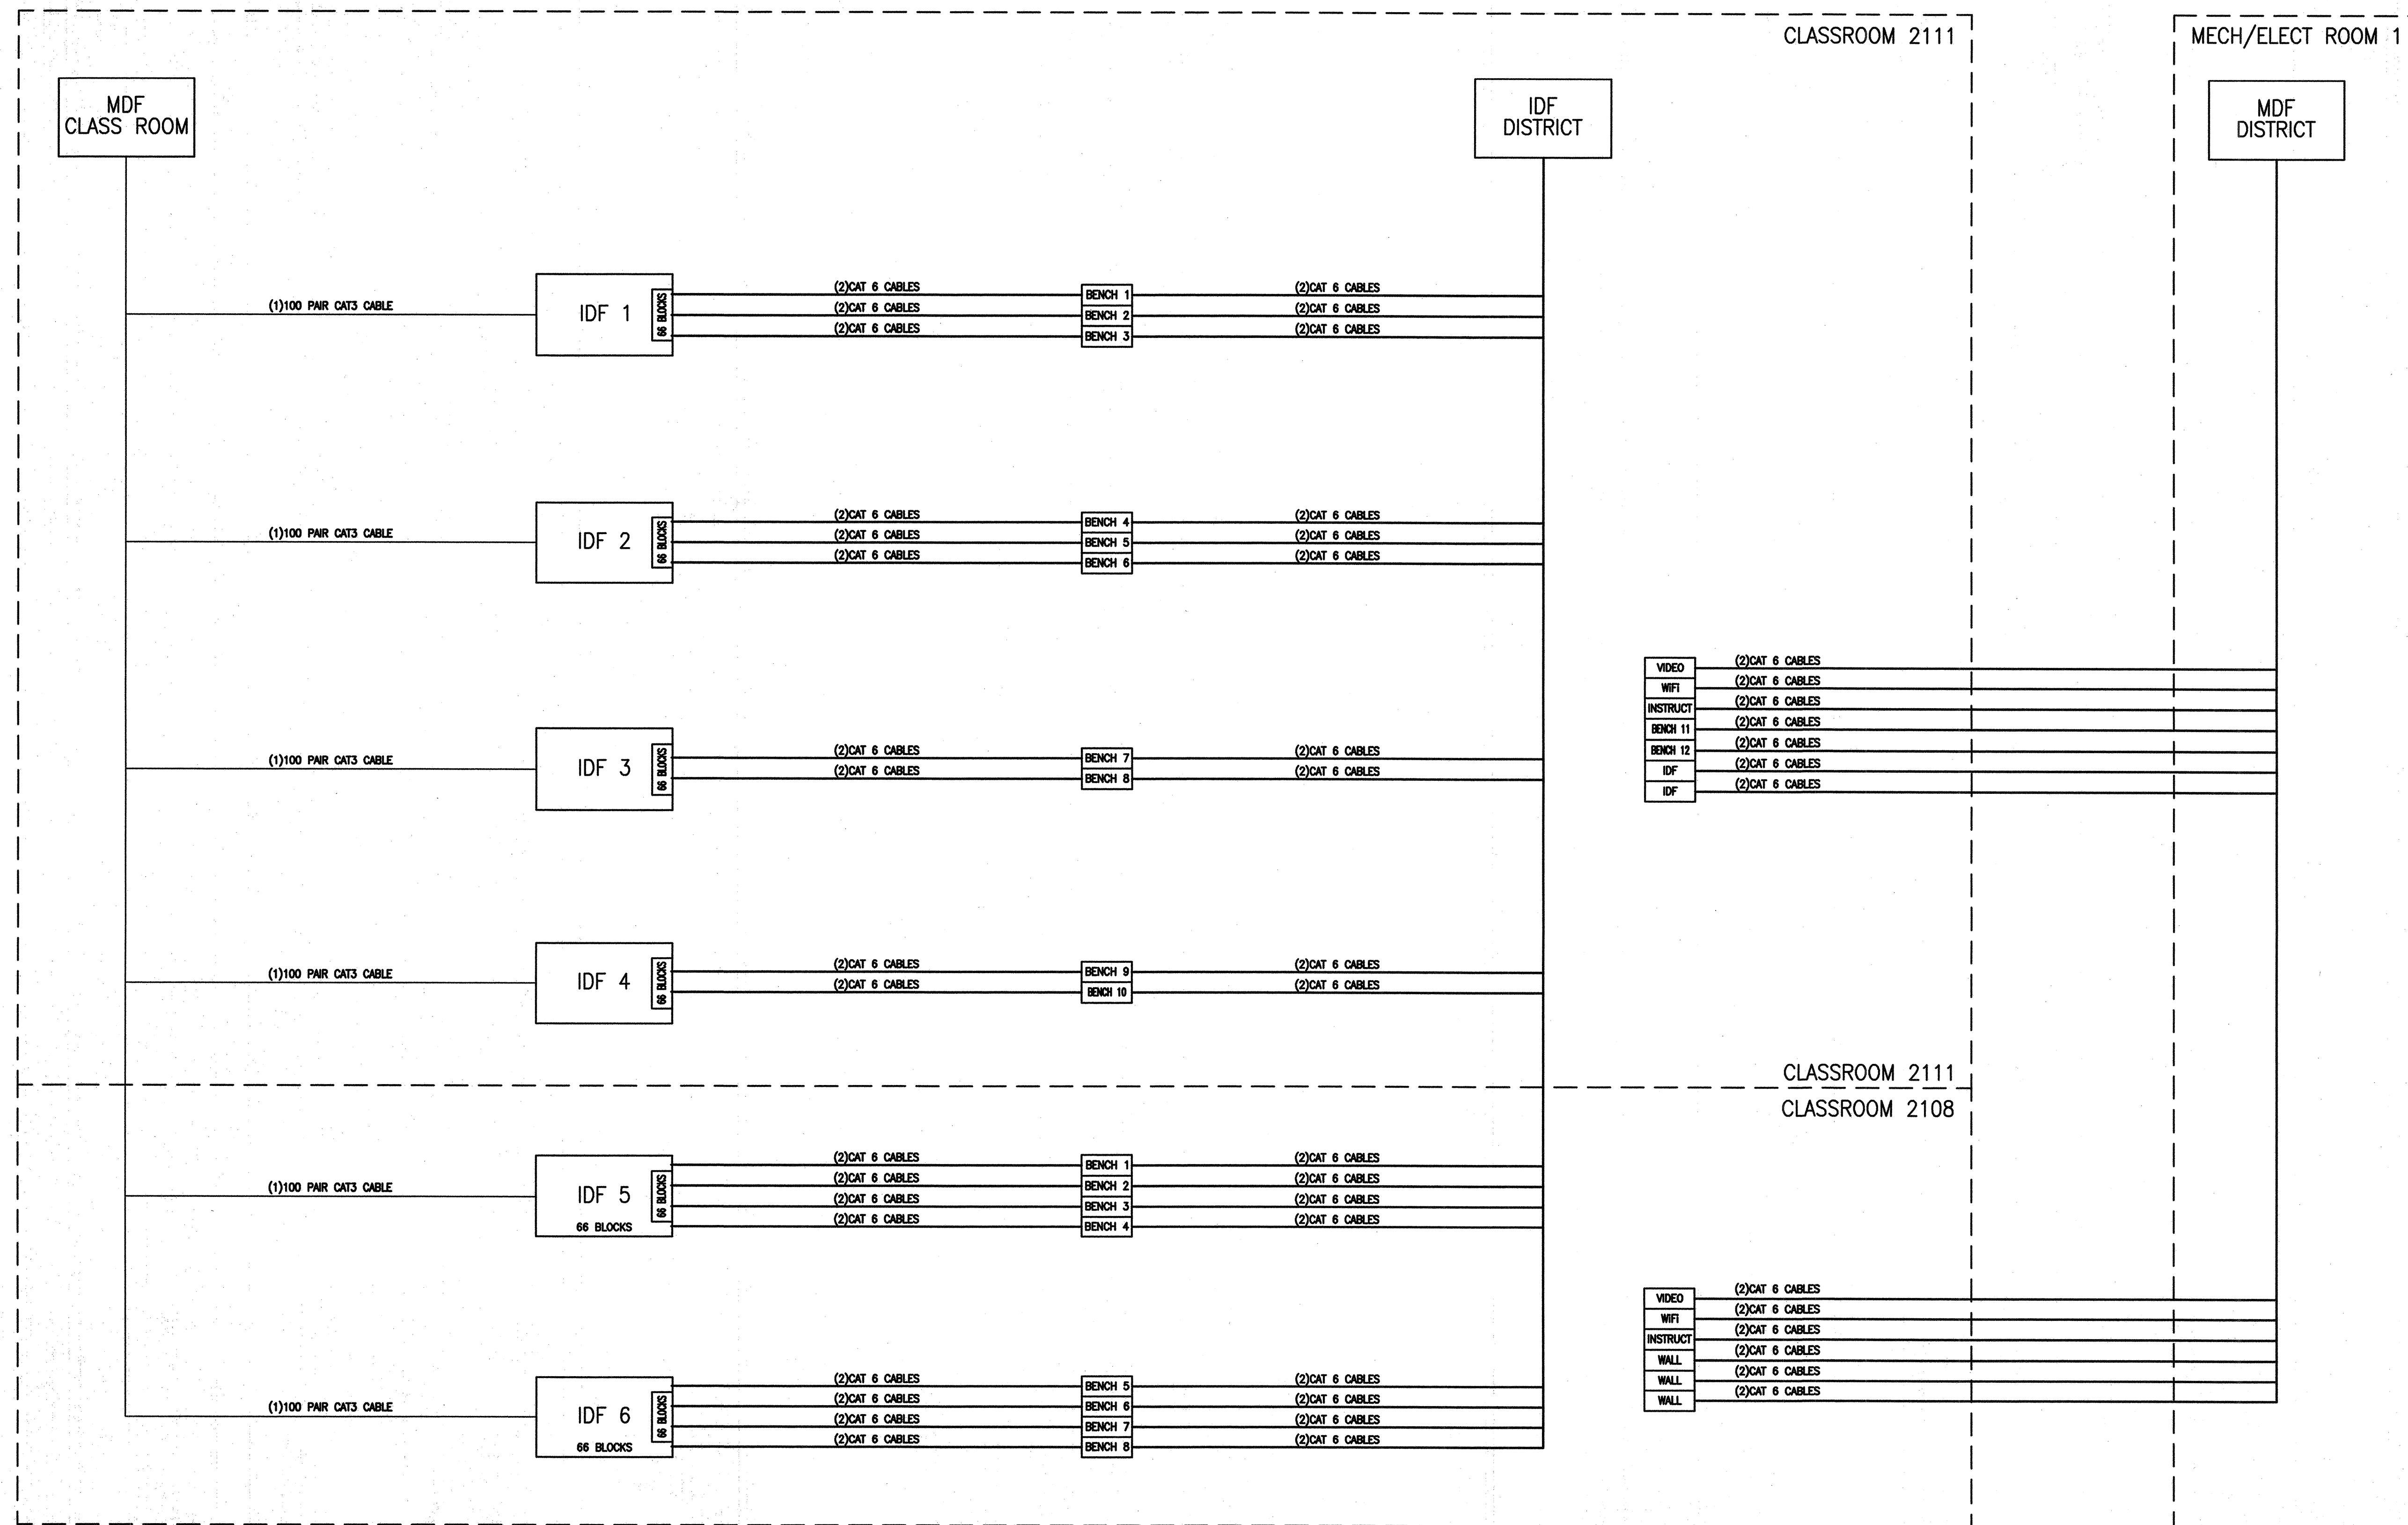

02.02.07 DSA SUBMITTAL
DSA BACKCHECK

rev. date issue

STEINBERG ARCHITECTS
project no: 06044 date: 03/15/07
drawn by: MVP checked by: JW
scale: NTS 1" = 1'-0"

TECHNOLOGY
SINGLE LINE DIAGRAM